

**PROPOSED REHABILITATION
DR.AYUB FOOTBALL STADIUM IN
- BAIDOA -**




PROPOSED REHABILITATION DR.AYUB FOOTBALL STADIUM IN - BAIDOA -

June 2018

DRAWING INDEX

	SHEET N ^o	DRAWING N ^o	DRAWING CONTENT
01.	01/24		Cover Page
02.	02/24		Drawing Index
03.	03/24		Site Photos
04.	04/24		Site Analysis
05.	05/24		Proposed Master Plan
06.	06/24		3D RENDER 01
07.	07/24		3D RENDER 02
08.	08/24		3D RENDER 03
09.	09/24		3D RENDER 04
10.	10/24	Changing rooms	Floor layout
11.	10/24	Changing rooms	Elevations and Section
12.	12/24	Changing rooms	Electrical Plan
13.	13/24	Changing rooms	3D RENDER
14.	14/24	Offices	Floor layout
15.	15/24	Offices	Elevations and Section
16.	16/24	Offices	Electrical Plan
17.	17/24	Offices	3D RENDER
18.	18/24	Meeting Hall	Floor layout and Elevations
19.	19/24	Meeting Hall	3D Render
20.	20/24	Spectators Stand	Floor layout and Elevations
21.	21/24	Spectators Stand	3D Render
22.	22/24	Latrines	Floor layout and Elevations
23.	23/24	Latrines	3D Render
24.	24/24	Boundary wall	Boundary wall detail

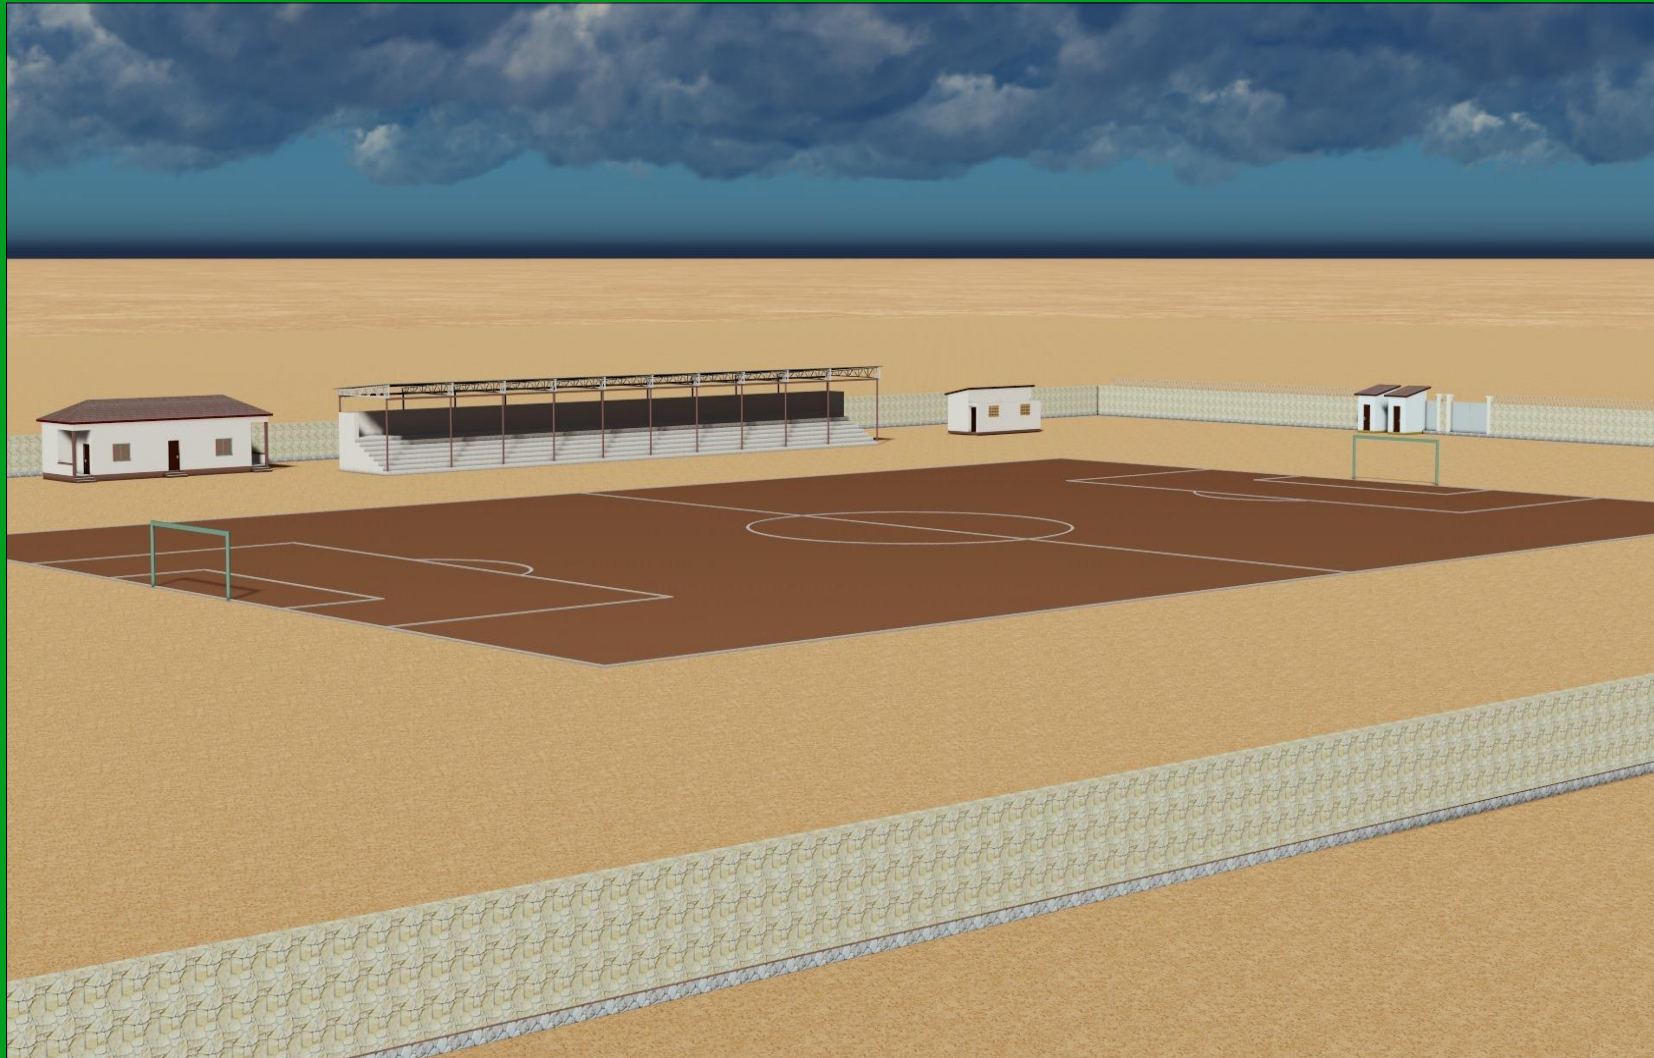



PROJECT DETAILS

Client:

Implementation Partner:

Project title:

Drawing Title:

Reviewed by:

Site Photos

Eng. David Wanja

Drawn by:

Checked by:

Sheet No.

Scale: N/A

Eng. Duale Salah

03

Date: June, 2018


ARCHITECTURAL DRAWINGS



**SOUTH WEST STATE
-SOMALIA-**

**INTERNATIONAL ORGANIZATION
FOR MIGRATION (IOM)**

**PROPOSED REHABILITATION OF DR. AYUUB
FOOTBALL STADIUM IN BAIDOA**

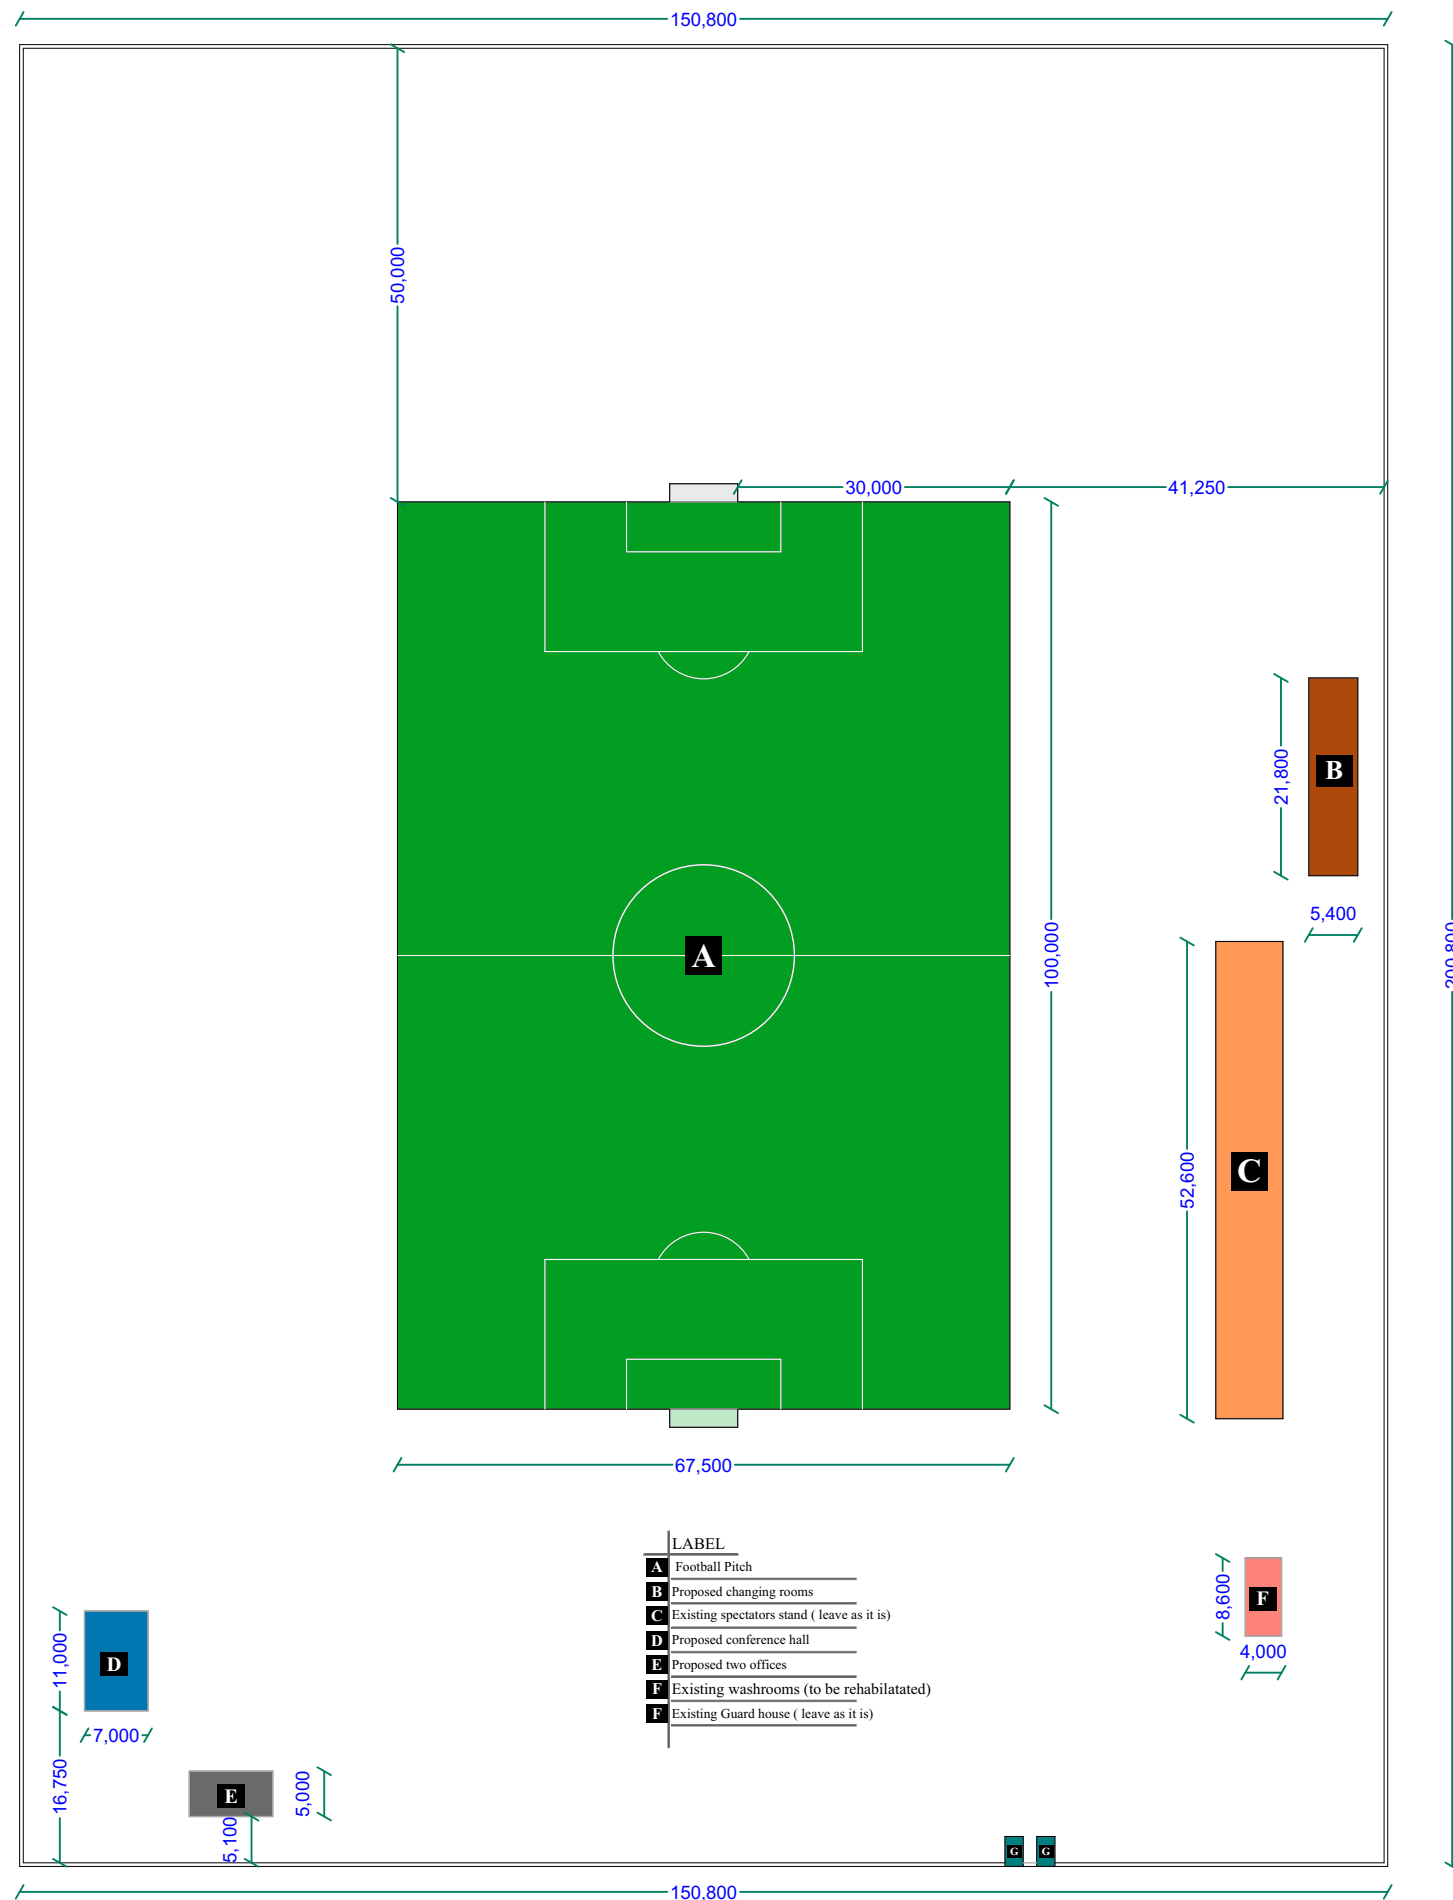

PROJECT DETAILS

Client:



**SOUTH WEST STATE
-SOMALIA-**

Implementation Partner:

**INTERNATIONAL ORGANIZATION
FOR MIGRATION (IOM)**

Project title:

**PROPOSED REHABILITATION OF DR. AYUUB
FOOTBALL STADIUM IN BAIDOA**

Drawing Title:

Site Analysis

Reviewed by:

Eng. David Wanja

Drawn by:

Eng. Duale Salah

Checked by:


Sheet No.

04


Scale: N/A

Date: June, 2018

ARCHITECTURAL DRAWINGS

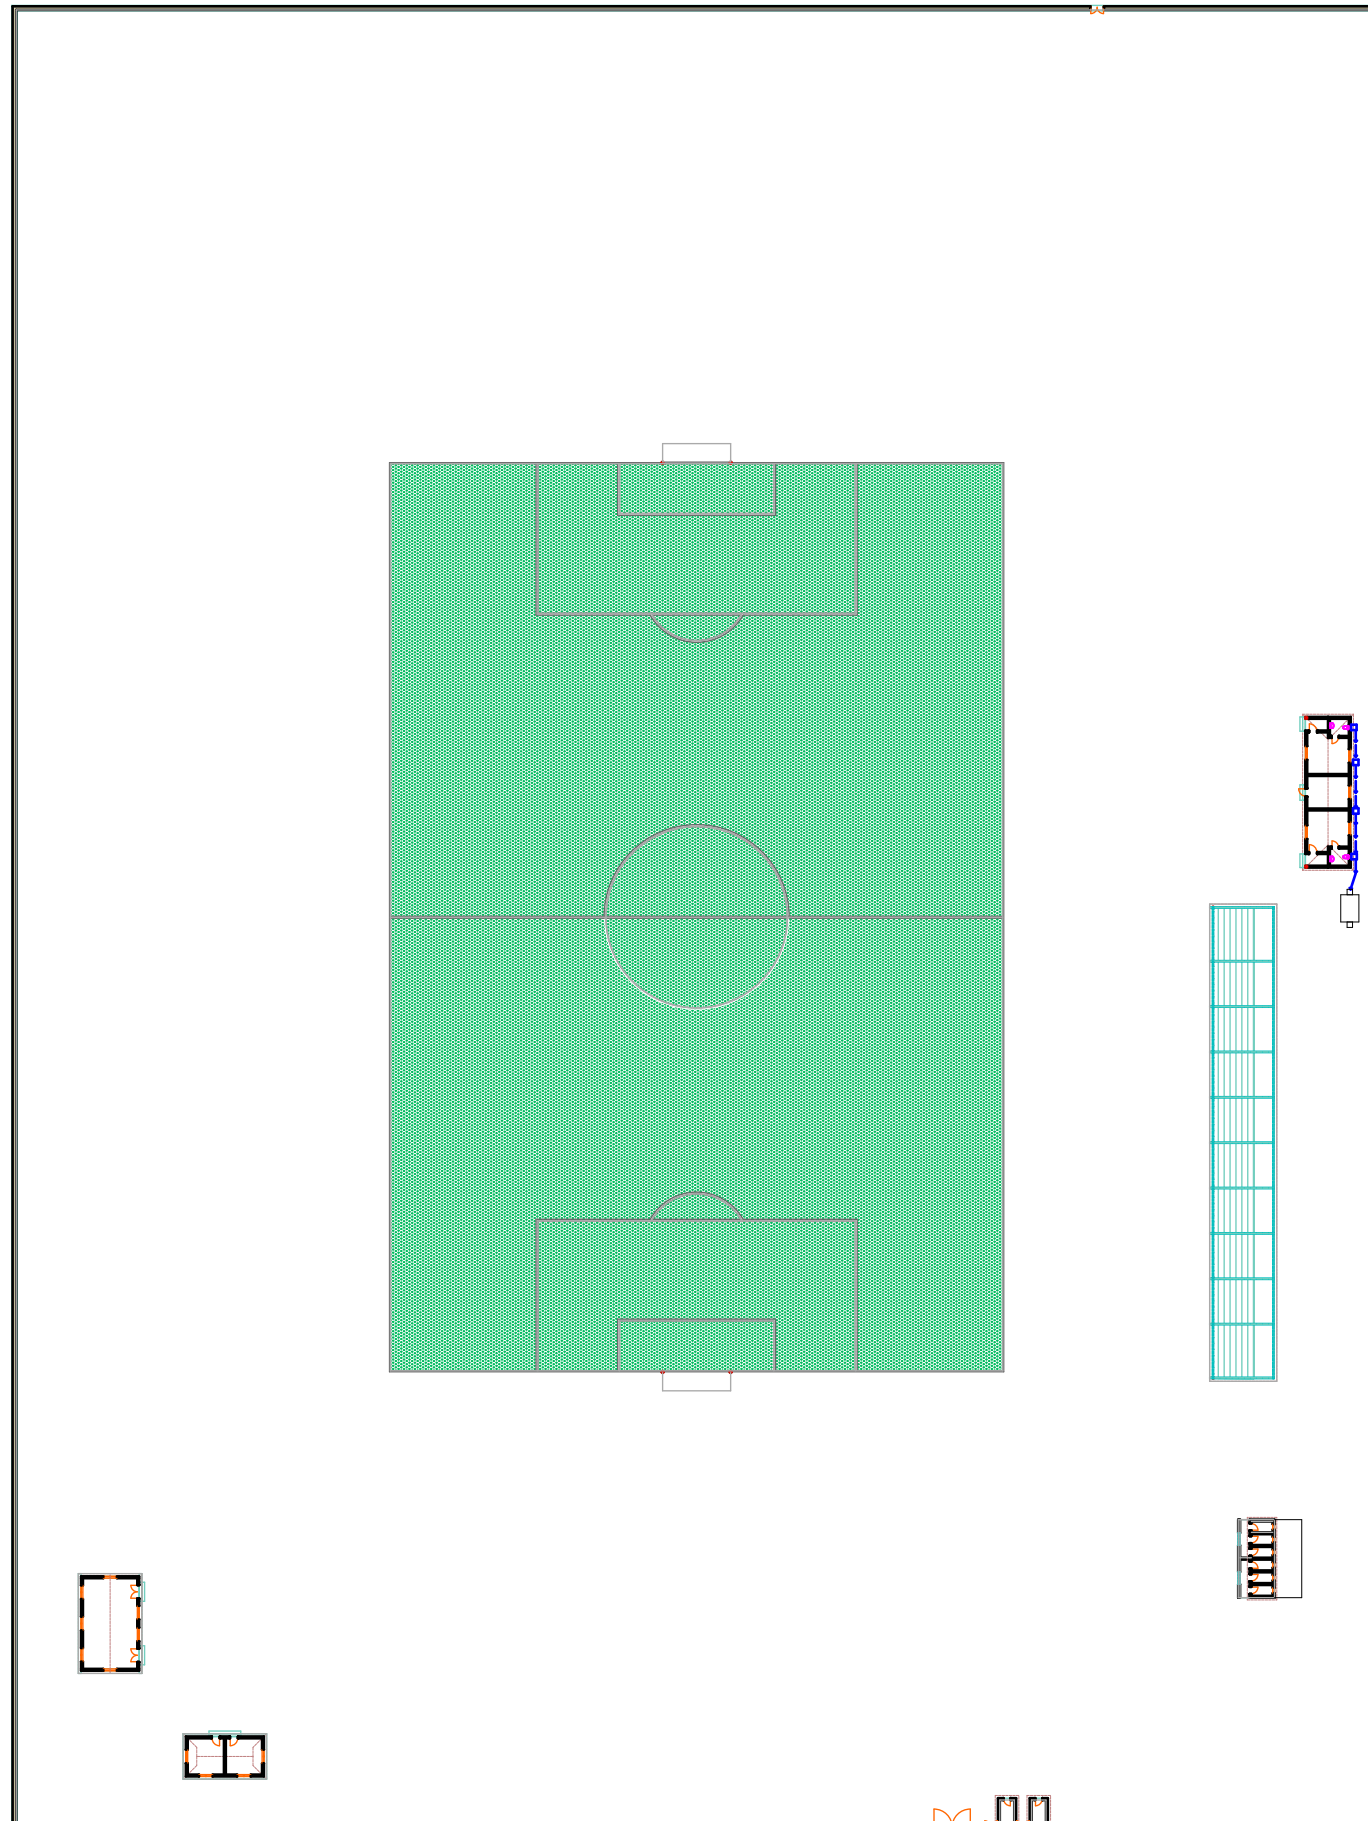

Build the wall gaps with rubble stone (40cm thick) cement-sand mortar and then extend 600mm high rubble stone walling to existing wall jointed in C.S. mortar

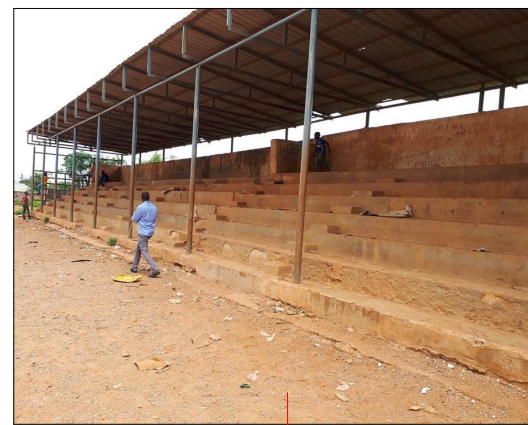

Allow for grading of the existing surface of the pitch including clearing, importing of suitable materials for section with depressions and compact to engineer's satisfaction



Rehabilitate the existing latrines as per specification

Supply and fix new gates with Two pillars of RCC columns as per specification

PROJECT DETAILS

Client:



**SOUTH WEST STATE
-SOMALIA-**

Implementation Partner:

**INTERNATIONAL ORGANIZATION
FOR MIGRATION (IOM)**

Project title:

**PROPOSED REHABILITATION OF DR. AYUUB
FOOTBALL STADIUM IN BAIDOA**

Drawing Title:

Proposed Master Plan

Reviewed by:

Eng. David Wanja

Drawn by:

Eng. Duale Salah

Checked by:



Sheet No.

05

Scale: N/A

Date: June, 2018

ARCHITECTURAL DRAWINGS

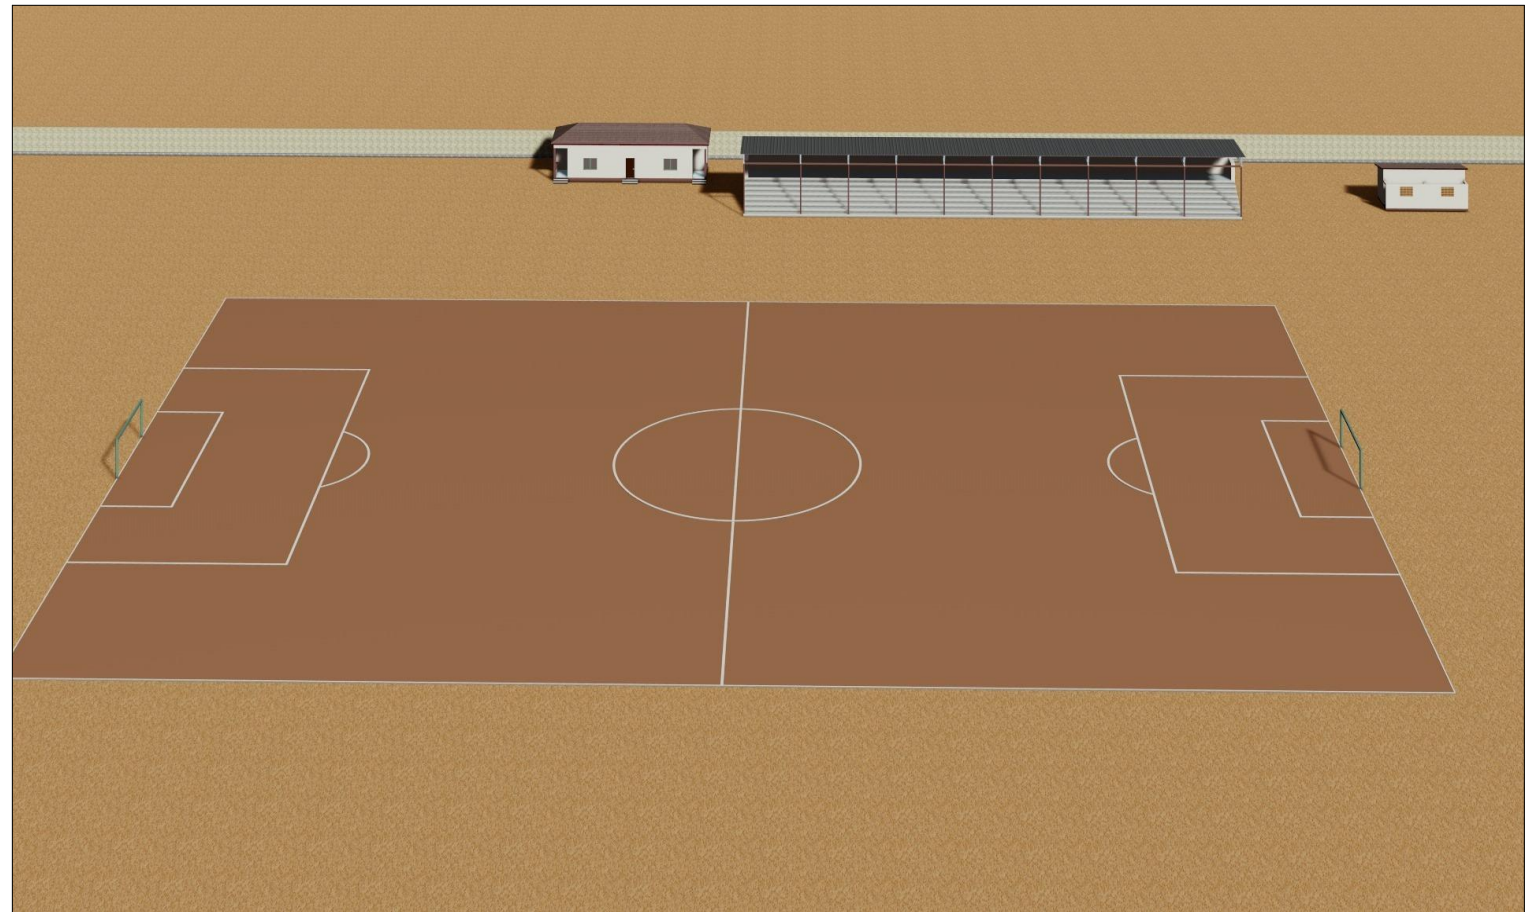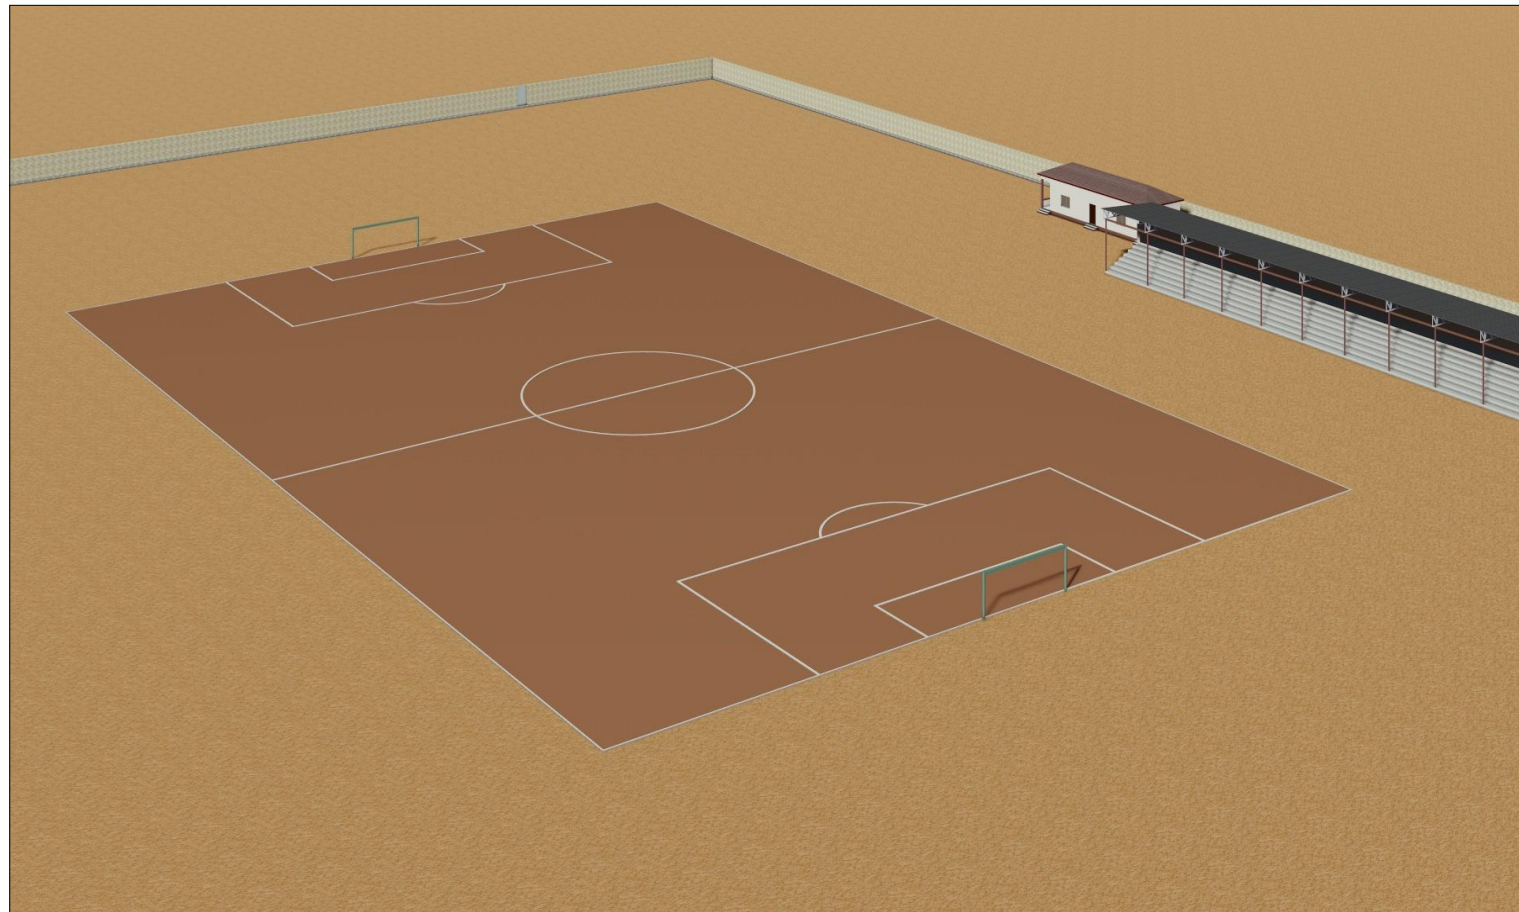

PROJECT DETAILS

Client:

Implementation Partner:

Project title:



**SOUTH WEST STATE
-SOMALIA-**

**INTERNATIONAL ORGANIZATION
FOR MIGRATION (IOM)**

**PROPOSED REHABILITATION OF DR. AYUUB
FOOTBALL STADIUM IN BAIDOA**

Drawing Title:

3D Projection

Reviewed by:

Eng. David Wanja

Drawn by:

Eng. Duale Salah

Checked by:



Sheet No.

06

Scale: N/A

Date: June, 2018

ARCHITECTURAL DRAWINGS

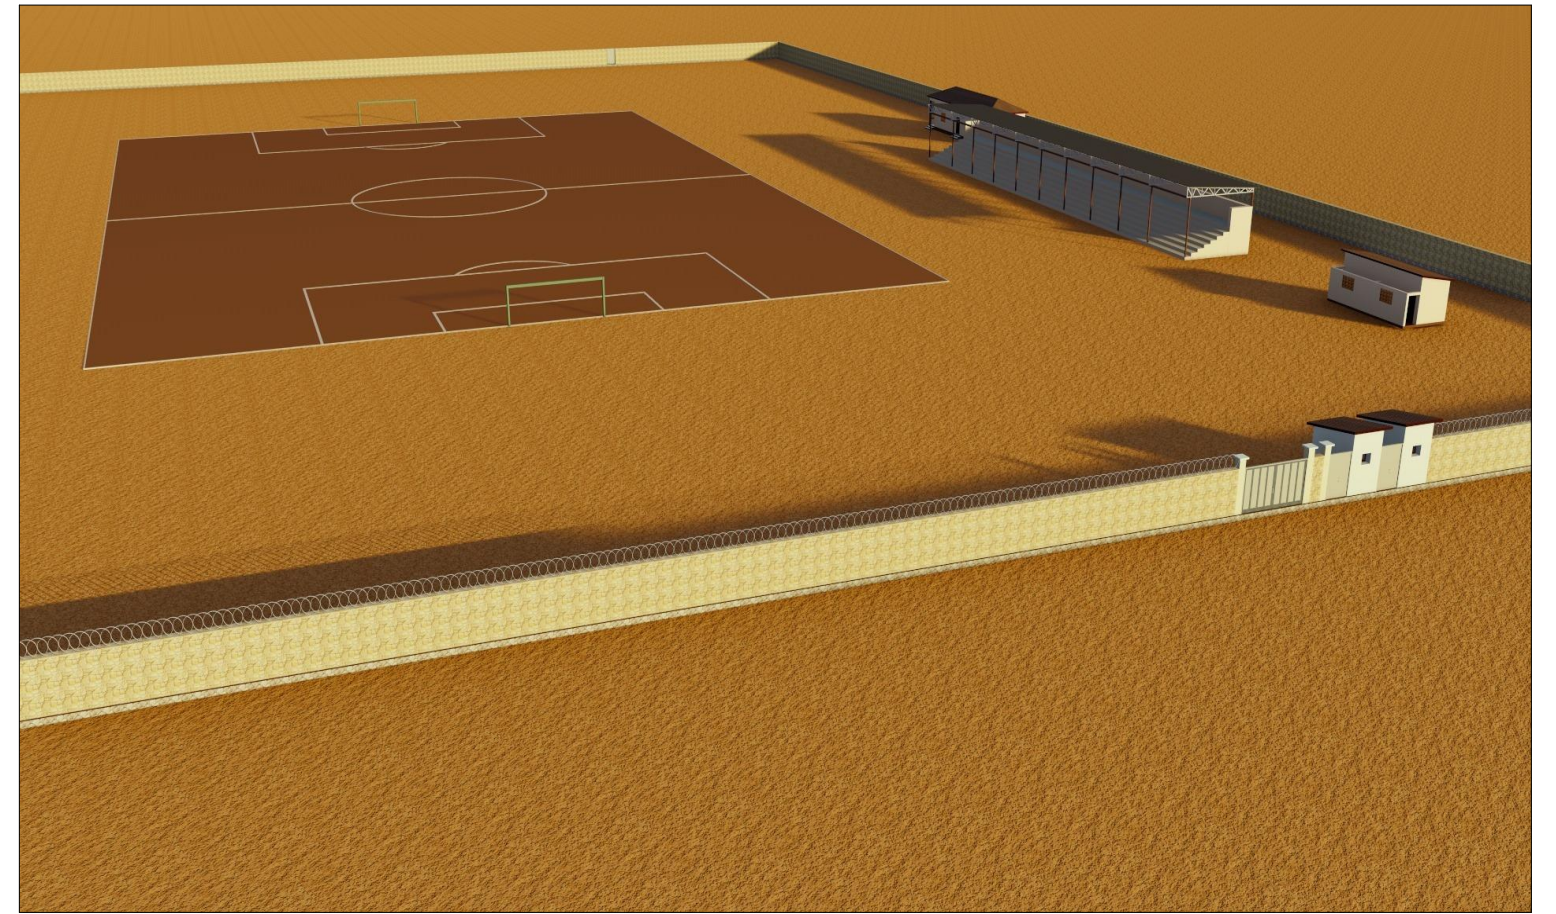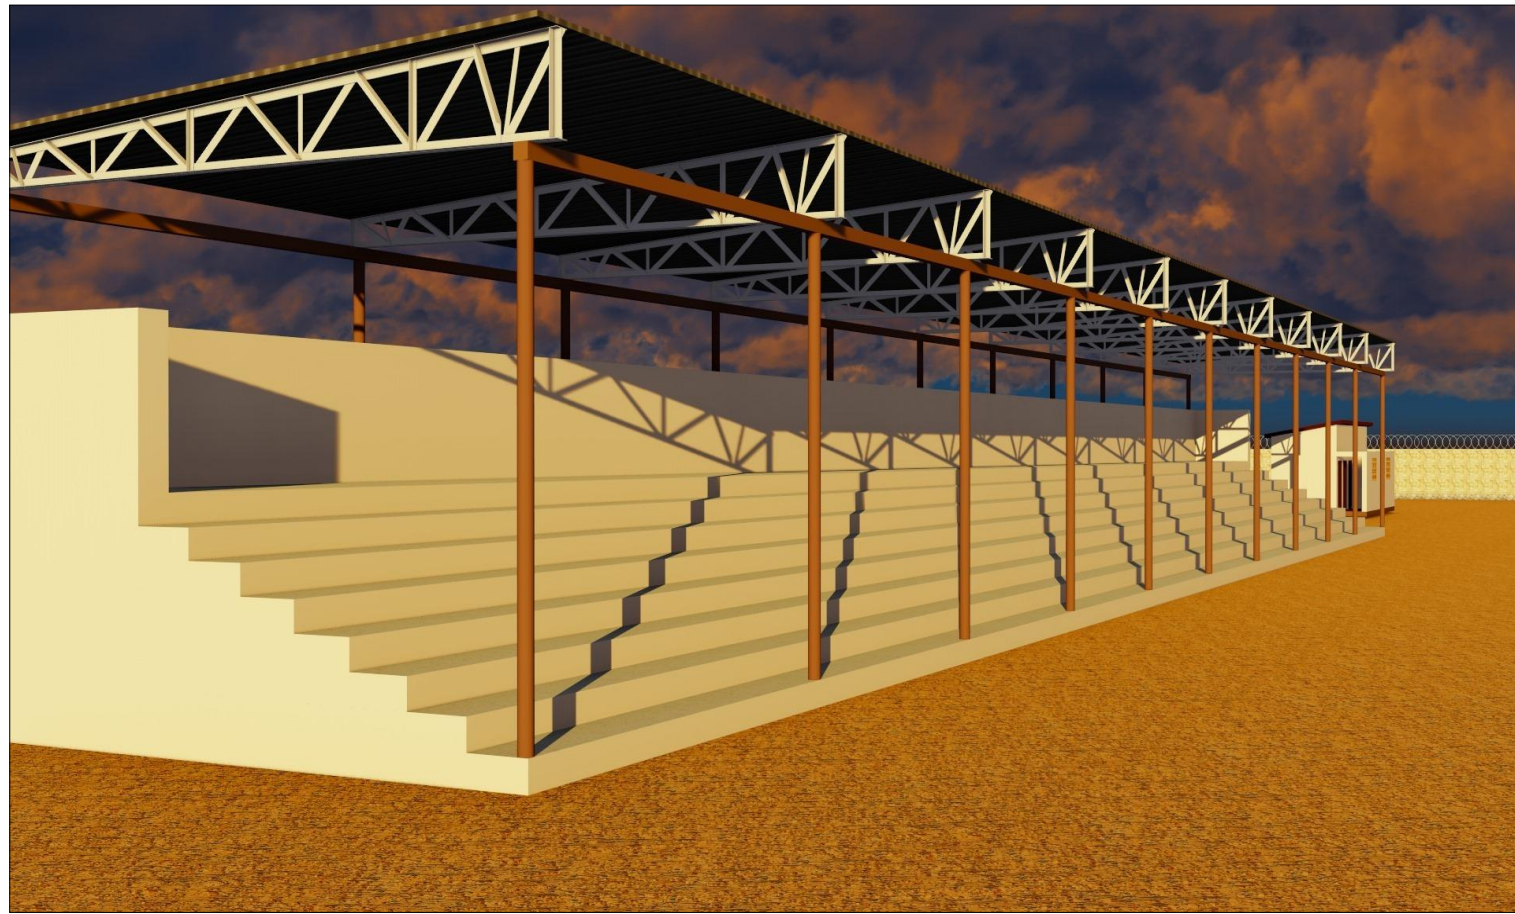

PROJECT DETAILS

Client:

Implementation Partner:

Project title:



**SOUTH WEST STATE
-SOMALIA-**

**INTERNATIONAL ORGANIZATION
FOR MIGRATION (IOM)**

**PROPOSED REHABILITATION OF DR. AYUUB
FOOTBALL STADIUM IN BAIDOA**

Drawing Title:

3D Projection

Reviewed by:

Eng. David Wanja

Drawn by:

Eng. Duale Salah

Checked by:

Sheet No.

07

Scale: N/A

Date: June, 2018

ARCHITECTURAL DRAWINGS



PROJECT DETAILS

Client:



**SOUTH WEST STATE
-SOMALIA-**

Implementation Partner:

**INTERNATIONAL ORGANIZATION
FOR MIGRATION (IOM)**

Project title:

**PROPOSED REHABILITATION OF DR. AYUUB
FOOTBALL STADIUM IN BAIDOA**

Drawing Title:

3D Projection

Reviewed by:

Eng. David Wanja

Drawn by:

Eng. Duale Salah

Checked by:



Sheet No.

08

Scale: N/A

Date: June, 2018

ARCHITECTURAL DRAWINGS

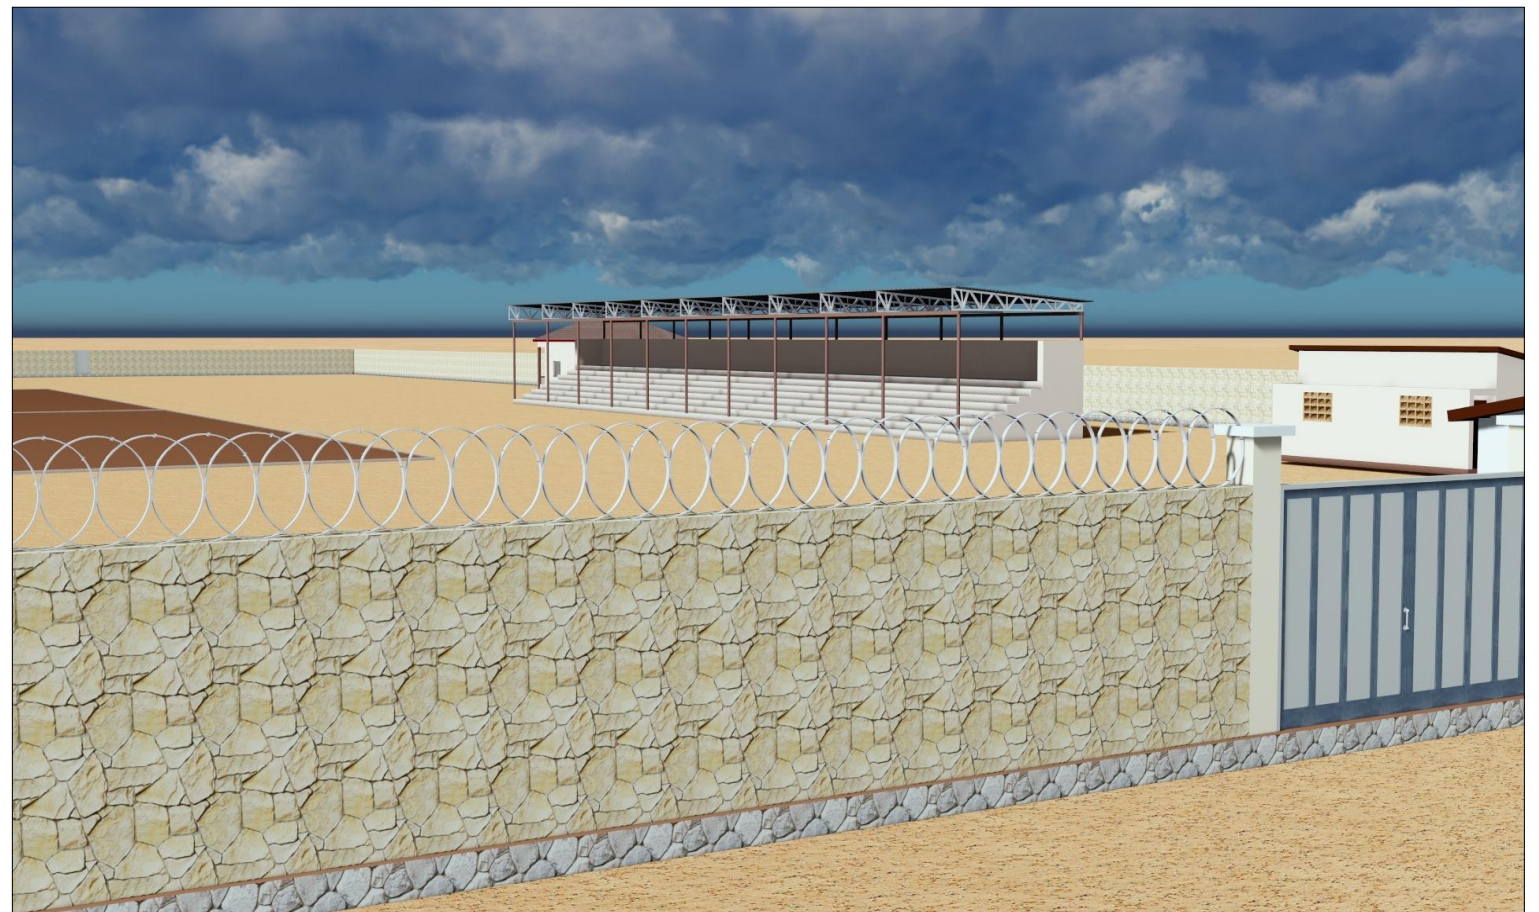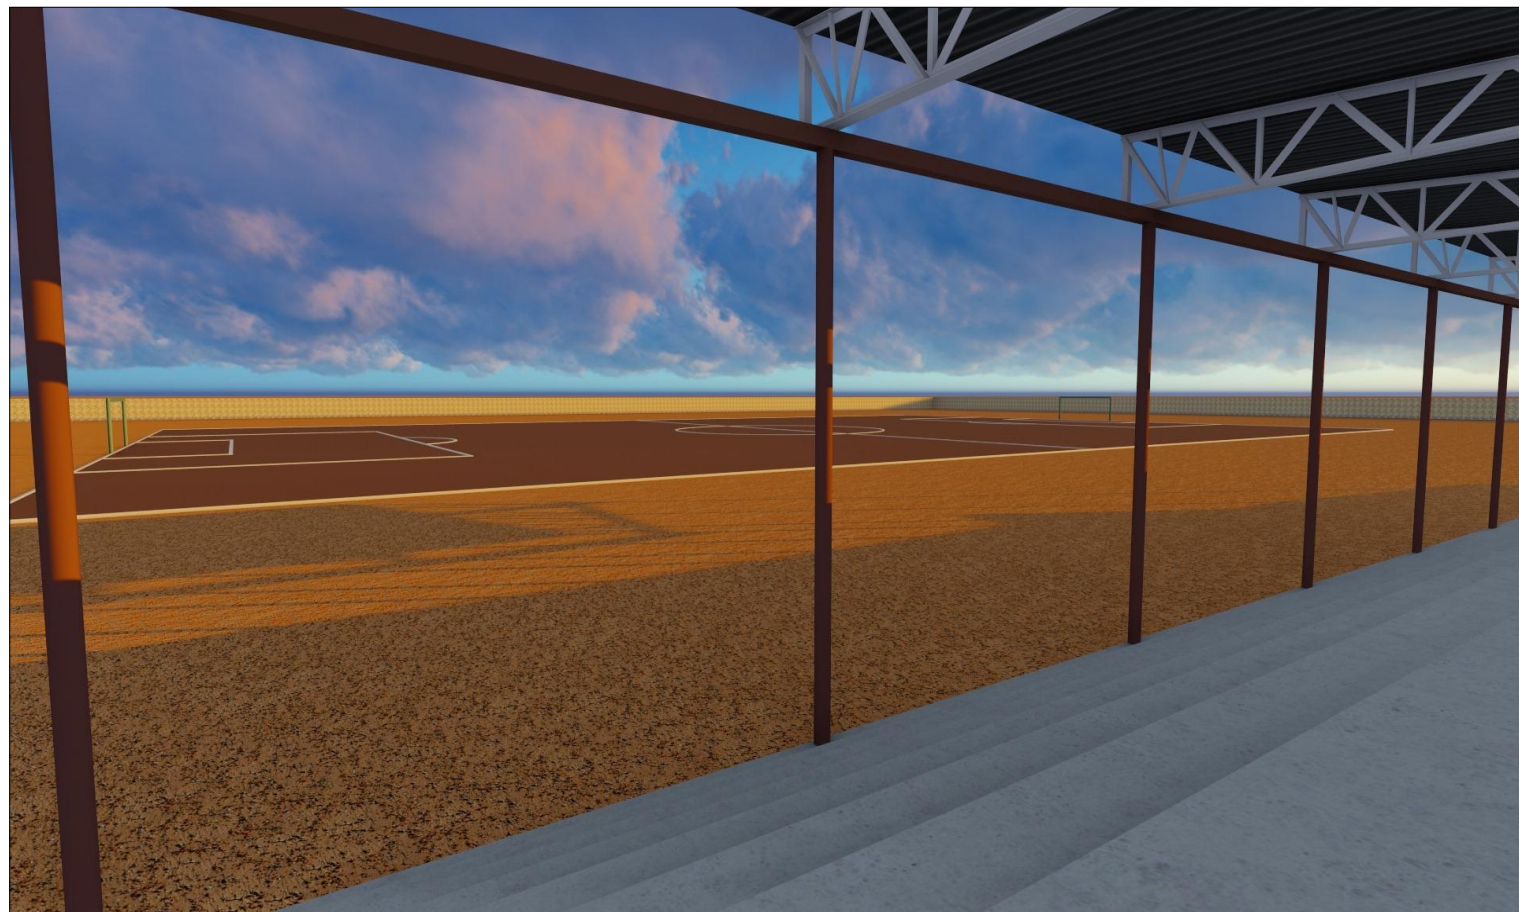

PROJECT DETAILS

Client:

Implementation Partner:

Project title:



**SOUTH WEST STATE
-SOMALIA-**

**INTERNATIONAL ORGANIZATION
FOR MIGRATION (IOM)**

**PROPOSED REHABILITATION OF DR. AYUUB
FOOTBALL STADIUM IN BAIDOA**

Drawing Title:

3D Projection

Reviewed by:

Eng. David Wanja

Drawn by:

Eng. Duale Salah

Checked by:


Sheet No.

08


Scale: N/A

Date: June, 2018

ARCHITECTURAL DRAWINGS

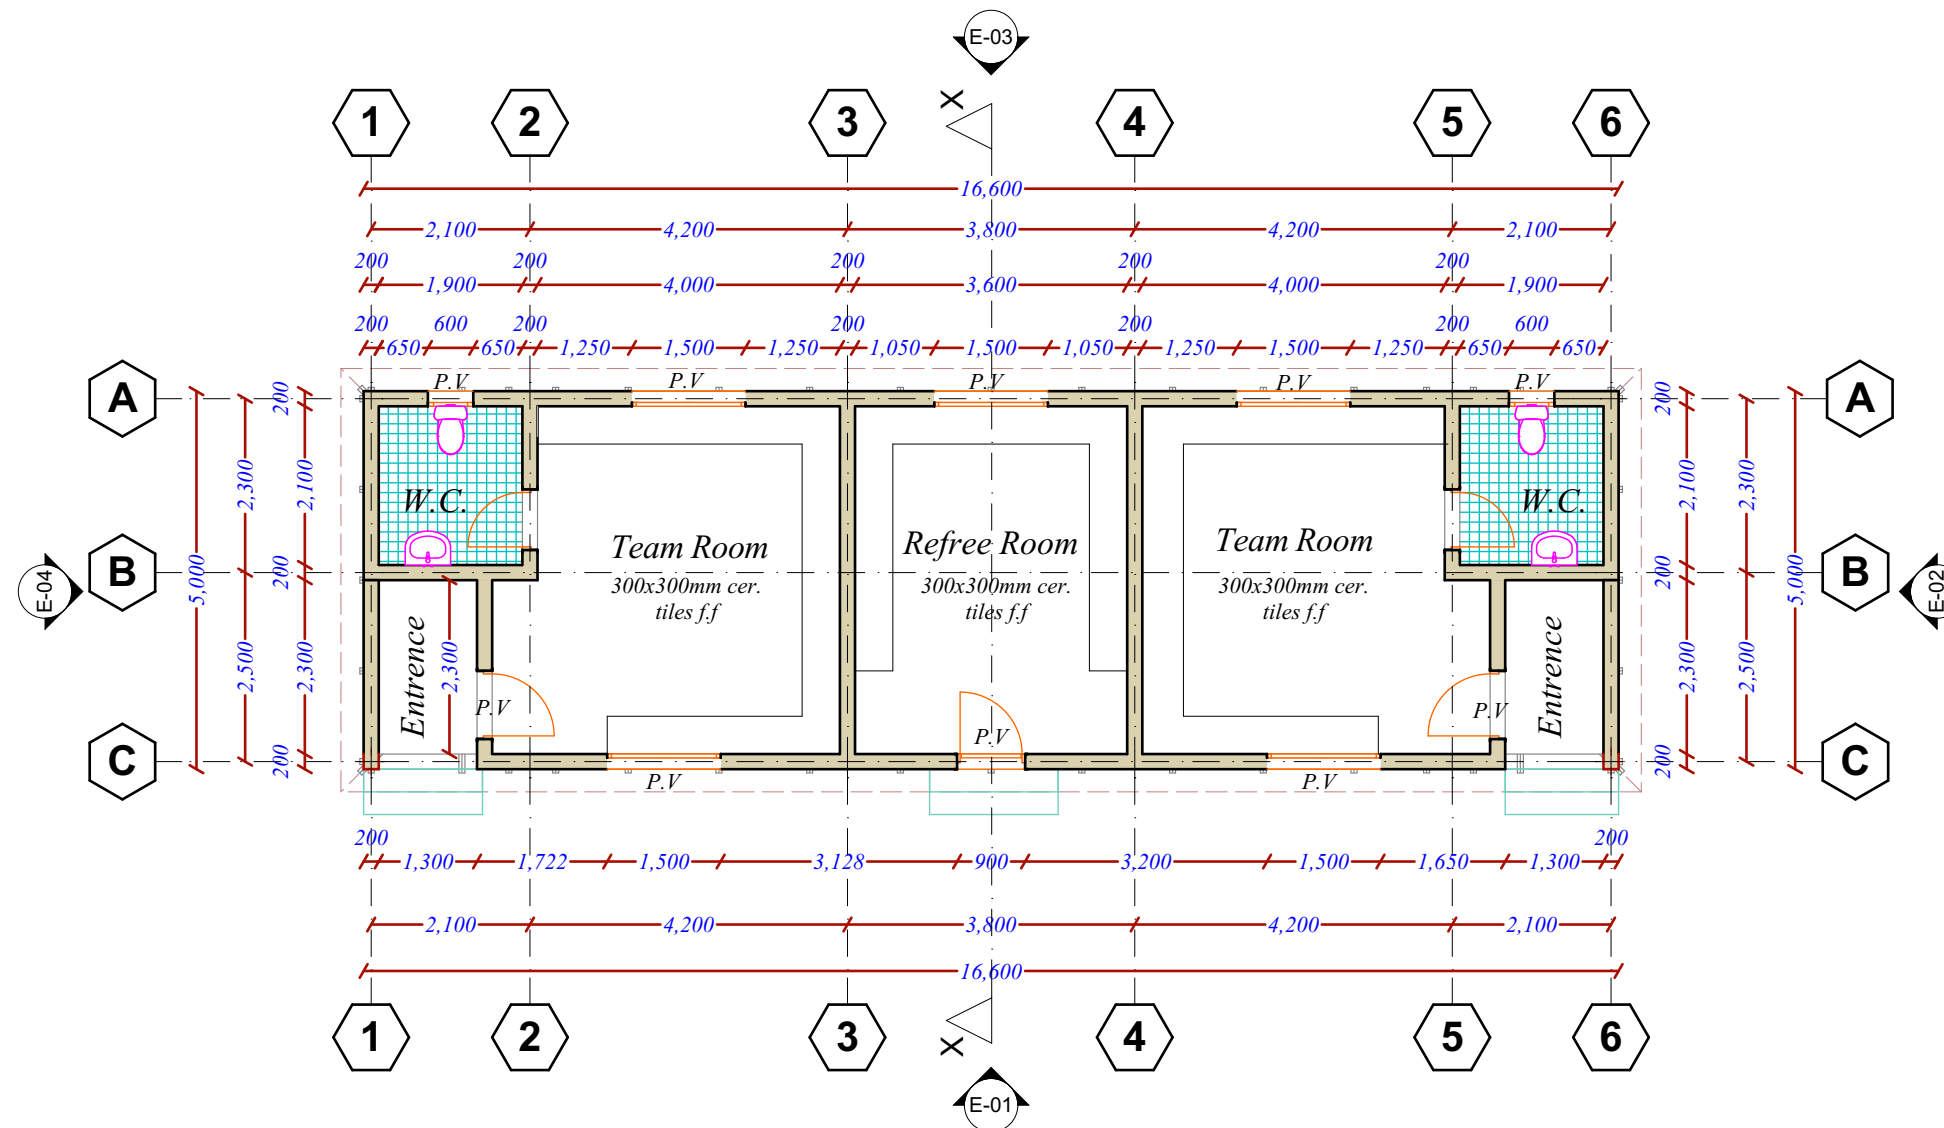

Typical Floor Plan - Changing rooms

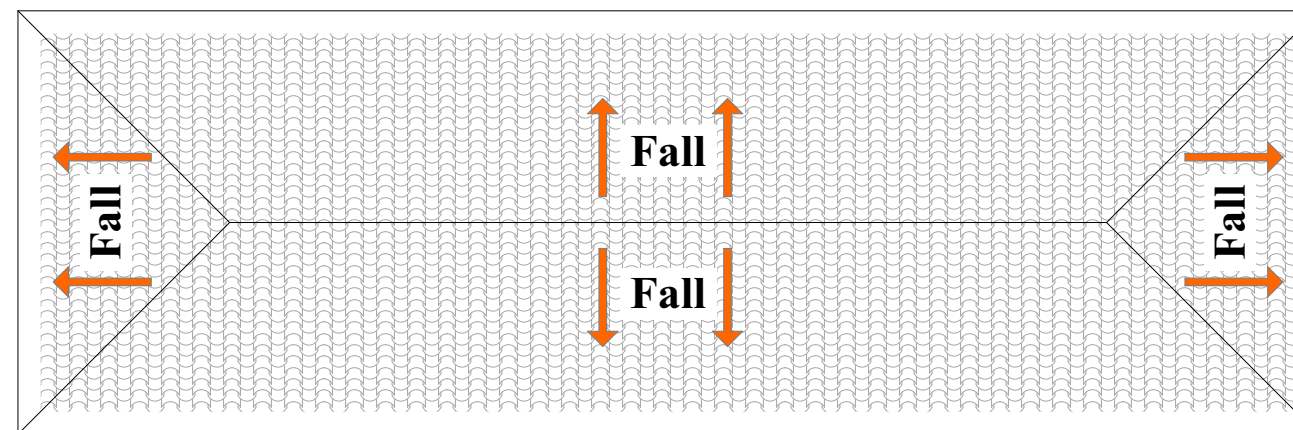

Roof Plan - Changing rooms

PROJECT DETAILS

Client:



**SOUTH WEST STATE
-SOMALIA-**

Implementation Partner:

**INTERNATIONAL ORGANIZATION
FOR MIGRATION (IOM)**

Project title:

**PROPOSED REHABILITATION OF DR. AYUUB
FOOTBALL STADIUM IN BAIDOA**

Drawing Title:

Changing Rooms- floor plan

Reviewed by:

Eng. David Wanja

Drawn by:

Eng. Duale Salah

Checked by:


Sheet No.

10


Scale: N/A

Date: June, 2018


ARCHITECTURAL DRAWINGS

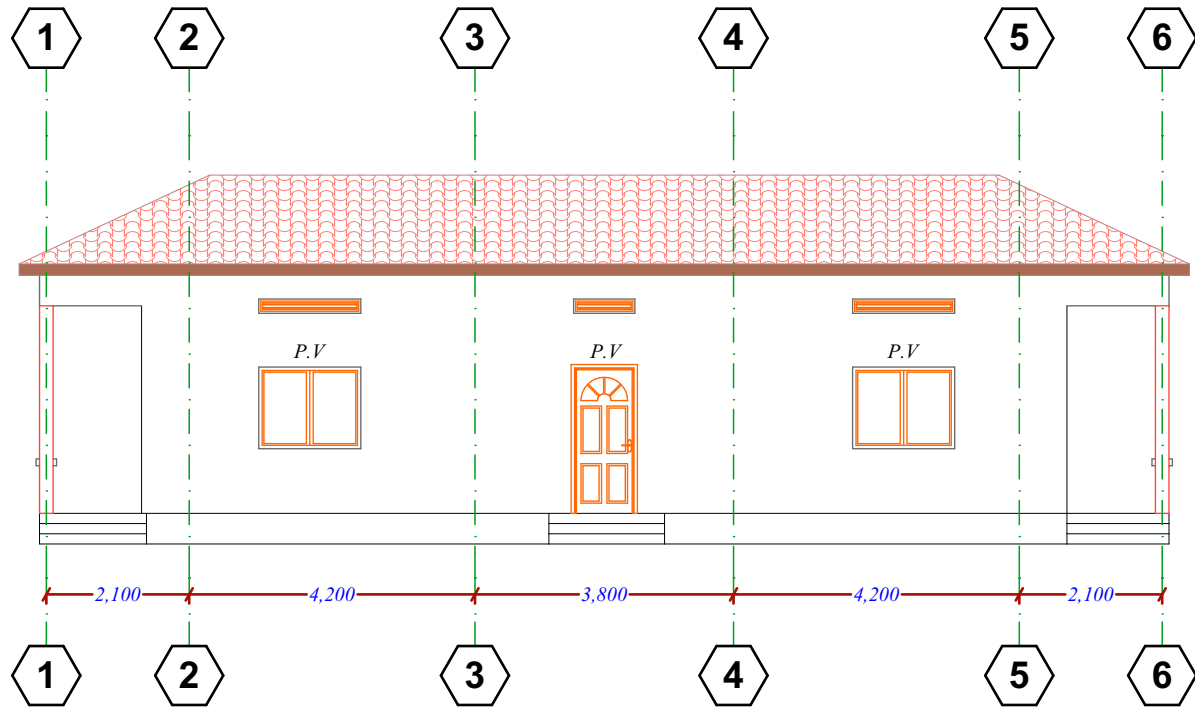


Elevation 01

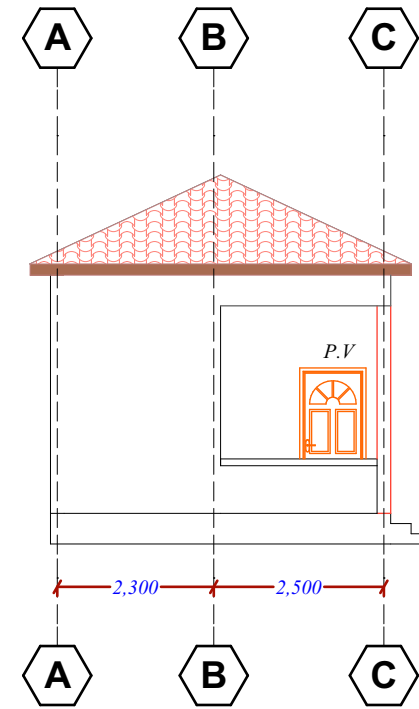


Elevation 02

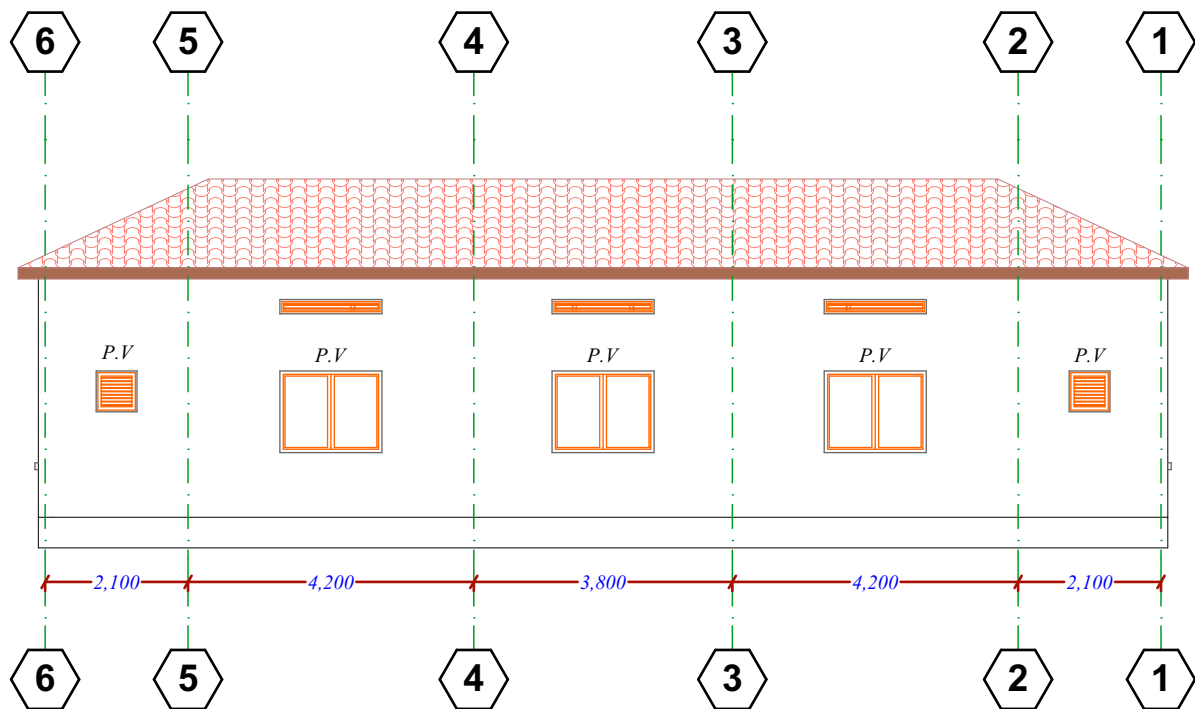

Elevation 03

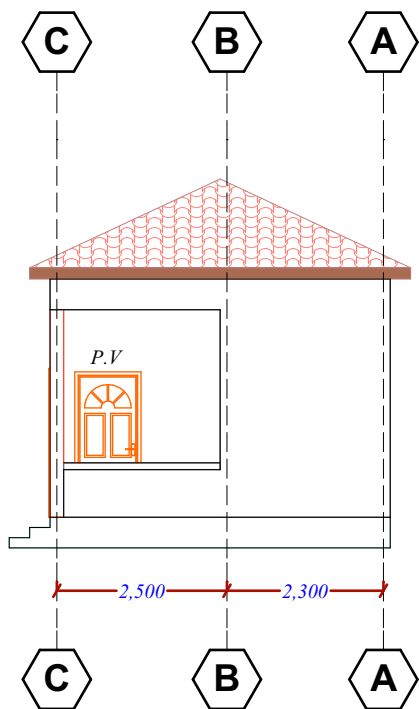

Elevation 04

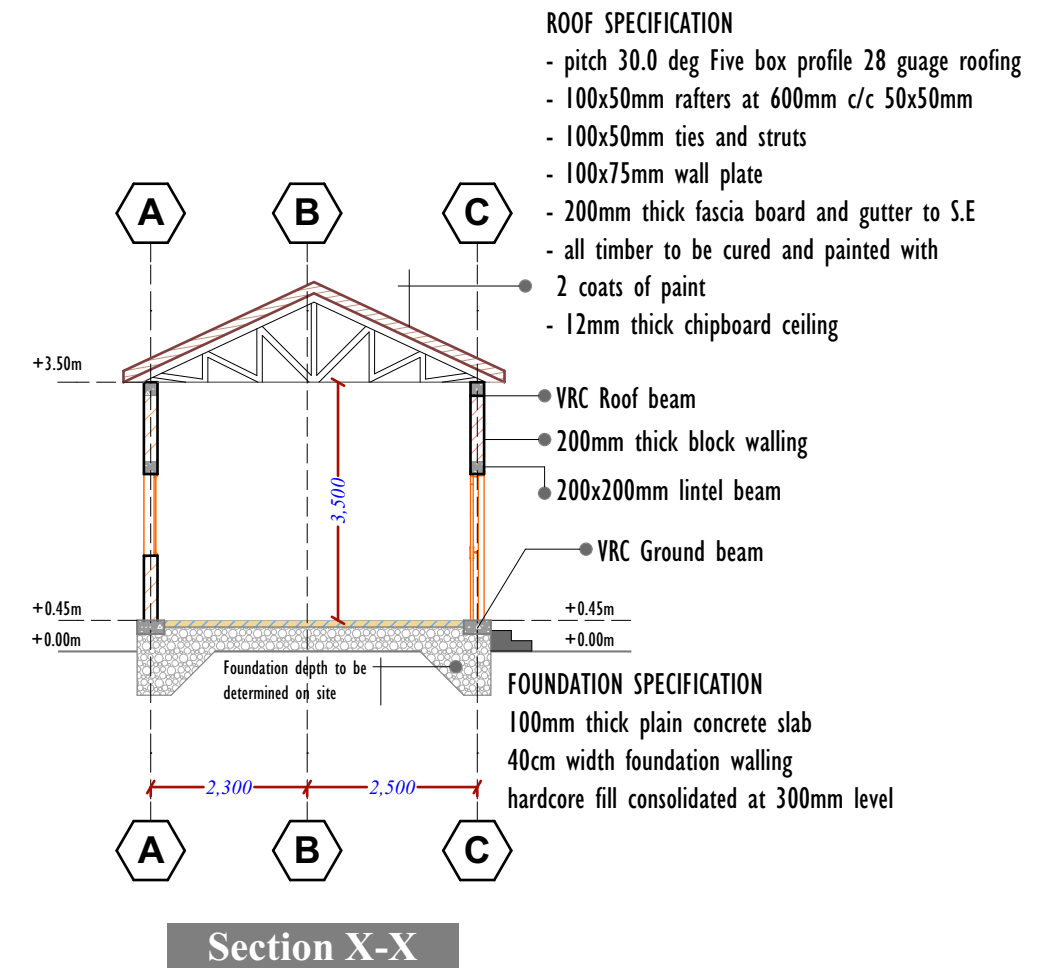

Section X-X

PROJECT DETAILS

Client:



**SOUTH WEST STATE
-SOMALIA-**

Implementation Partner:

**INTERNATIONAL ORGANIZATION
FOR MIGRATION (IOM)**

Project title:

**PROPOSED REHABILITATION OF DR. AYUUB
FOOTBALL STADIUM IN BAIDOA**

Drawing Title:

Changing Rooms- Elevations

Reviewed by:

Eng. David Wanja

Drawn by:

Eng. Duale Salah

Checked by:


Sheet No.

11

Scale: N/A


Date: June, 2018

ARCHITECTURAL DRAWINGS

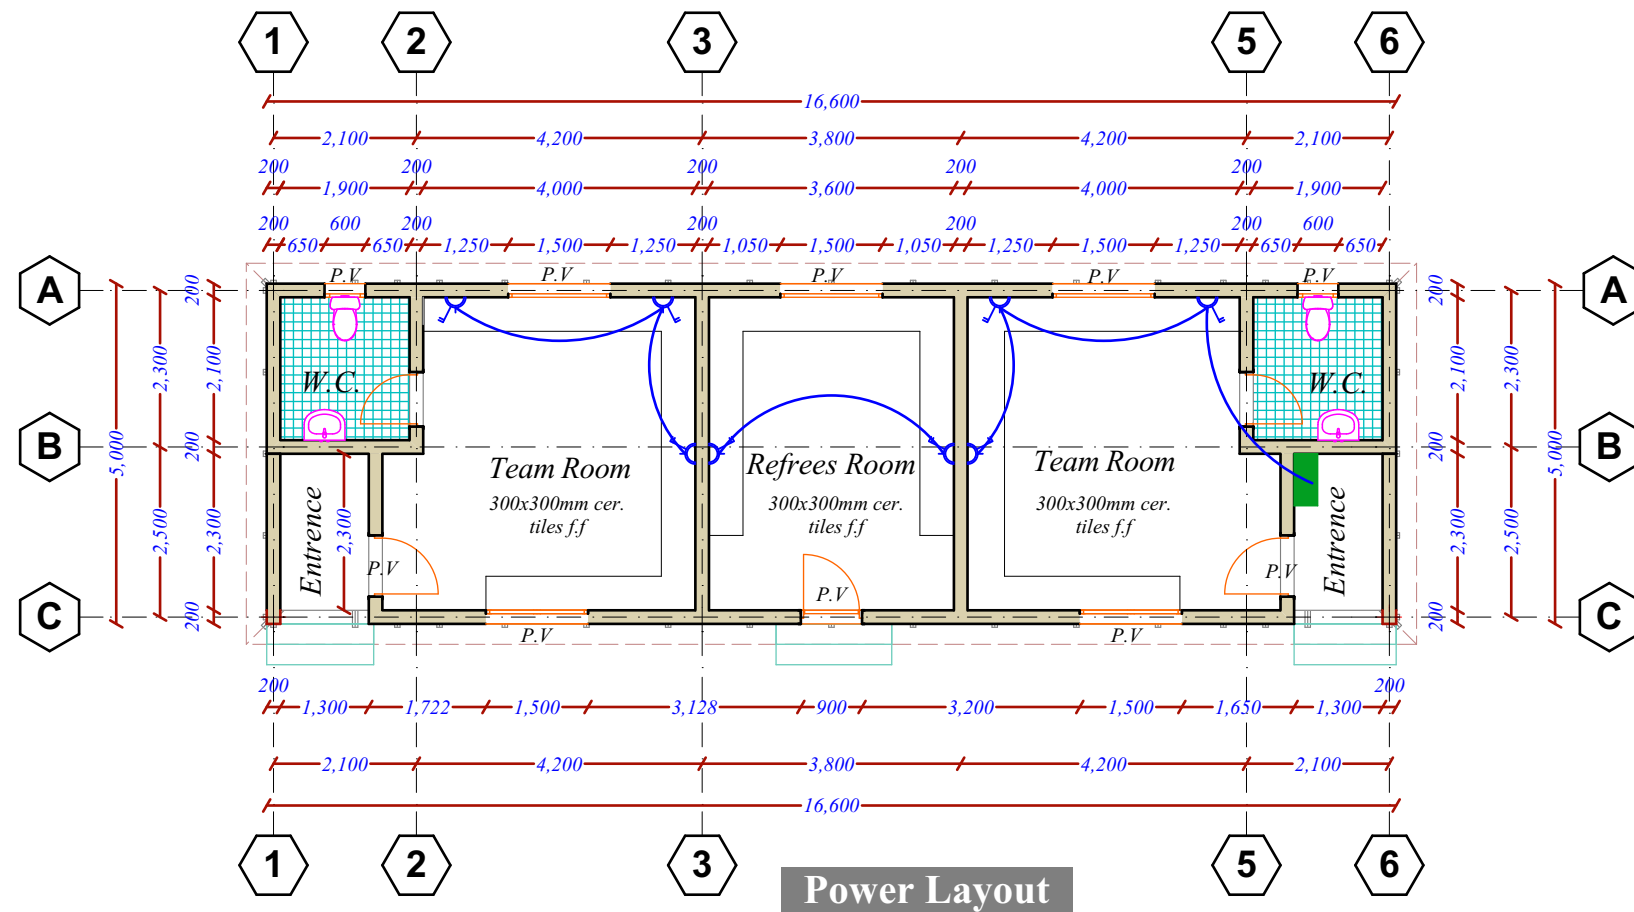

LEGEND

	4ft. Florescent Light
	CEILING MOUNTED LIGHT FIXTURE.
	1 gang 1 way switch
	2 gang 1 way switch
	Consumer unit
	Twin sockets with switches
	Lighting power circuit
	Lighting circuit
	Power circuit

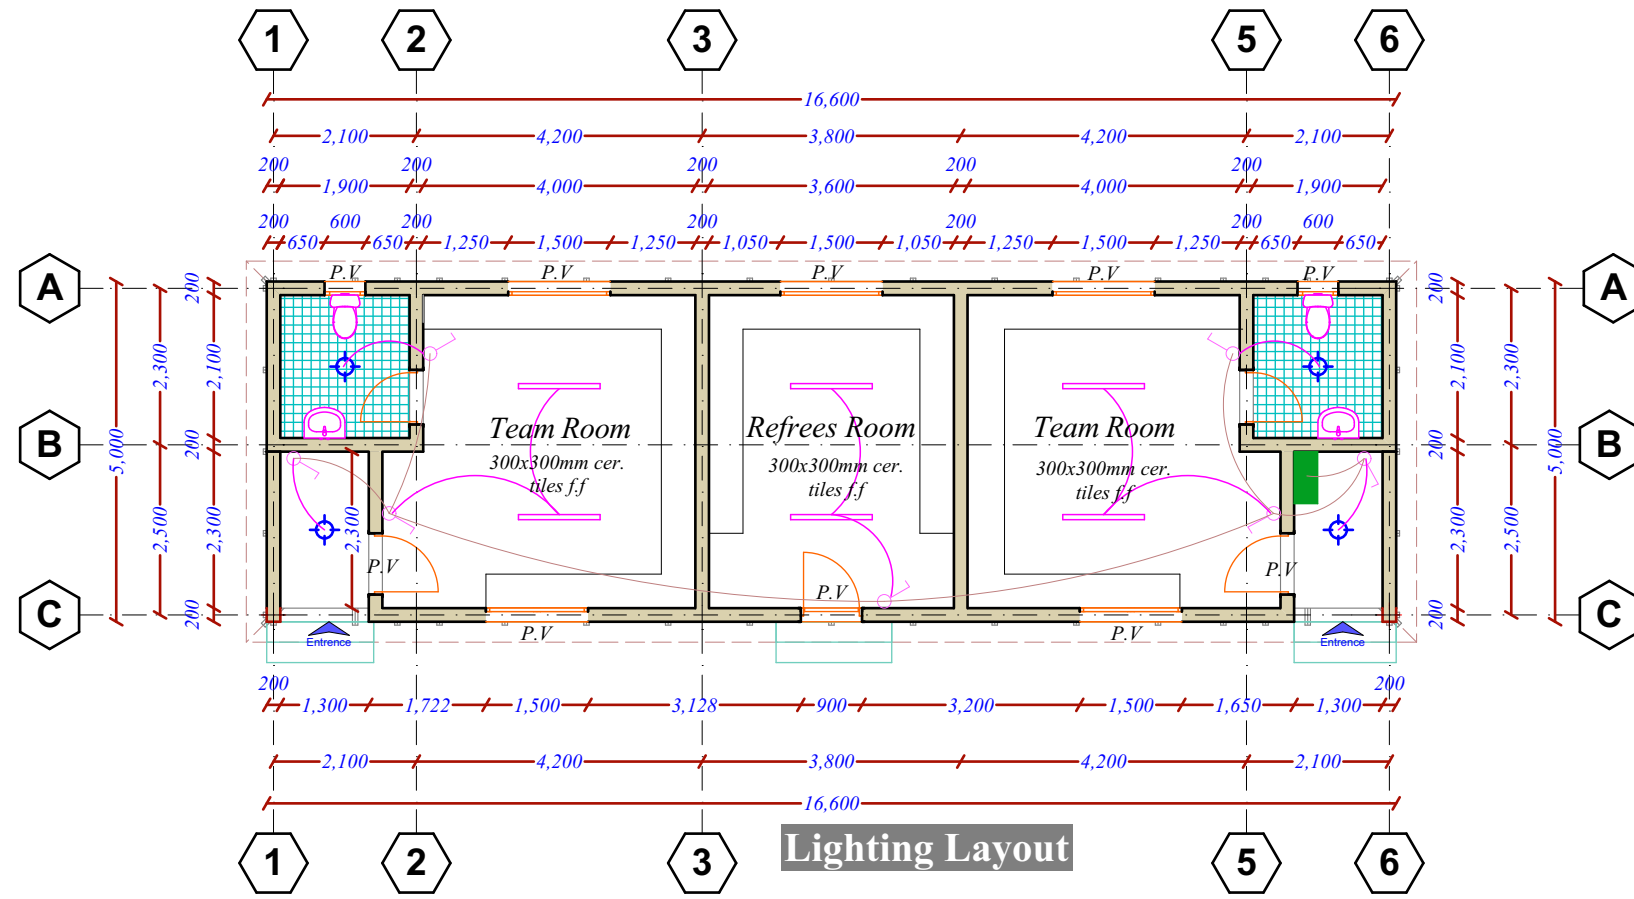

PROJECT DETAILS		
Client: SOUTH WEST STATE -SOMALIA-	Implementation Partner: INTERNATIONAL ORGANIZATION FOR MIGRATION (IOM)	Project title: PROPOSED REHABILITATION OF DR. AYUUB FOOTBALL STADIUM IN BAIDOA

Drawing Title: Changing rooms- Electrical		Reviewed by: Eng. David Wanja	
Drawn by: Eng. Duale Salah	Checked by:	Sheet No. 12	Scale: N/A
Date: June, 2018		ARCHITECTURAL DRAWINGS	



PROJECT DETAILS

Client:



**SOUTH WEST STATE
-SOMALIA-**



Implementation Partner:

**INTERNATIONAL ORGANIZATION
FOR MIGRATION (IOM)**

Project title:

**PROPOSED REHABILITATION OF DR. AYUUB
FOOTBALL STADIUM IN BAIDOA**


Drawing Title:		Reviewed by:	
3D Projection		Eng. David Wanja	
Drawn by:	Checked by:	Sheet No.	Scale: N/A
Eng. Duale Salah		13	
Date:	ARCHITECTURAL DRAWINGS		
June, 2018			

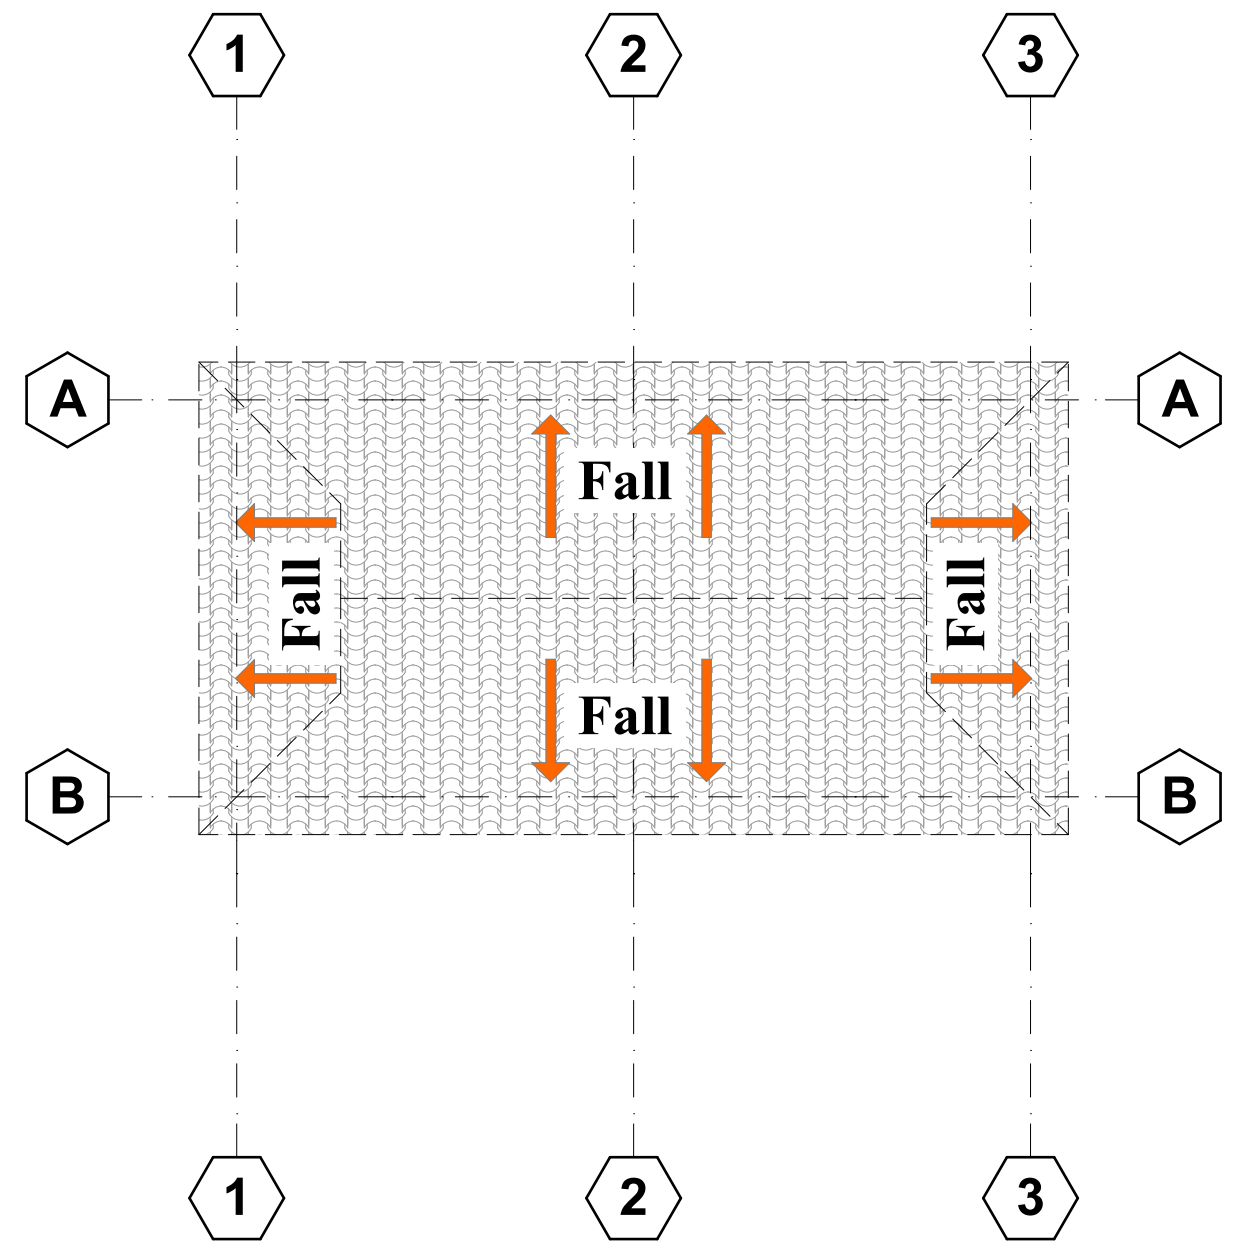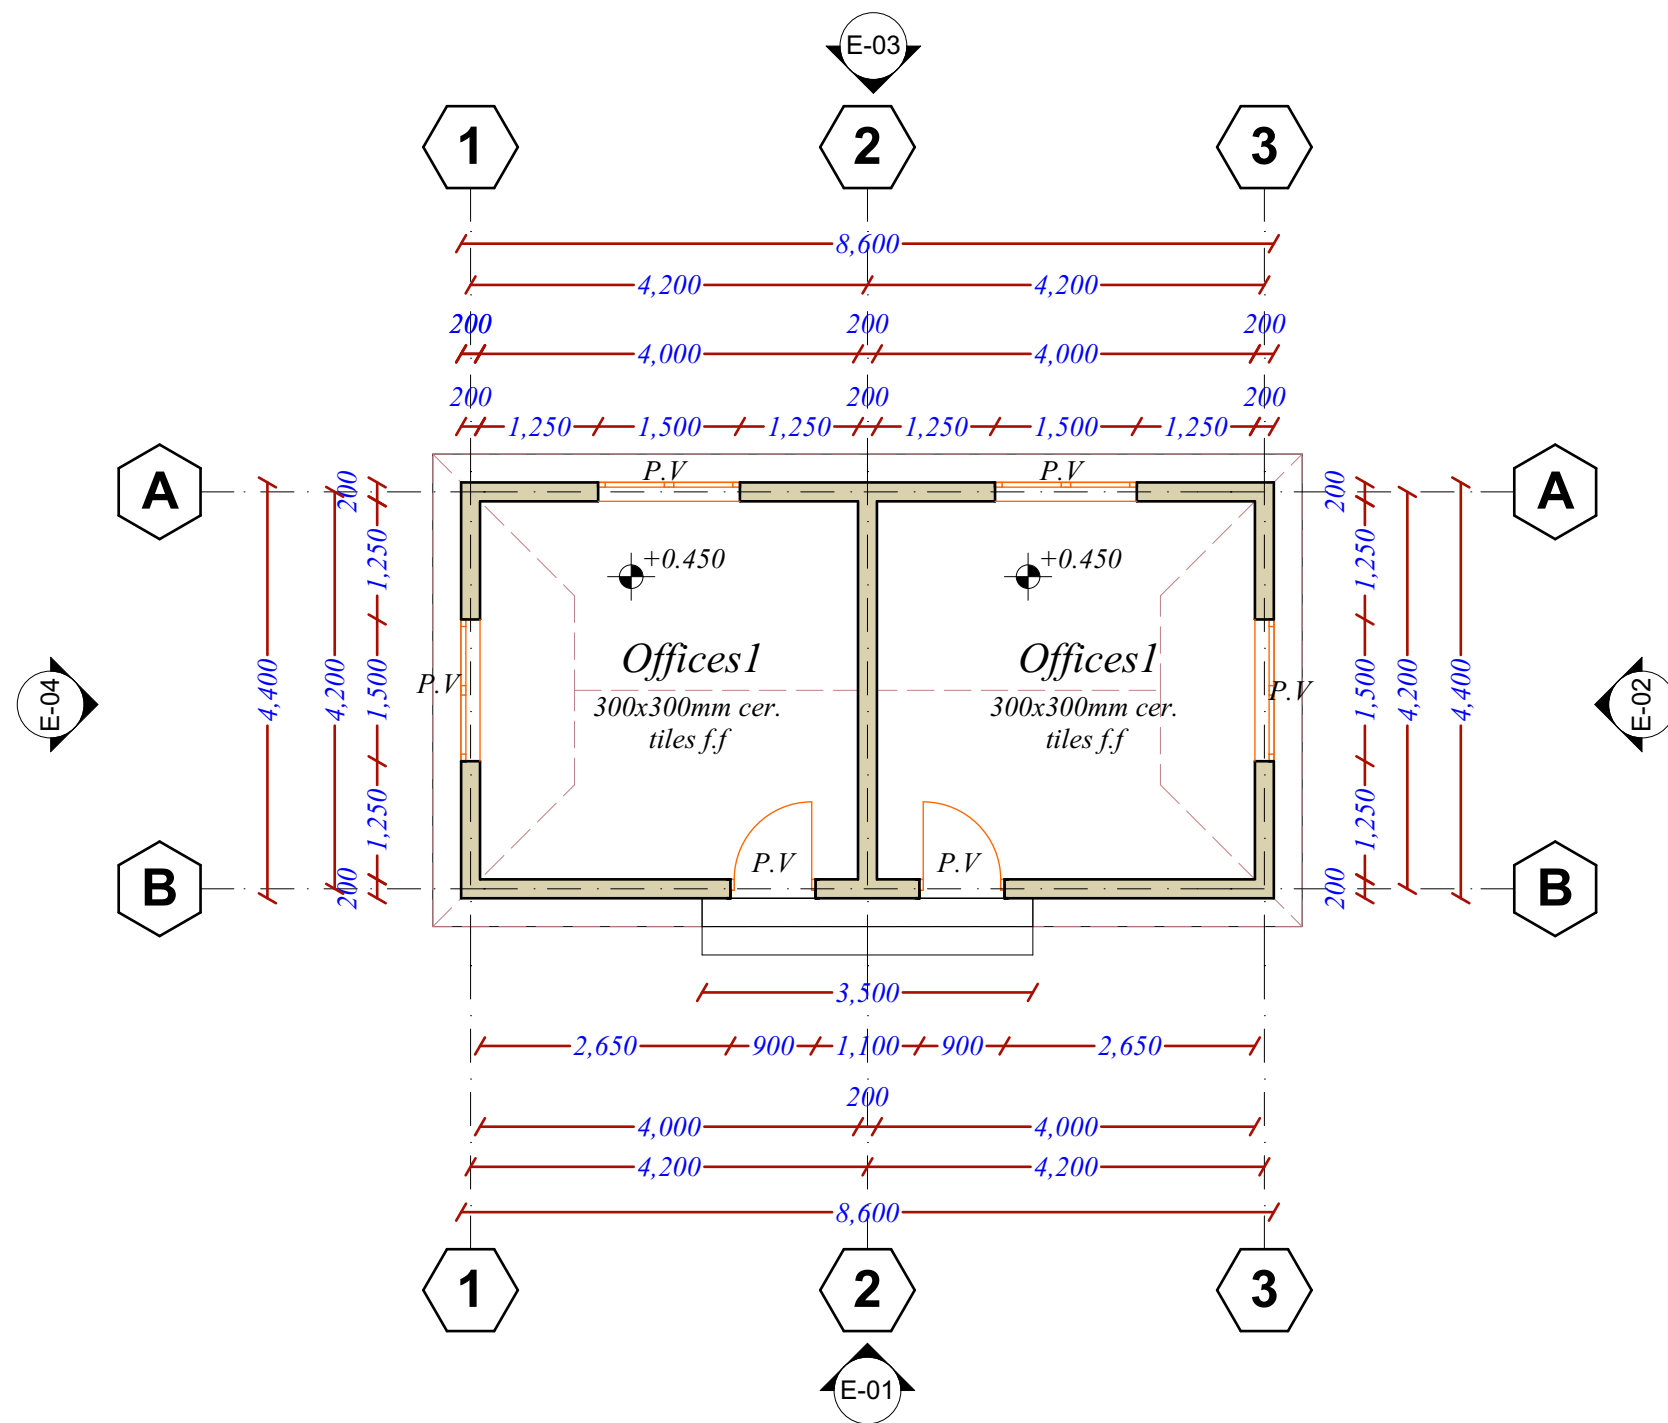


Typical Floor Plan

Roof Plan


PROJECT DETAILS			Drawing Title:		Reviewed by:	
Client:	Implementation Partner:	Project title:	Offices- Floor layout		Eng. David Wanja	
 SOUTH WEST STATE -SOMALIA-	INTERNATIONAL ORGANIZATION FOR MIGRATION (IOM)	PROPOSED REHABILITATION OF DR. AYUUB FOOTBALL STADIUM IN BAIDOA	Drawn by:	Checked by:	Sheet No.	Scale: N/A
			Eng. Duale Salah		14	
Date: June, 2018			ARCHITECTURAL DRAWINGS			

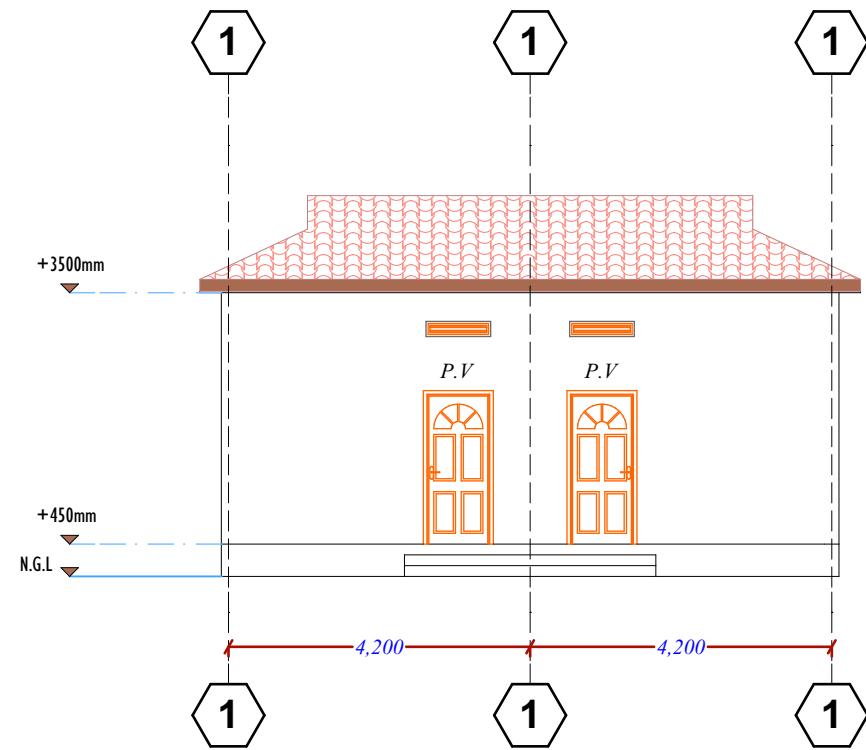


Elevation -01

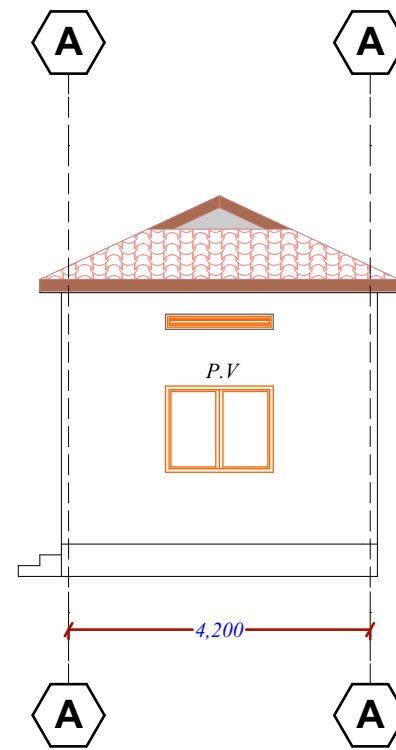

Elevation -02

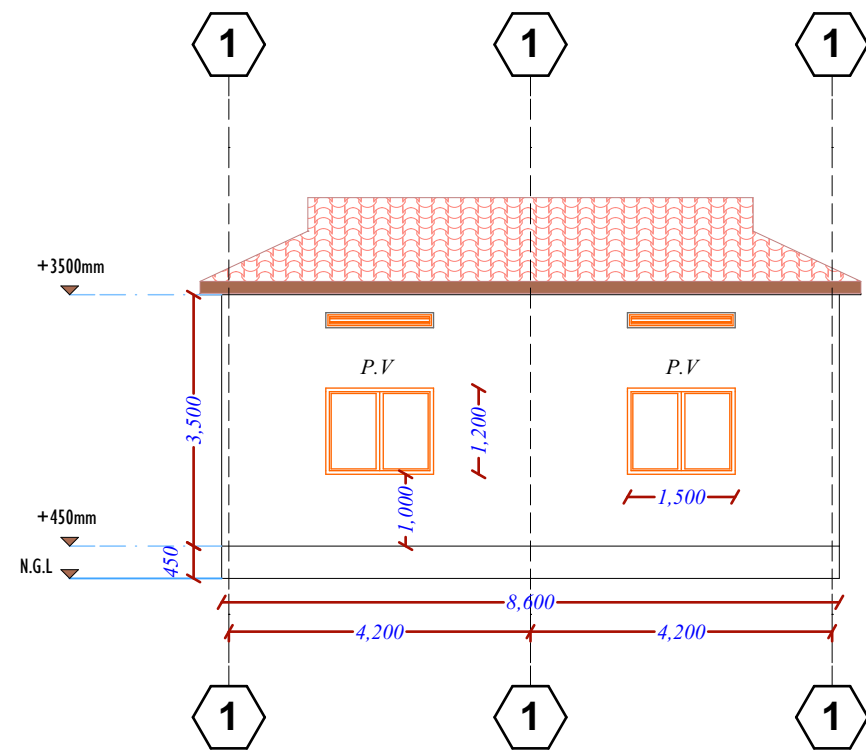

Elevation -03

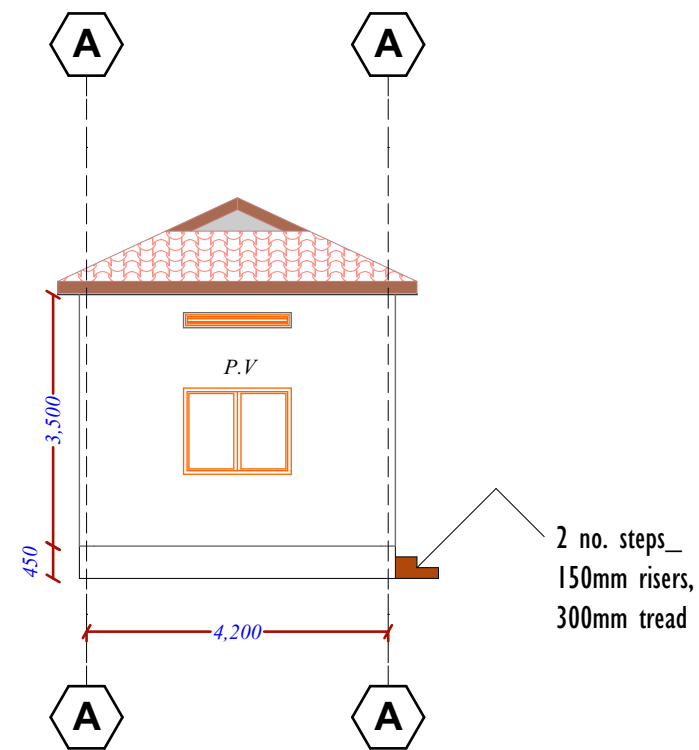

Elevation -04

PROJECT DETAILS

Client:



**SOUTH WEST STATE
-SOMALIA-**

Implementation Partner:

**INTERNATIONAL ORGANIZATION
FOR MIGRATION (IOM)**

Project title:

**PROPOSED REHABILITATION OF DR. AYUUB
FOOTBALL STADIUM IN BAIDOA**

Drawing Title:

Offices- Elevations

Reviewed by:

Eng. David Wanja

Drawn by:

Eng. Duale Salah

Checked by:



Sheet No.

15

Scale: N/A

Date: June, 2018

ARCHITECTURAL DRAWINGS

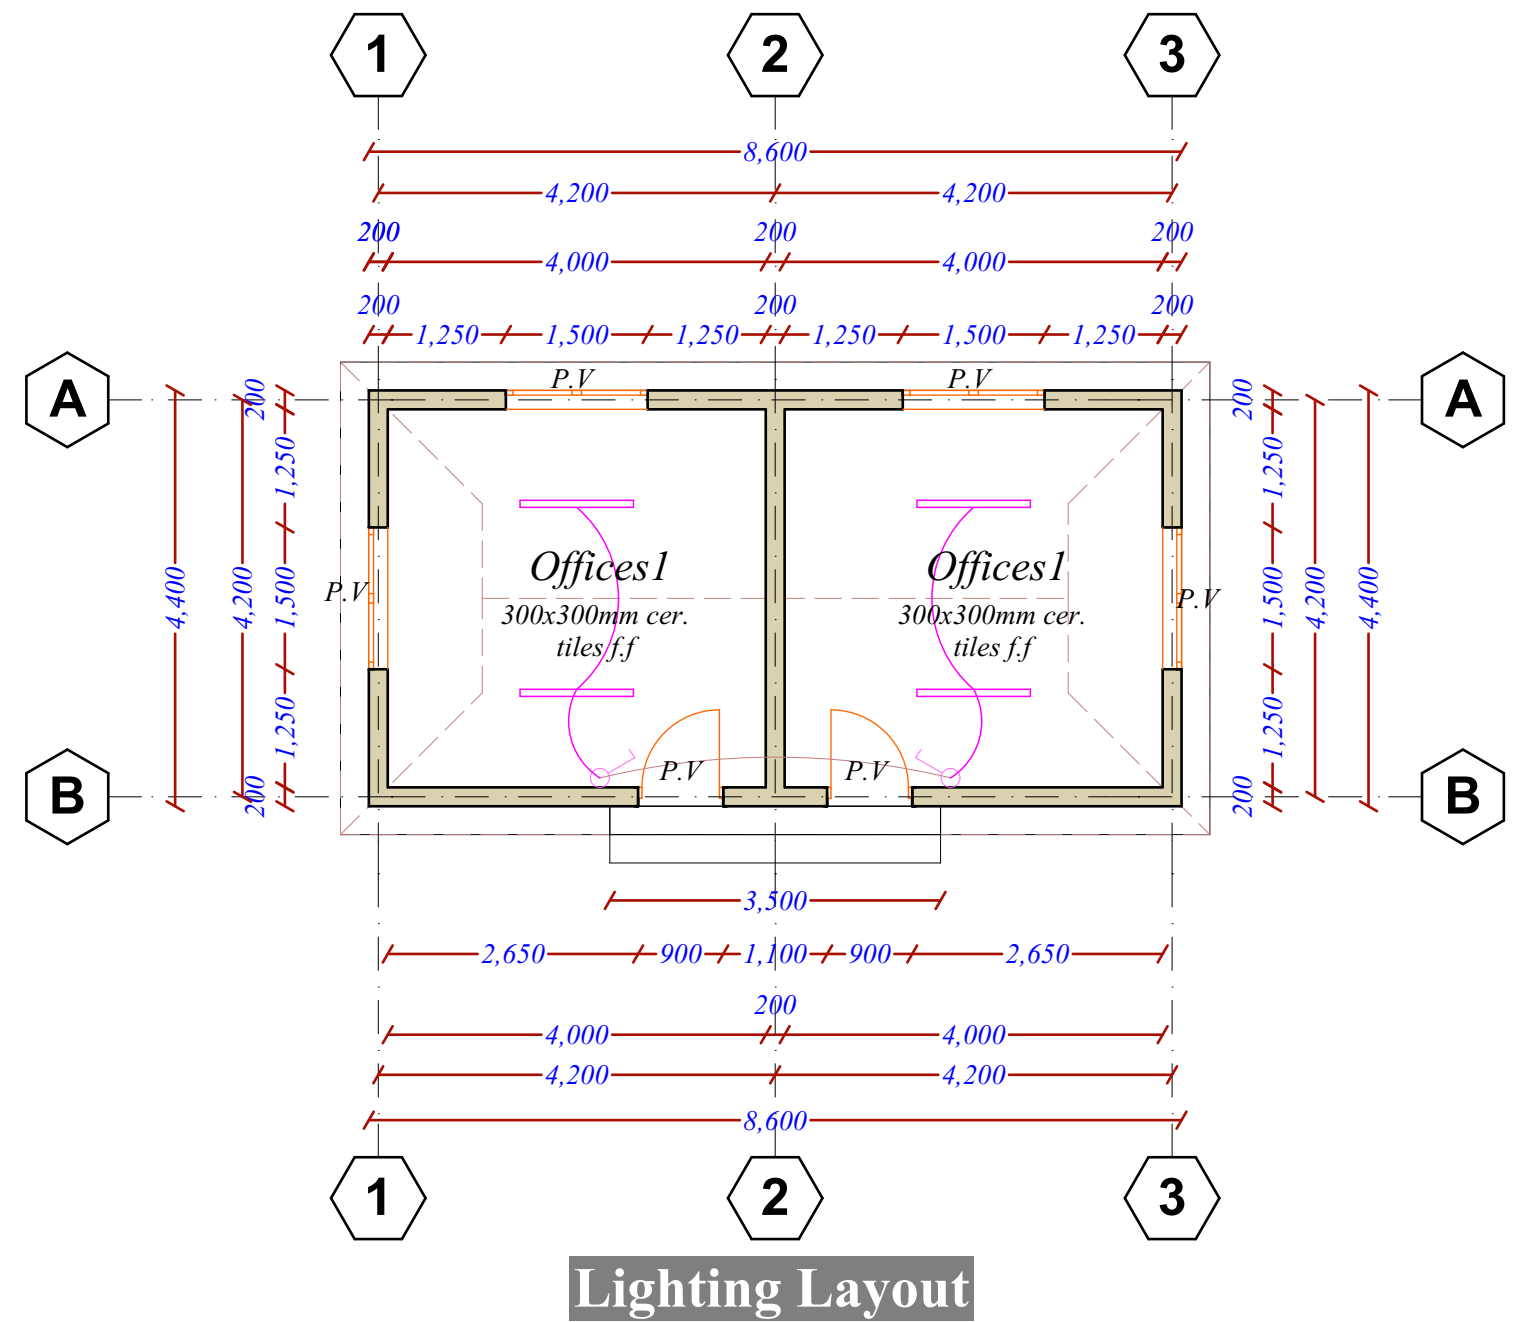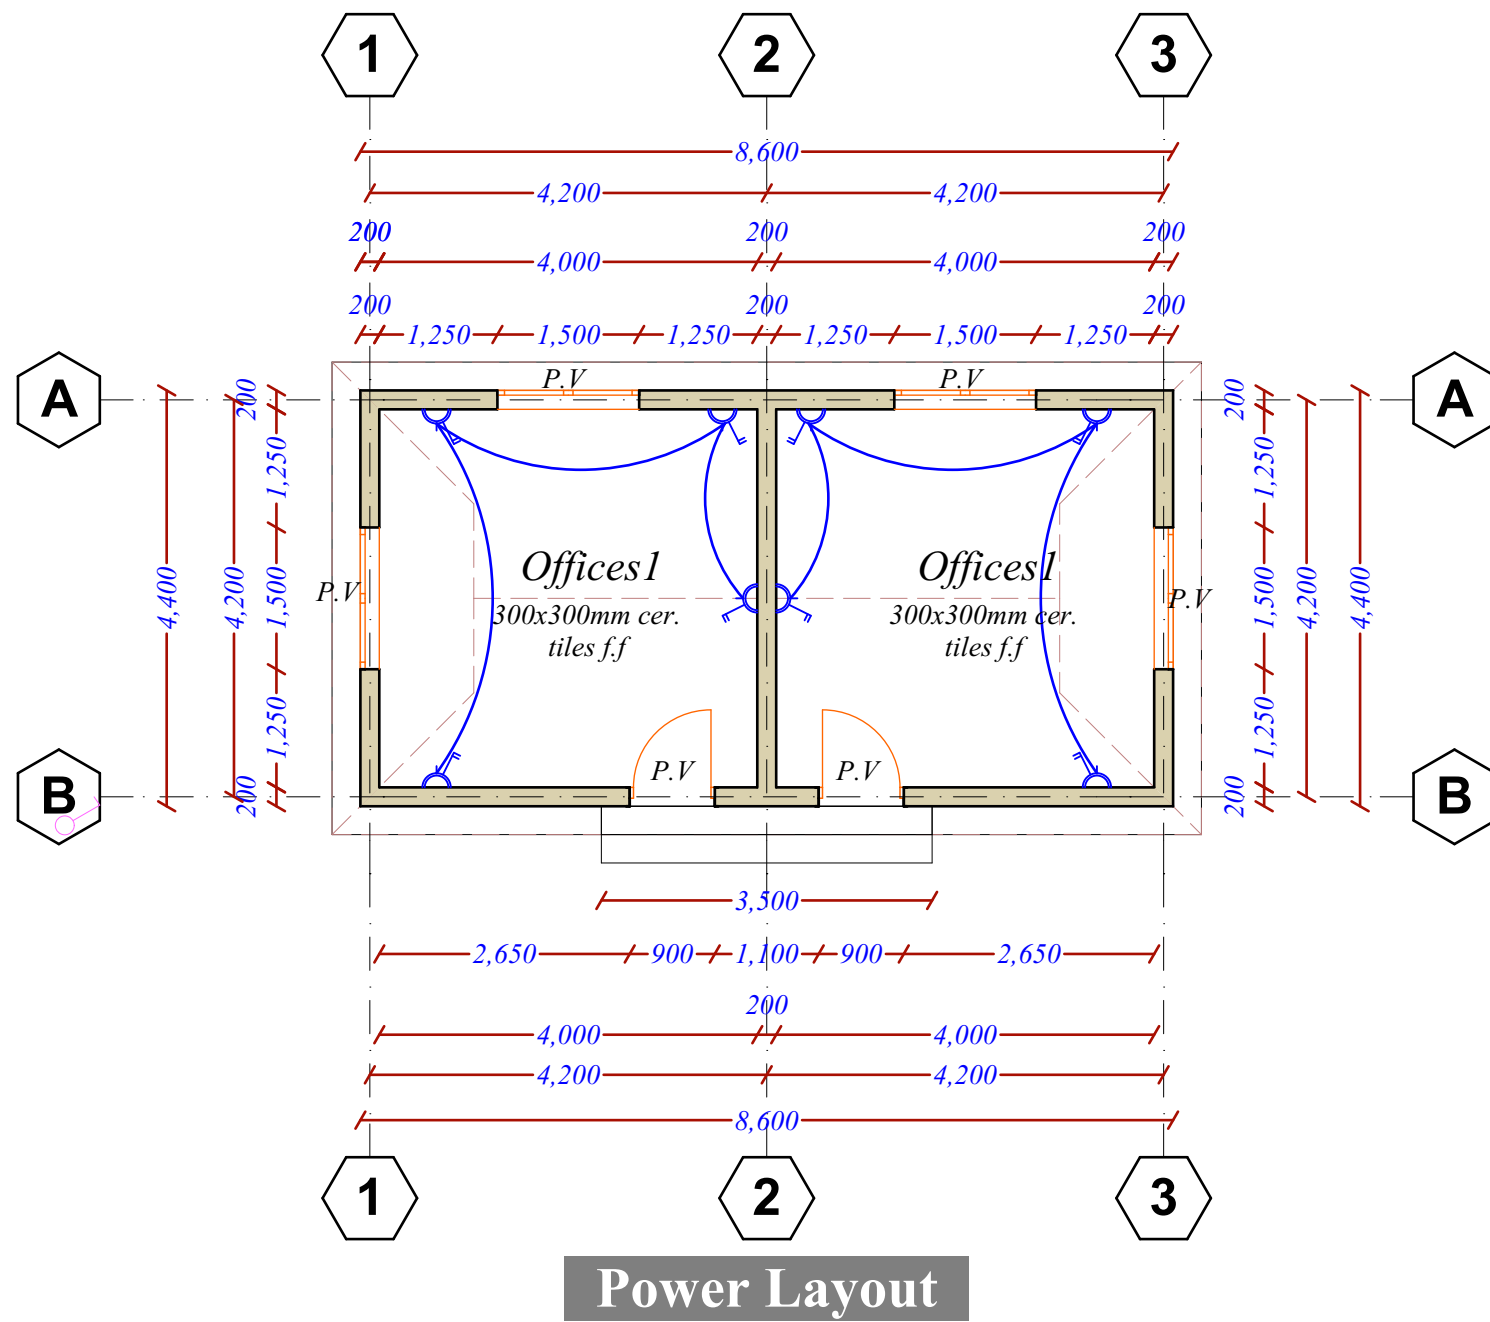

PROJECT DETAILS

Client:

Implementation Partner:

Project title:



**SOUTH WEST STATE
-SOMALIA-**

**INTERNATIONAL ORGANIZATION
FOR MIGRATION (IOM)**

**PROPOSED REHABILITATION OF DR. AYUUB
FOOTBALL STADIUM IN BAIDOA**

Drawing Title: Offices- Electrical layout		Reviewed by: Eng. David Wanja	
Drawn by: Eng. Duale Salah	Checked by:	Sheet No. 16	Scale: N/A
Date: June, 2018	ARCHITECTURAL DRAWINGS		



PROJECT DETAILS

Client:



**SOUTH WEST STATE
-SOMALIA-**

Implementation Partner:

**INTERNATIONAL ORGANIZATION
FOR MIGRATION (IOM)**

Project title:

**PROPOSED REHABILITATION OF DR. AYUUB
FOOTBALL STADIUM IN BAIDOA**

Drawing Title:

Offices- 3D Projection

Reviewed by:

Eng. David Wanja

Drawn by:

Eng. Duale Salah

Checked by:







Sheet No.

17

Scale: N/A

Date: June, 2018

ARCHITECTURAL DRAWINGS

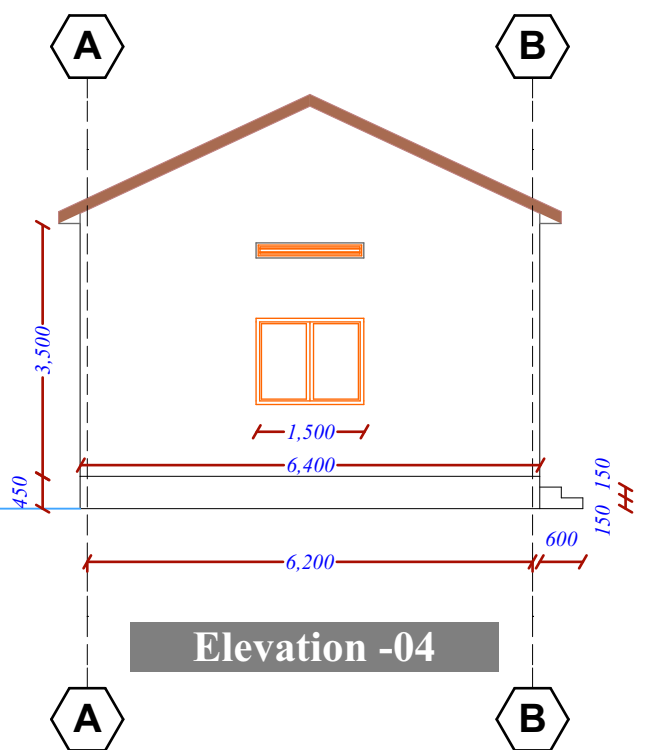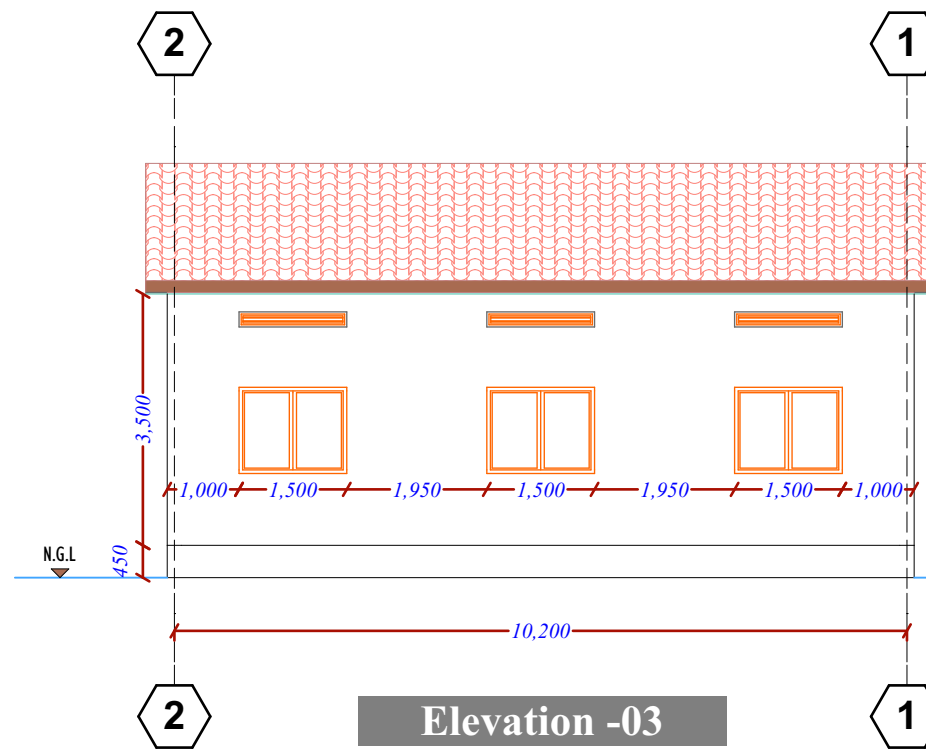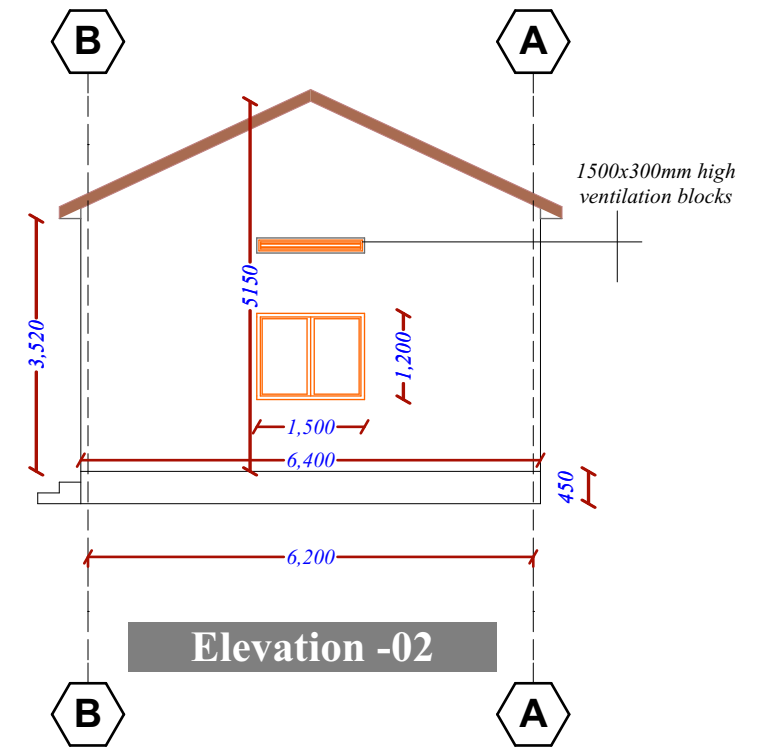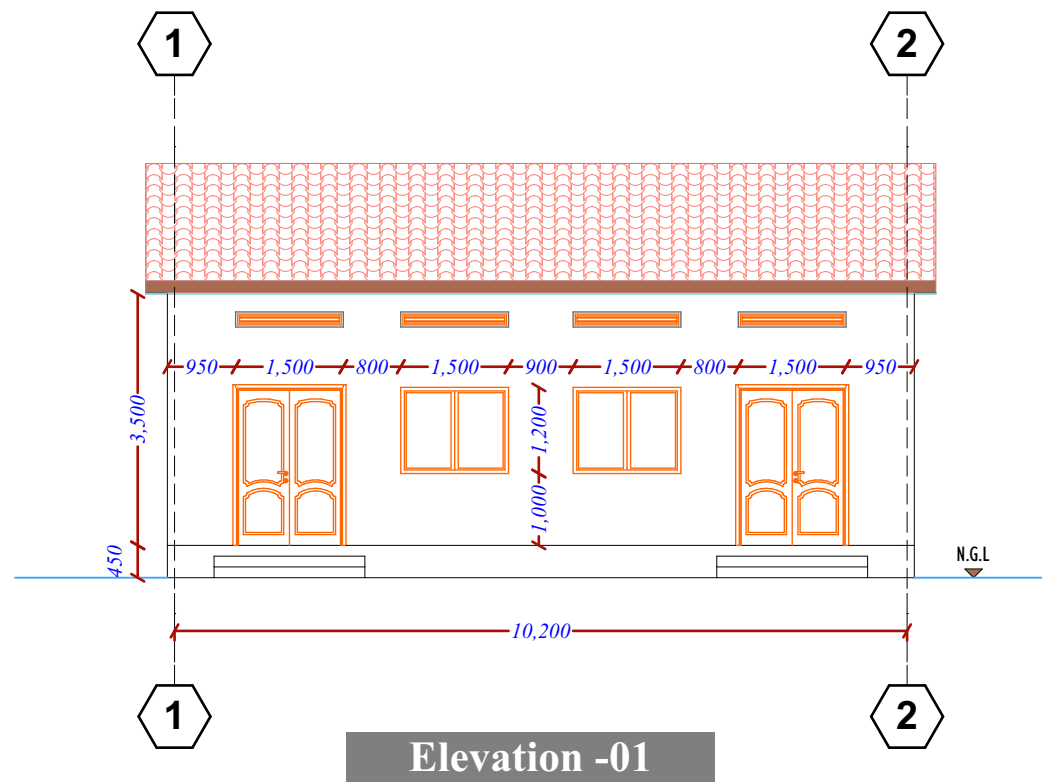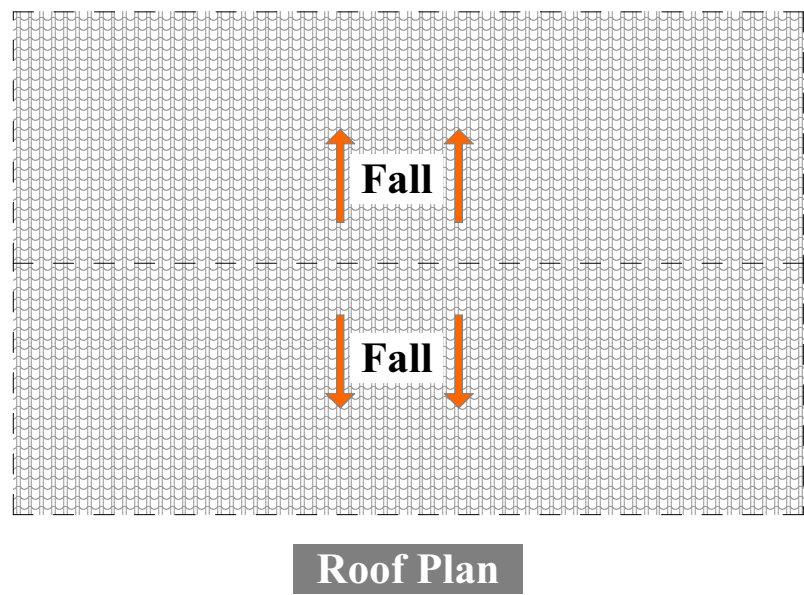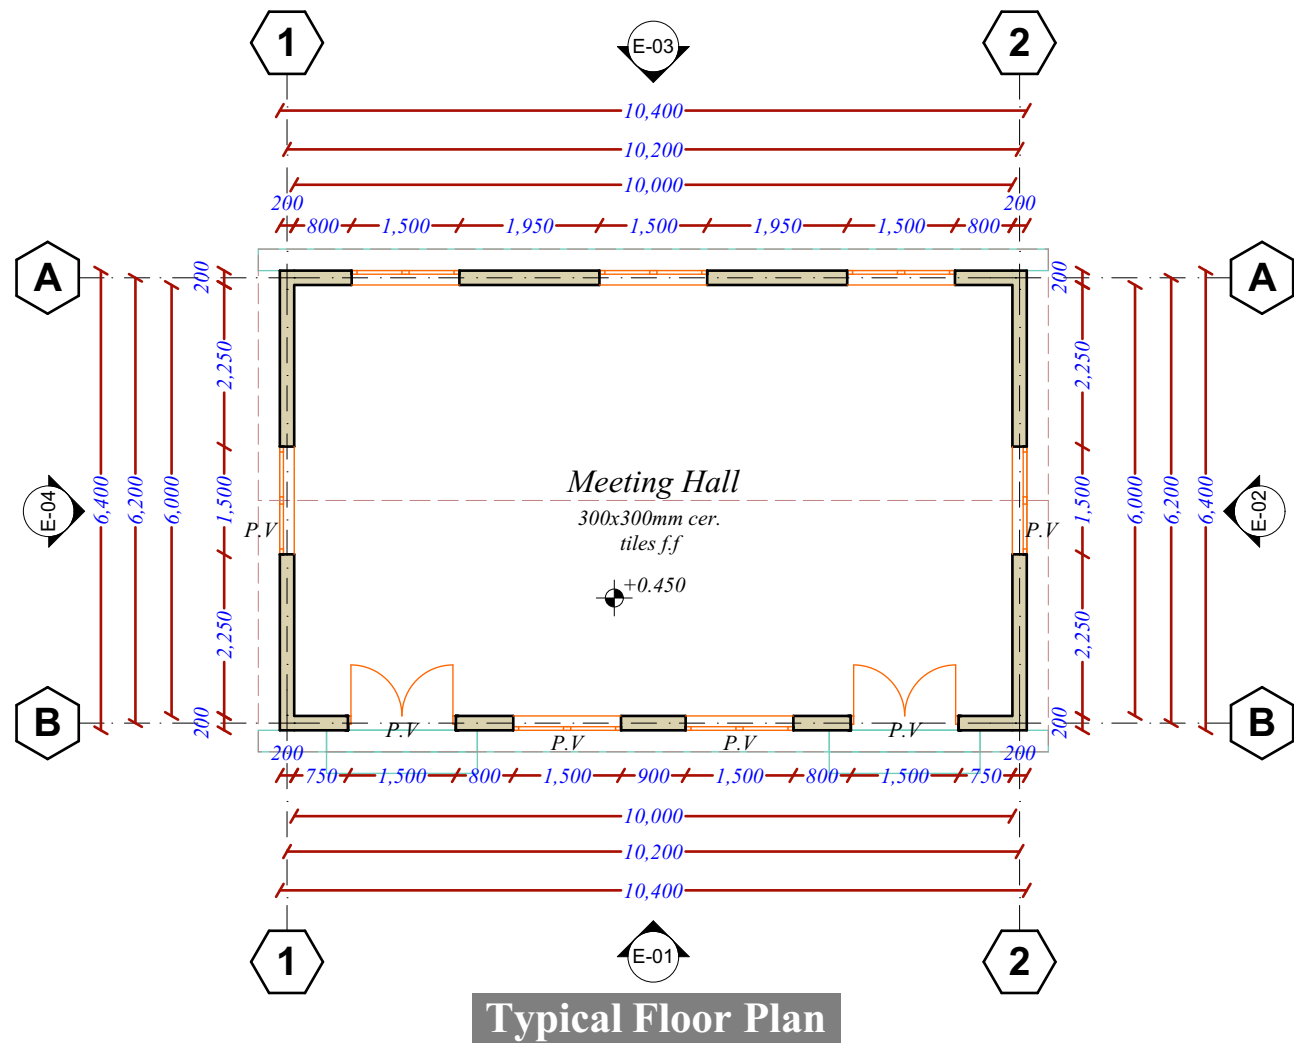

PROJECT DETAILS

Client:



**SOUTH WEST STATE
-SOMALIA-**

Implementation Partner:

**INTERNATIONAL ORGANIZATION
FOR MIGRATION (IOM)**

Project title:

**PROPOSED REHABILITATION OF DR. AYUUB
FOOTBALL STADIUM IN BAIDOA**

Drawing Title: Meeting Hall detail		Reviewed by: Eng. David Wanja	
Drawn by: Eng. Duale Salah	Checked by:	Sheet No. 18	Scale: N/A
Date: June, 2018	ARCHITECTURAL DRAWINGS		



PROJECT DETAILS

Client:



**SOUTH WEST STATE
-SOMALIA-**


Implementation Partner:

**INTERNATIONAL ORGANIZATION
FOR MIGRATION (IOM)**

Project title:

**PROPOSED REHABILITATION OF DR. AYUUB
FOOTBALL STADIUM IN BAIDOA**


Drawing Title:		Reviewed by:	
Meeting hall- 3D Projection		Eng. David Wanja	
Drawn by:	Checked by:	Sheet No.	Scale: N/A
Eng. Duale Salah		19	
Date:	ARCHITECTURAL DRAWINGS		
June, 2018			

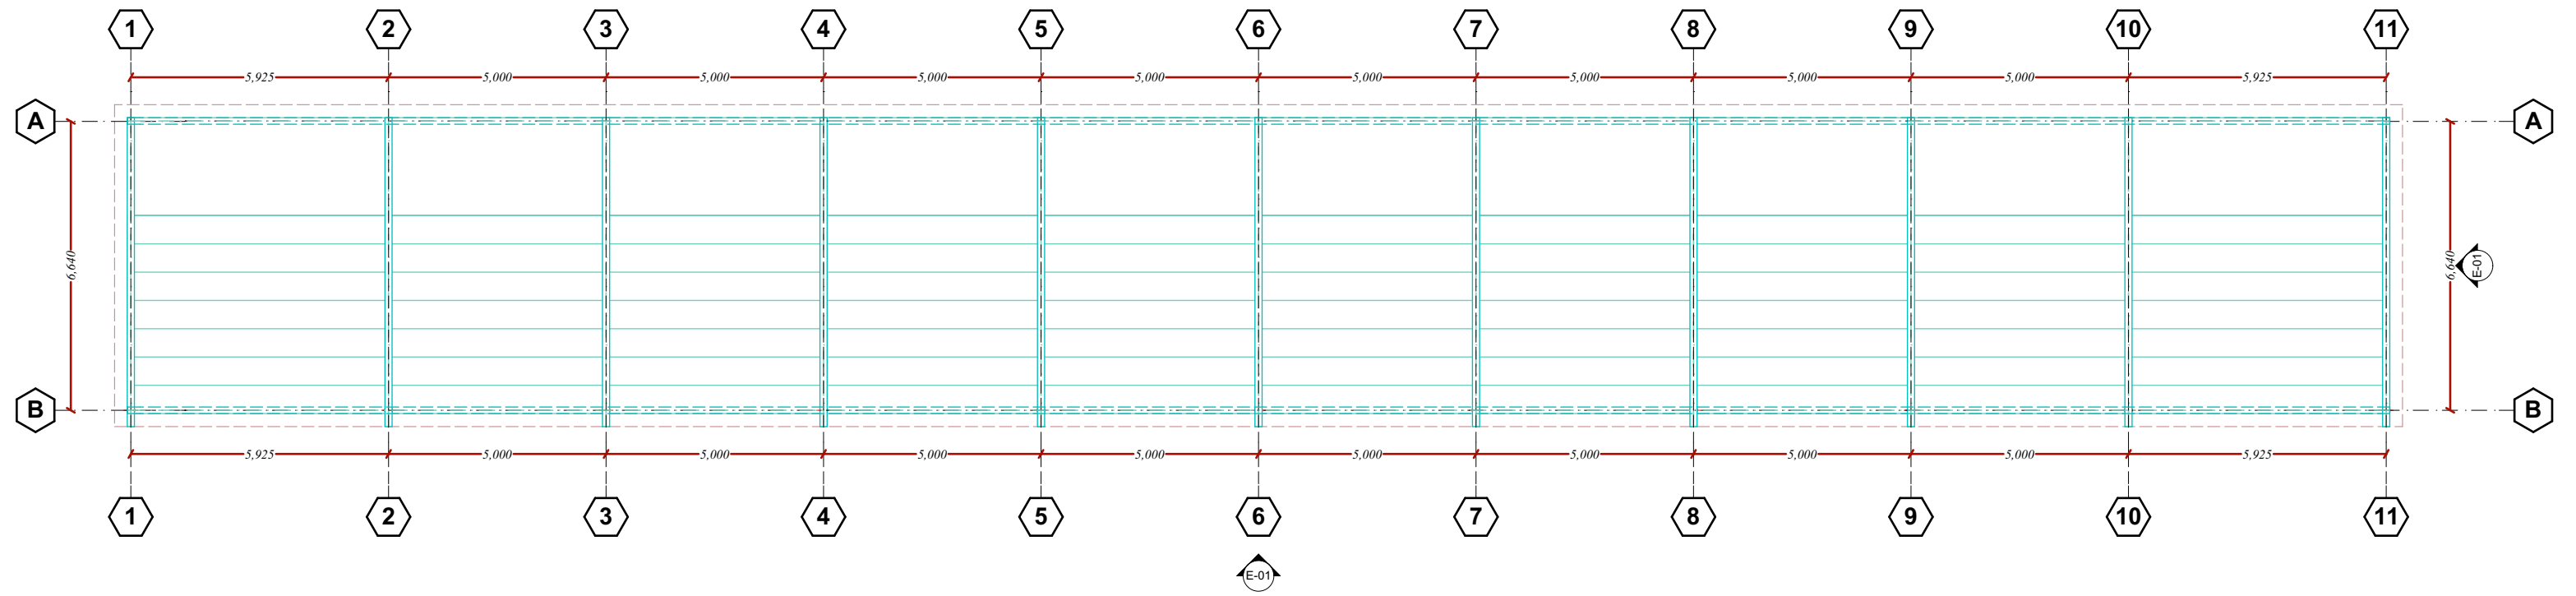

Existing Spectator layout plan



Existing Spectator Front Elevation

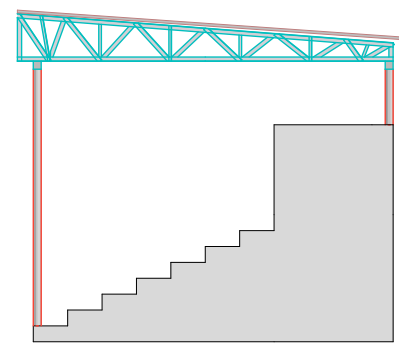

Side Elevation

PROJECT DETAILS

Client:



**SOUTH WEST STATE
-SOMALIA-**

Implementation Partner:

**INTERNATIONAL ORGANIZATION
FOR MIGRATION (IOM)**

Project title:

**PROPOSED REHABILITATION OF DR. AYUUB
FOOTBALL STADIUM IN BAIDOA**

Drawing Title:

Spectators stand detail

Reviewed by:

Eng. David Wanja

Drawn by:

Eng. Duale Salah

Checked by:


Sheet No.

20

Scale: N/A

Date: June, 2018

ARCHITECTURAL DRAWINGS

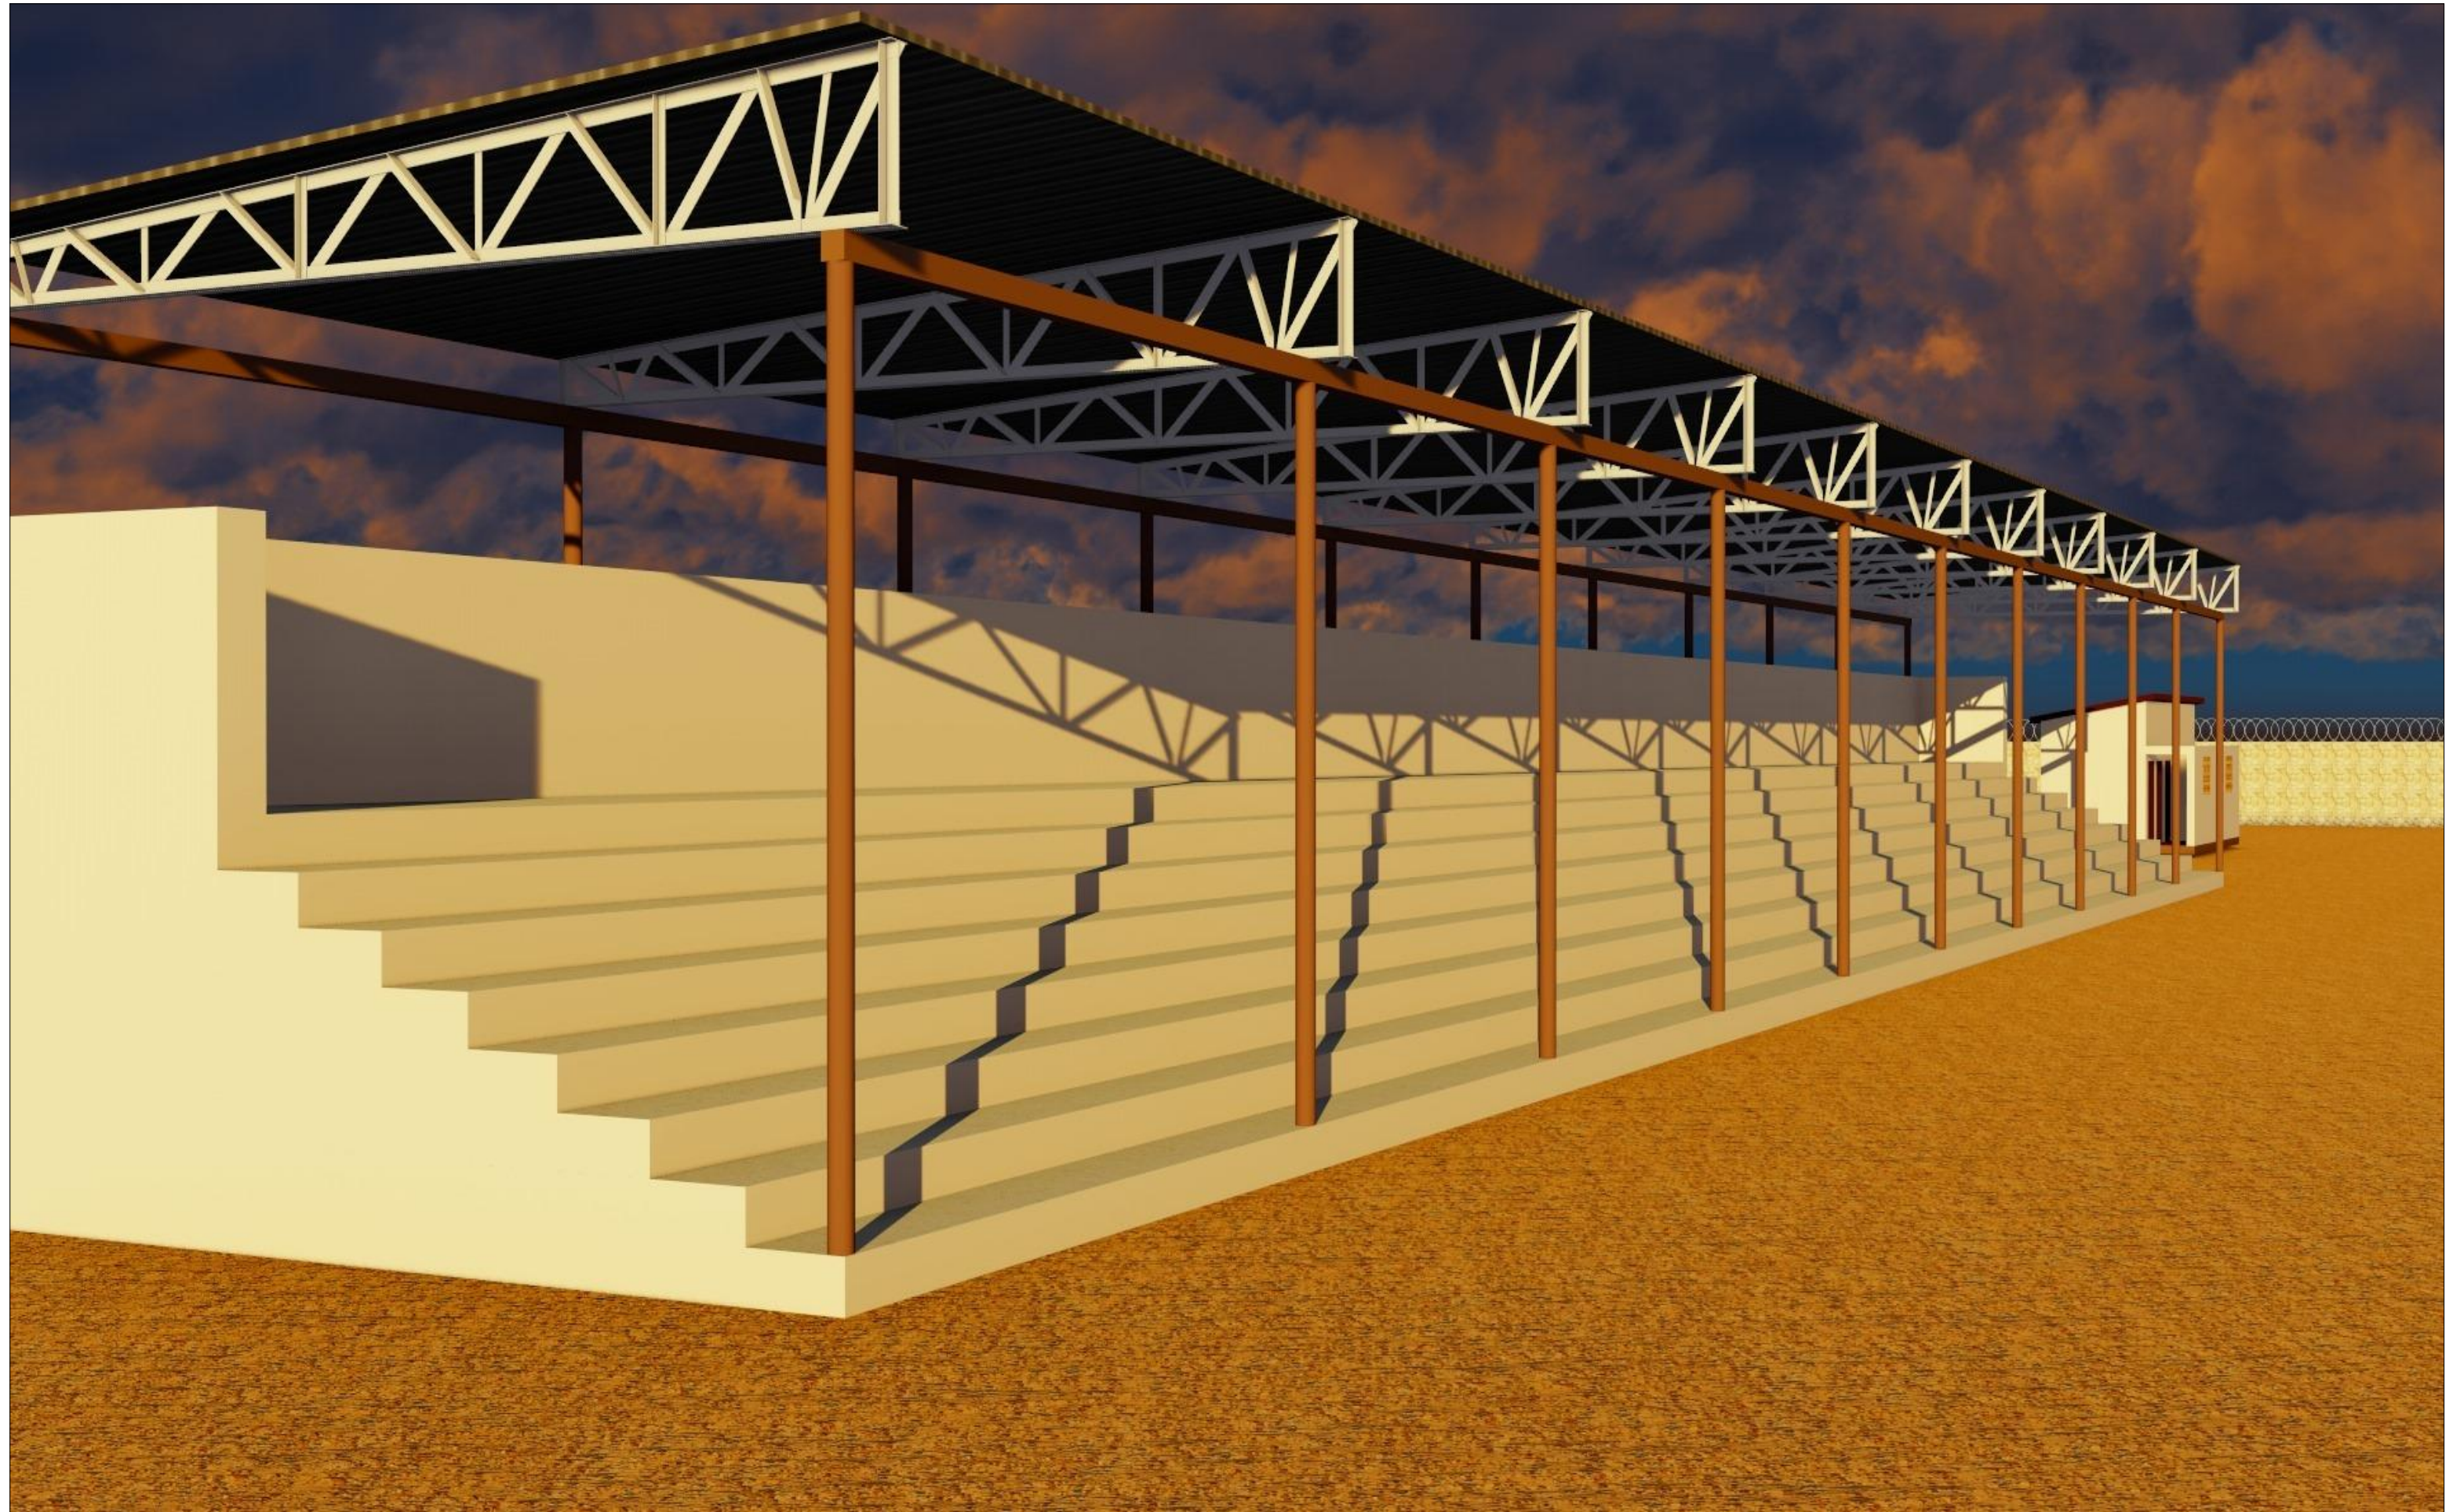

PROJECT DETAILS

Client:



**SOUTH WEST STATE
-SOMALIA-**

Implementation Partner:

**INTERNATIONAL ORGANIZATION
FOR MIGRATION (IOM)**

Project title:

**PROPOSED REHABILITATION OF DR. AYUUB
FOOTBALL STADIUM IN BAIDOA**

Drawing Title:

Spectators stand- 3D Projection

Reviewed by:

Eng. David Wanja

Drawn by:

Eng. Duale Salah

Checked by:


Sheet No.

21


Scale: N/A

Date: June, 2018


ARCHITECTURAL DRAWINGS

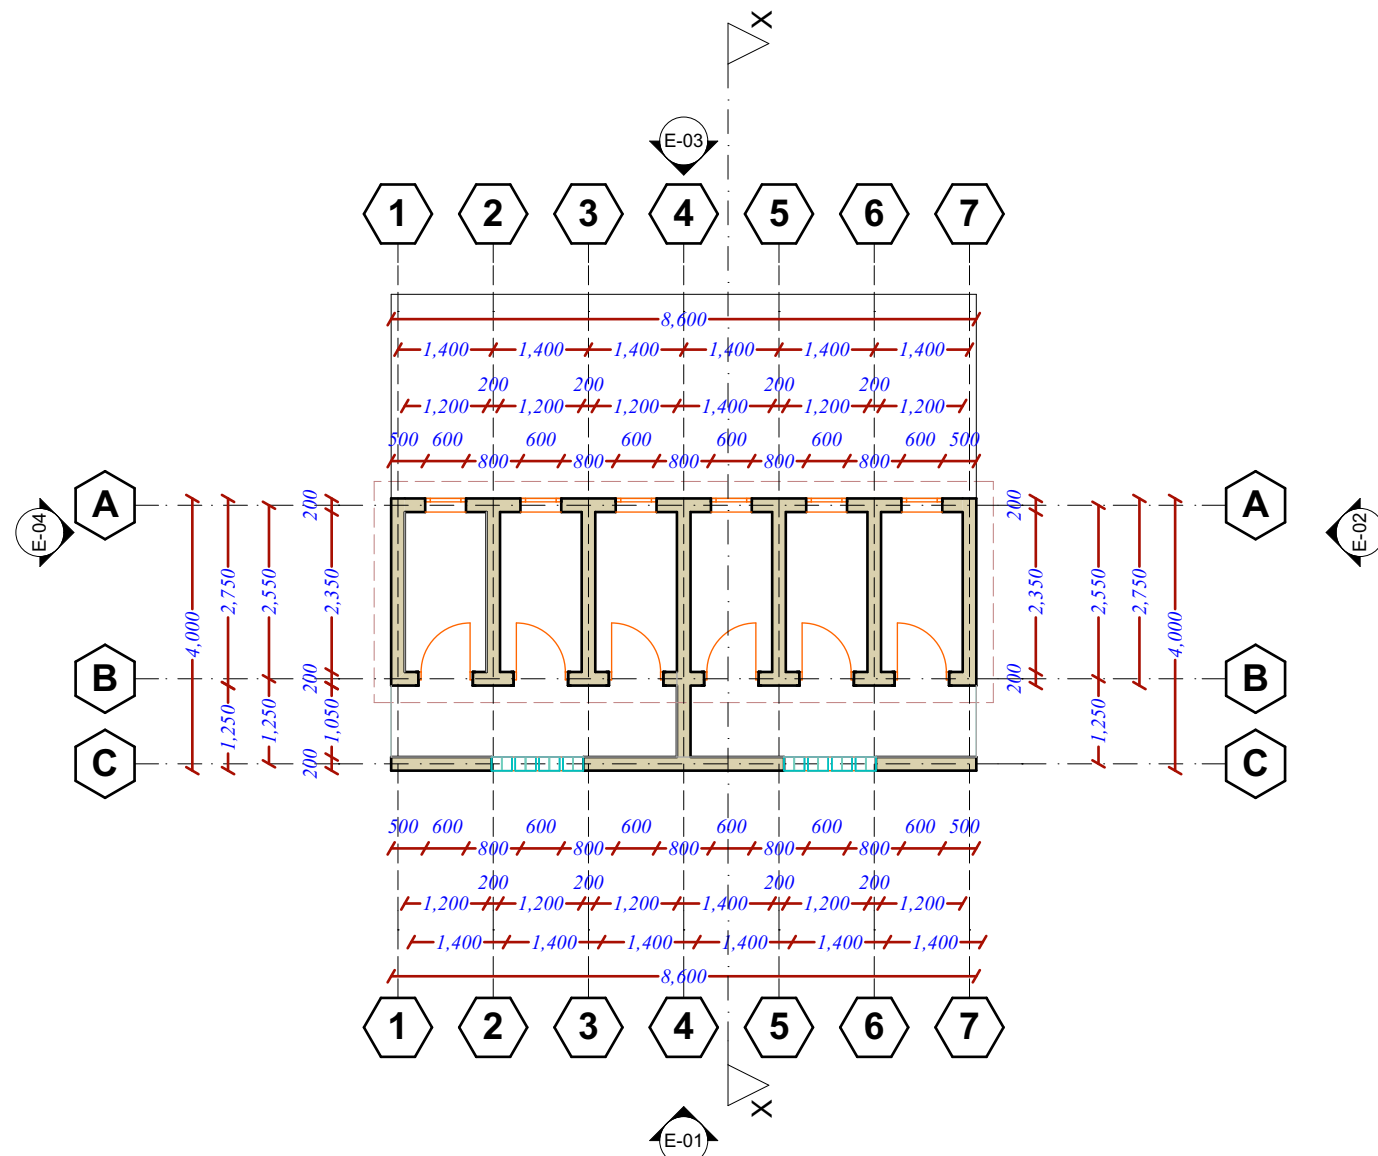


Typical Floor Plan

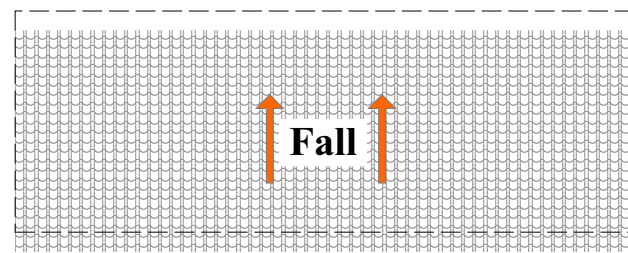

Roof Plan

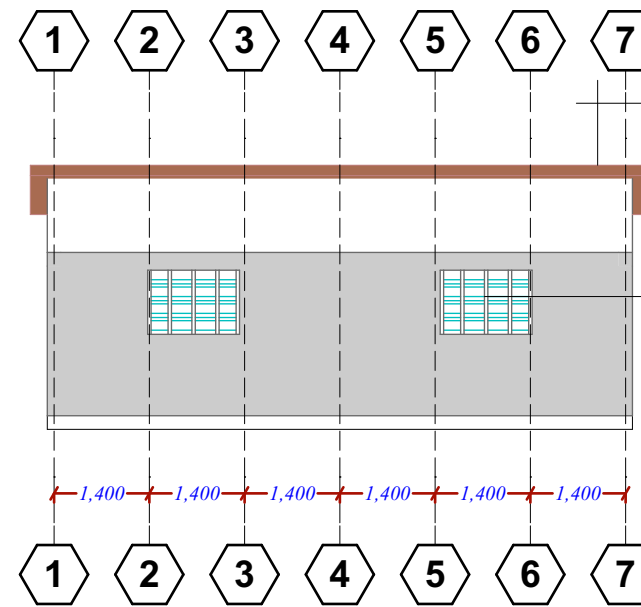


Elevation -01

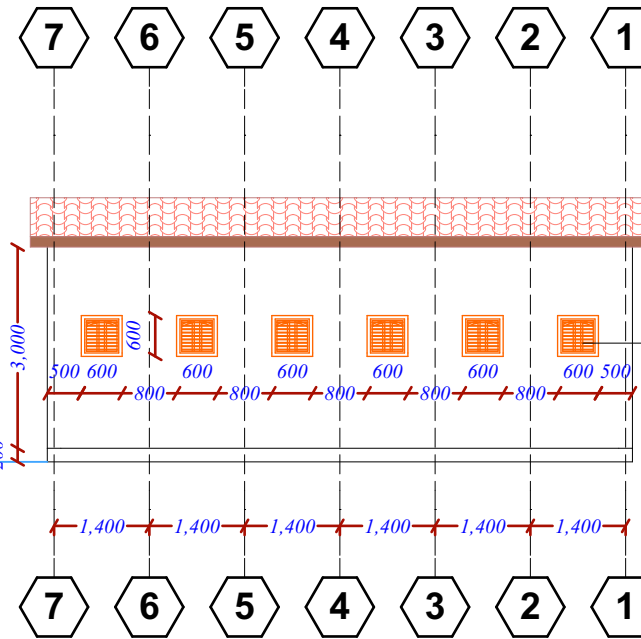


Elevation -03

Carefully remove the existing Iron sheet roof and replace to new Iron sheet

Remove the destroyed vent blocks and provide new ones with same shape and size

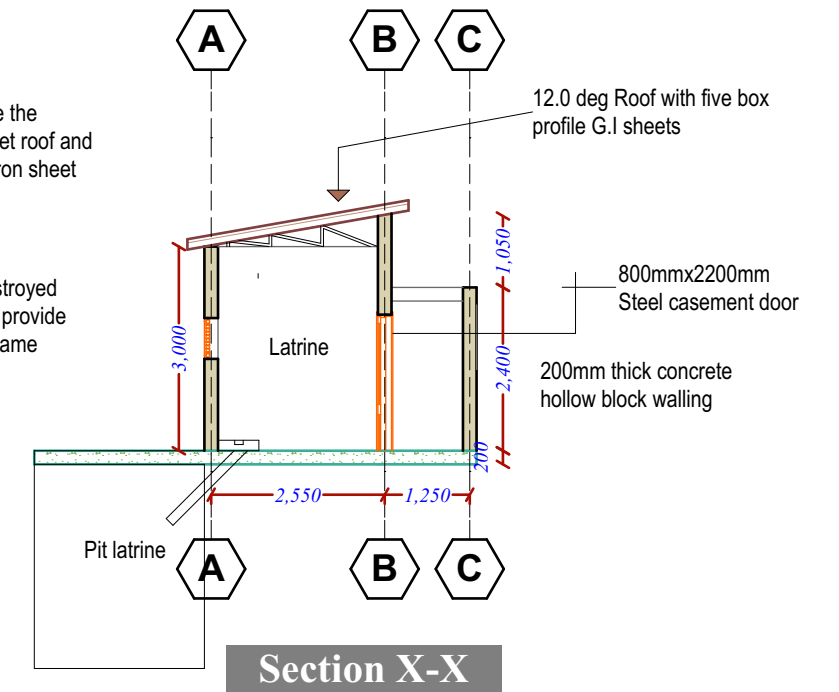

Section X-X

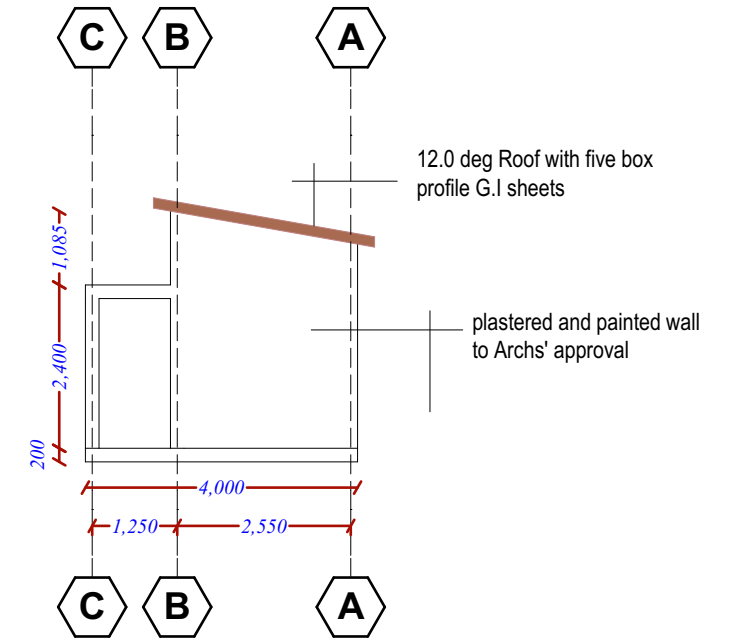

Elevation 02

PROJECT DETAILS

Client:

Implementation Partner:

Project title:



**SOUTH WEST STATE
-SOMALIA-**

**INTERNATIONAL ORGANIZATION
FOR MIGRATION (IOM)**

**PROPOSED REHABILITATION OF DR. AYUUB
FOOTBALL STADIUM IN BAIDOA**

Drawing Title:

Latrines detail

Reviewed by:

Eng. David Wanja

Drawn by:

Eng. Duale Salah

Checked by:

Sheet No.

22

Scale: N/A

Date: June, 2018

ARCHITECTURAL DRAWINGS



PROJECT DETAILS

Client:

Implementation Partner:

Project title:



**SOUTH WEST STATE
-SOMALIA-**

**INTERNATIONAL ORGANIZATION
FOR MIGRATION (IOM)**

**PROPOSED REHABILITATION OF DR. AYUUB
FOOTBALL STADIUM IN BAIDOA**

Drawing Title:

Latrines- 3D Projection

Reviewed by:

Eng. David Wanja

Drawn by:

Eng. Duale Salah

Checked by:



Sheet No.

23

Scale: N/A

Date: June, 2018

ARCHITECTURAL DRAWINGS

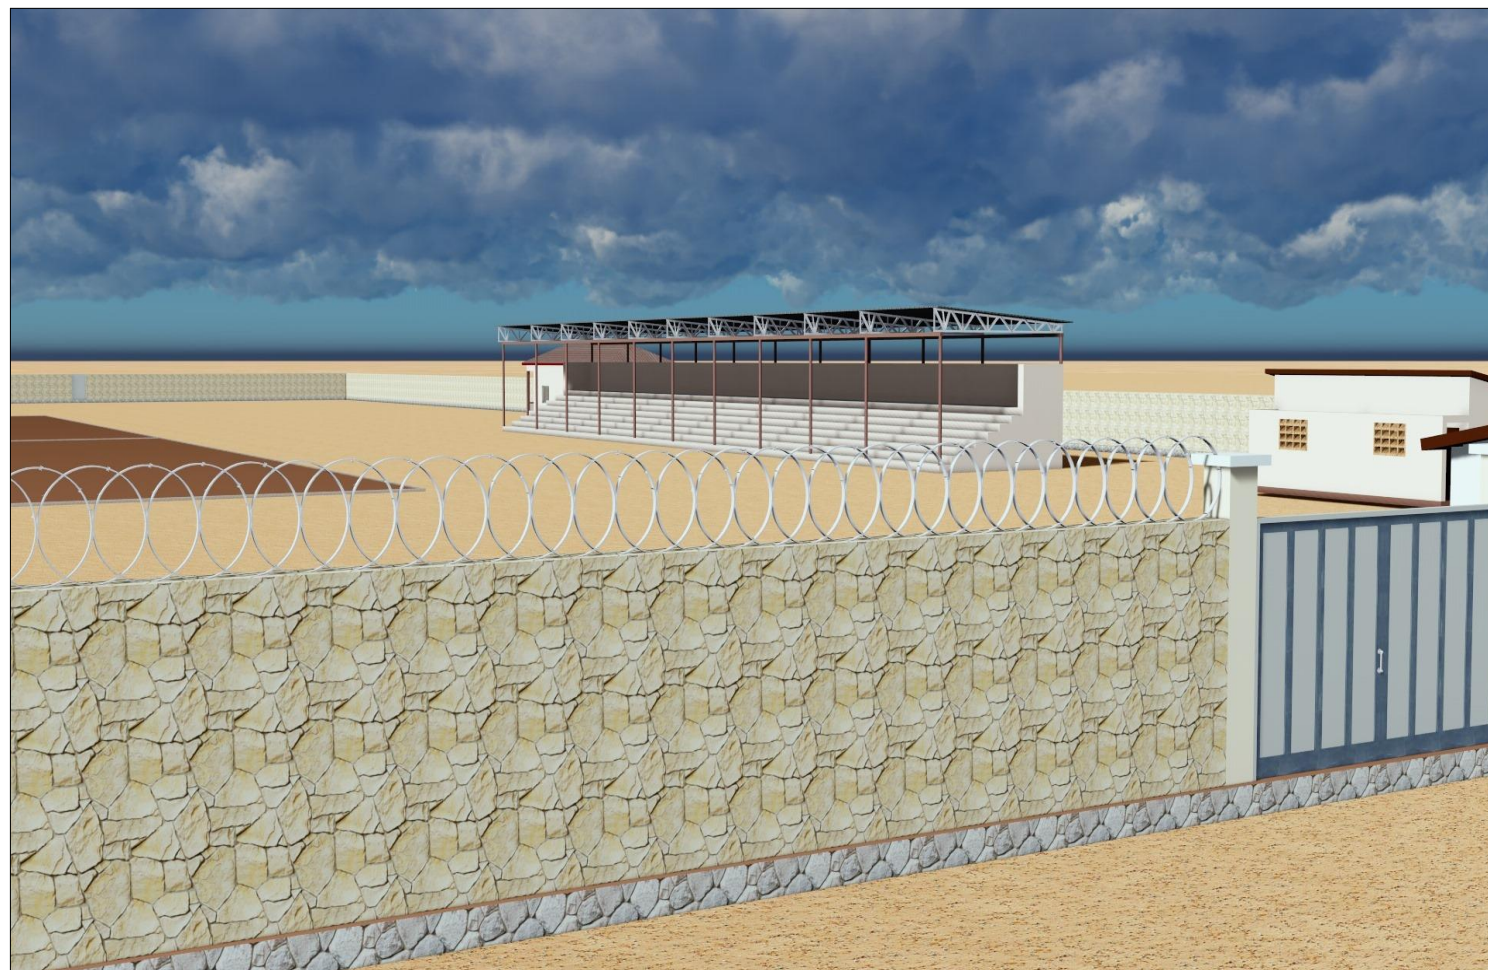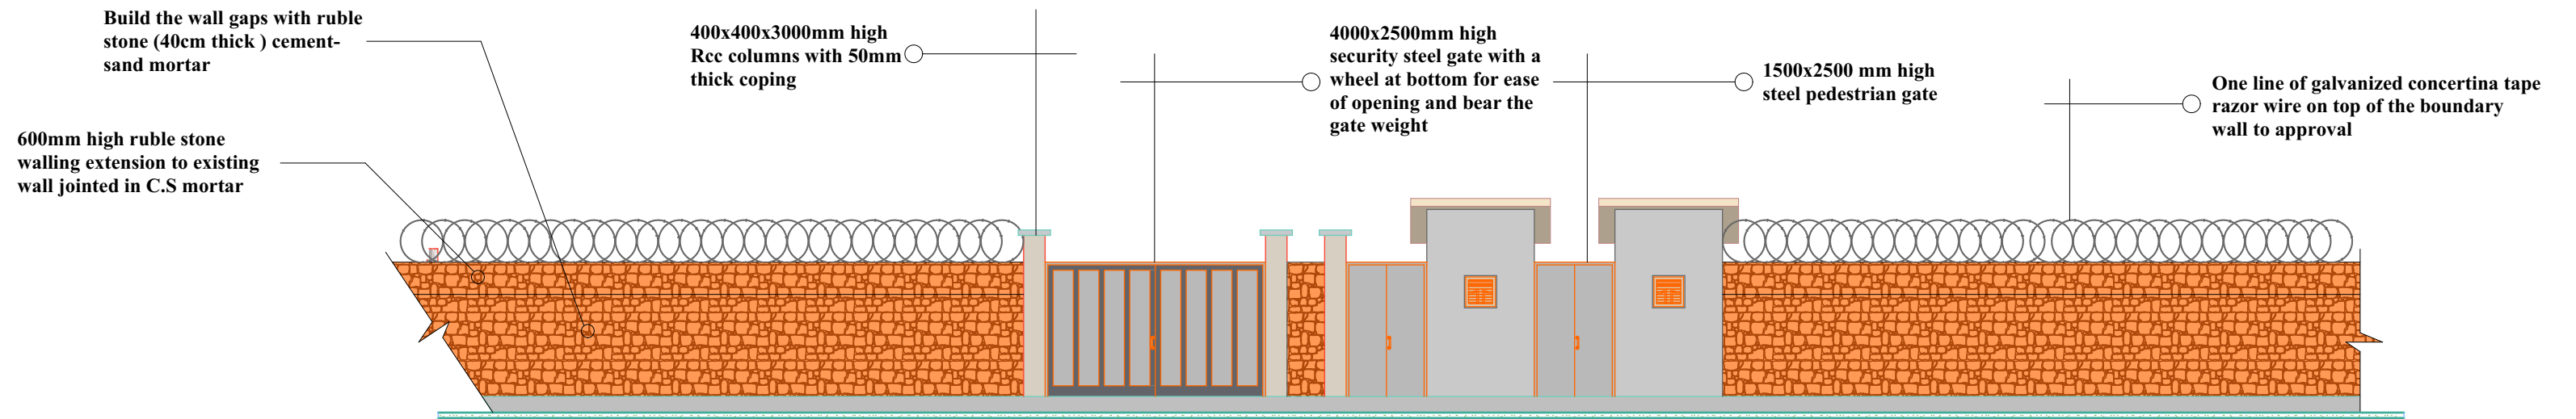

PROJECT DETAILS

Client:

Implementation Partner:

Project title:



**SOUTH WEST STATE
-SOMALIA-**

**INTERNATIONAL ORGANIZATION
FOR MIGRATION (IOM)**

**PROPOSED REHABILITATION OF DR. AYUUB
FOOTBALL STADIUM IN BAIDOA**

Drawing Title: Boundary wall detail		Reviewed by: Eng. David Wanja	
Drawn by: Eng. Duale Salah	Checked by:	Sheet No. 24	Scale: N/A
Date: June, 2018	ARCHITECTURAL DRAWINGS		