

REHABILITATION OF AFMADOW LIVESTOCK MARKET



IOM
Recovery Durable
Solutions (RDS) Unit





Sheet No.	Content
G-01	Index Sheet
A-01	Existing Site Plan
A-02	Proposed Site Plan
A-03	Covered Shed Plan and Roof Plan
A-04	Covered Shed Elevations
A-05	Covered Shed Section, Security Room, Water Tower
A-06	Ablution Block
A-07	New Openings' Schedule
A-08	Existing Site Photos
E-01	Electrical Layout
M-01	Mechanical Layout
3D-01	3D Projection 01
3D-02	3D Projection 02
3D-03	3D Projection 03
3D-04	3D Projection 04
3D-05	3D Projection 05


CLIENT

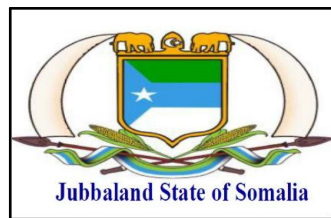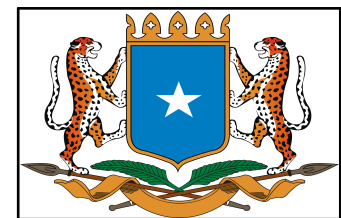

PROJECT DETAILS

Project Title:
 REHABILITATION OF AFMADOW LIVESTOCK MARKET

IMPLEMENTING

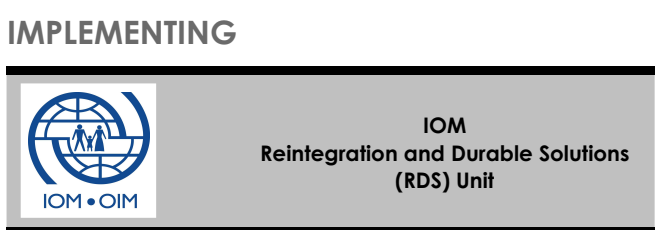

Drawing Title:

INDEX SHEET

Revision No.

--

Drawn by:

D.Salah

Checked & Approved by:

Sheet No.


G-01

Scale:



N/A

Date: JAN. 2019

ARCHITECTURAL DRAWINGS

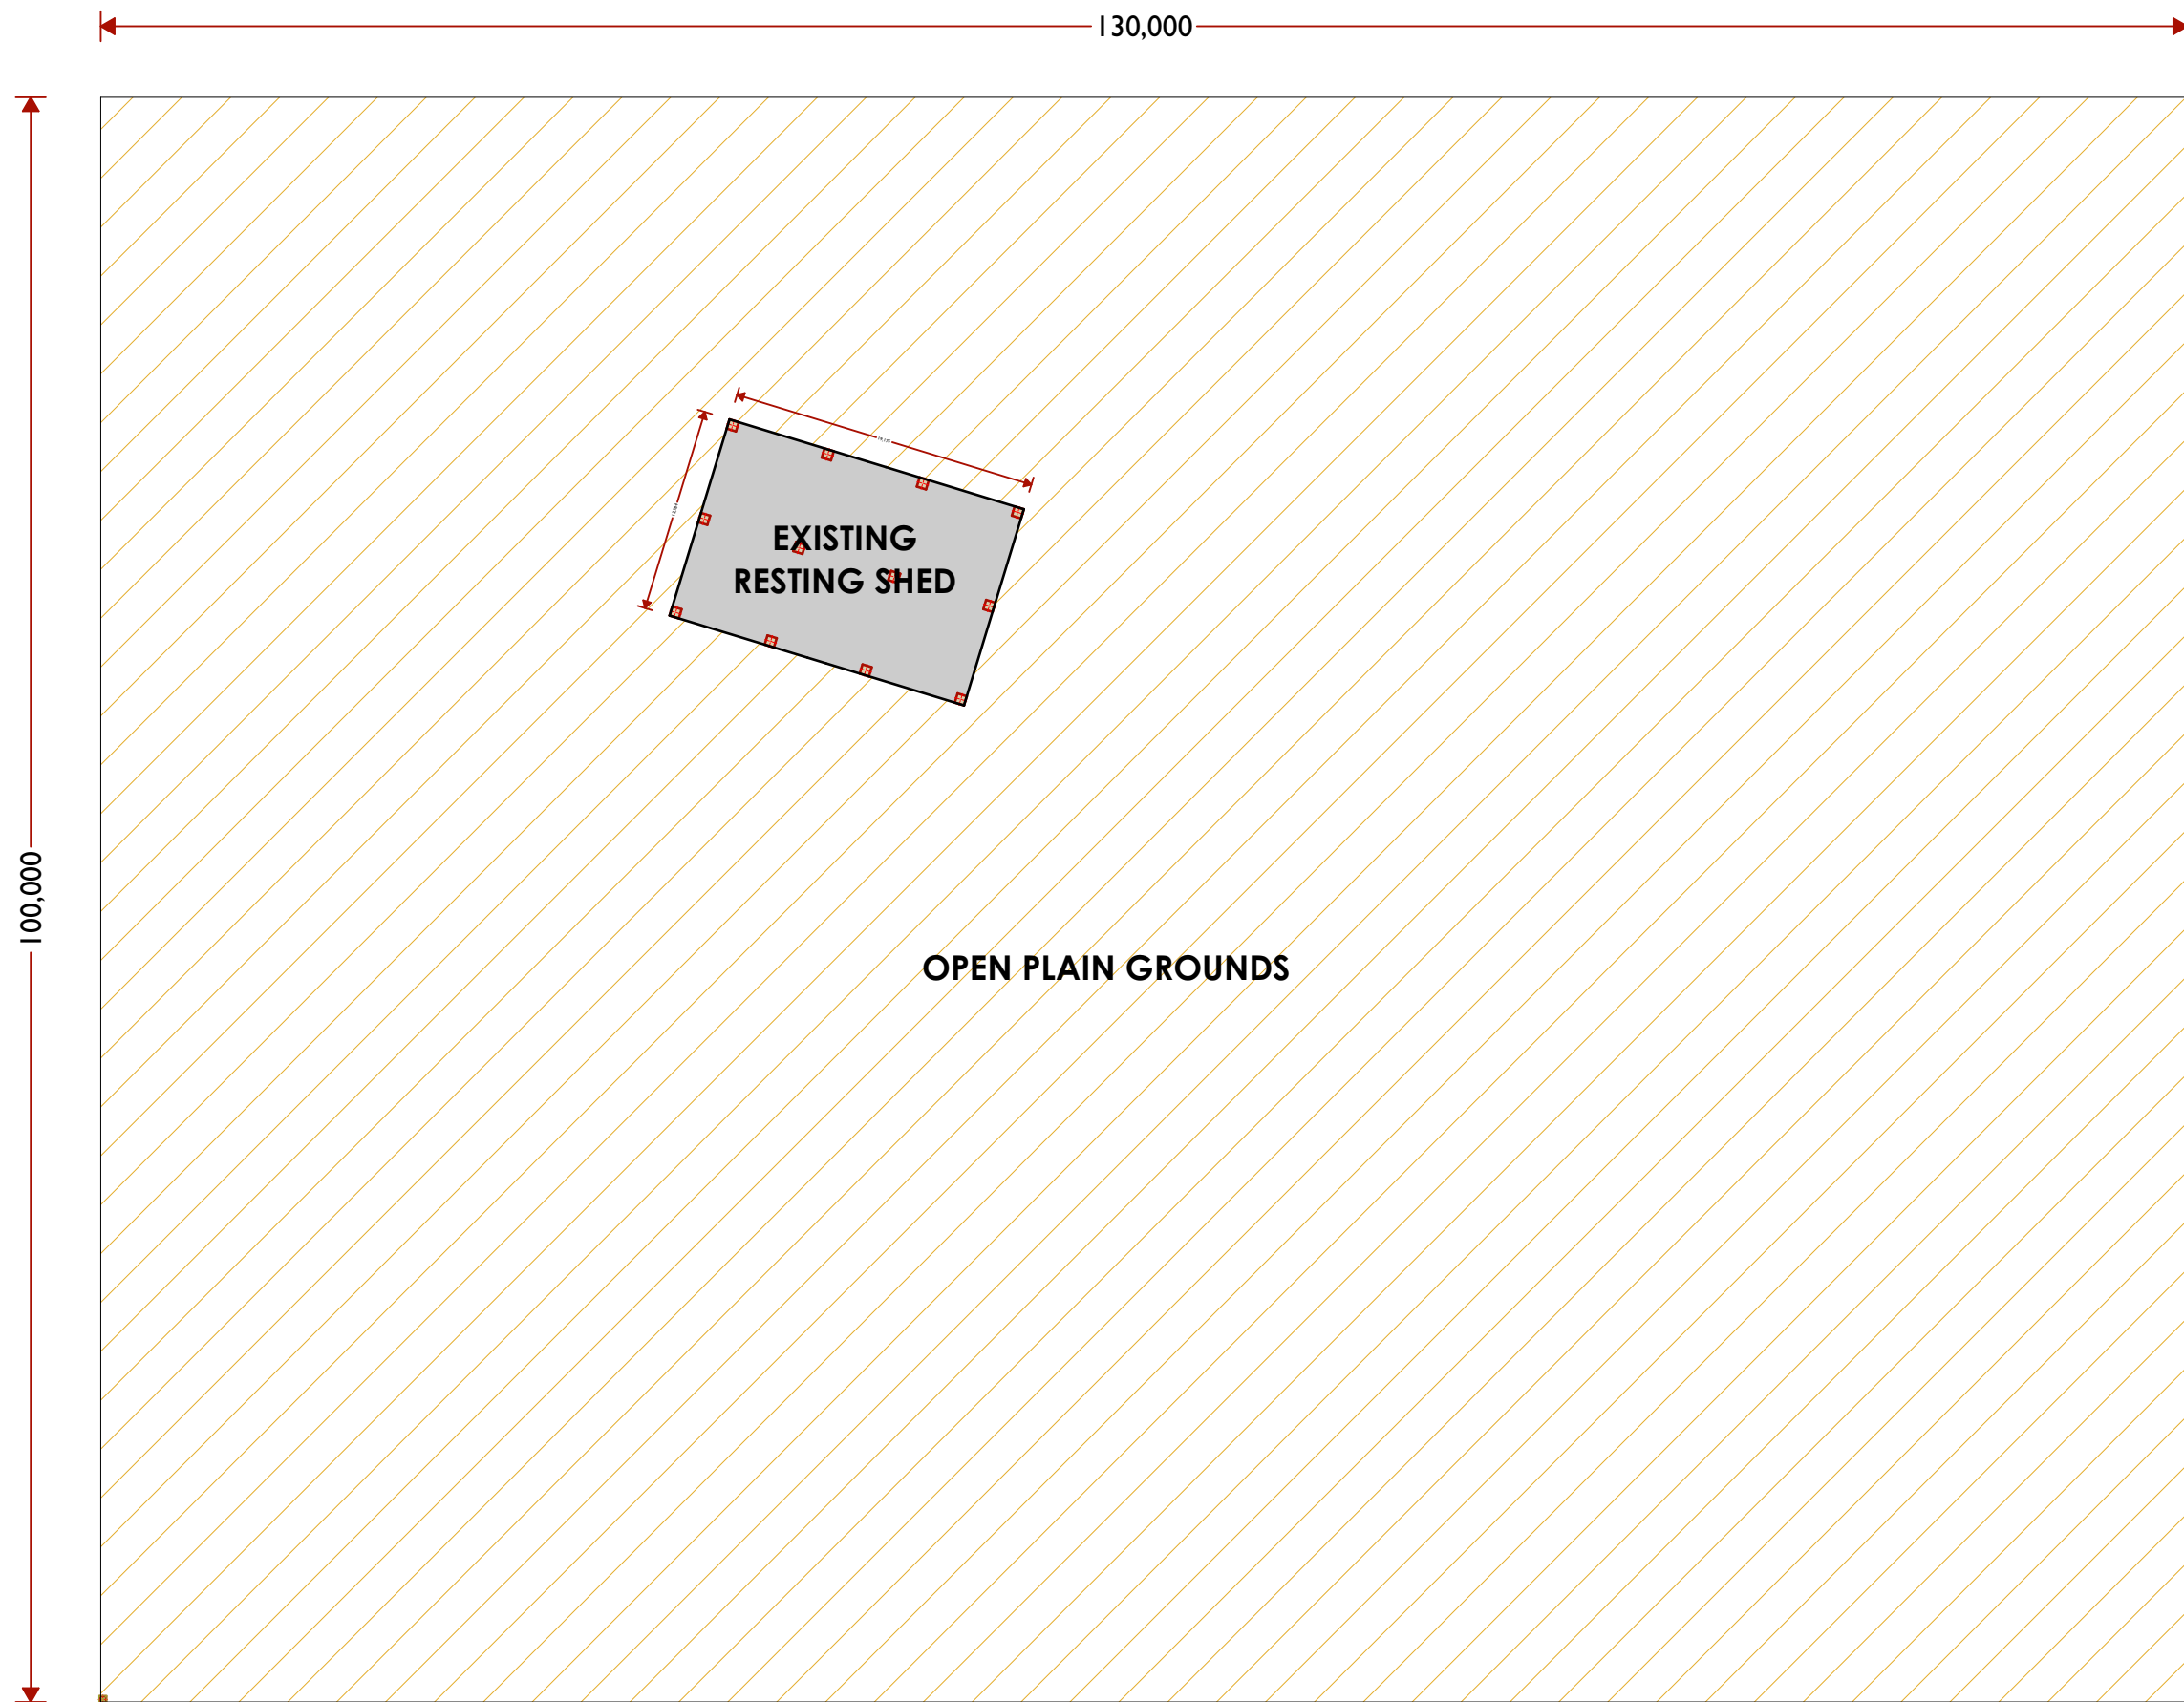

CLIENT

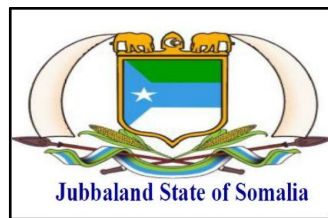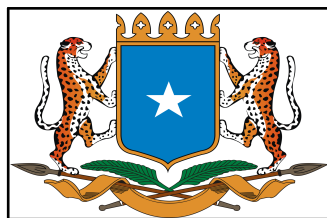

PROJECT DETAILS

Project Title:


REHABILITATION OF AFMADOW LIVESTOCK MARKET

IMPLEMENTING





IOM
Reintegration and Durable Solutions
(RDS) Unit

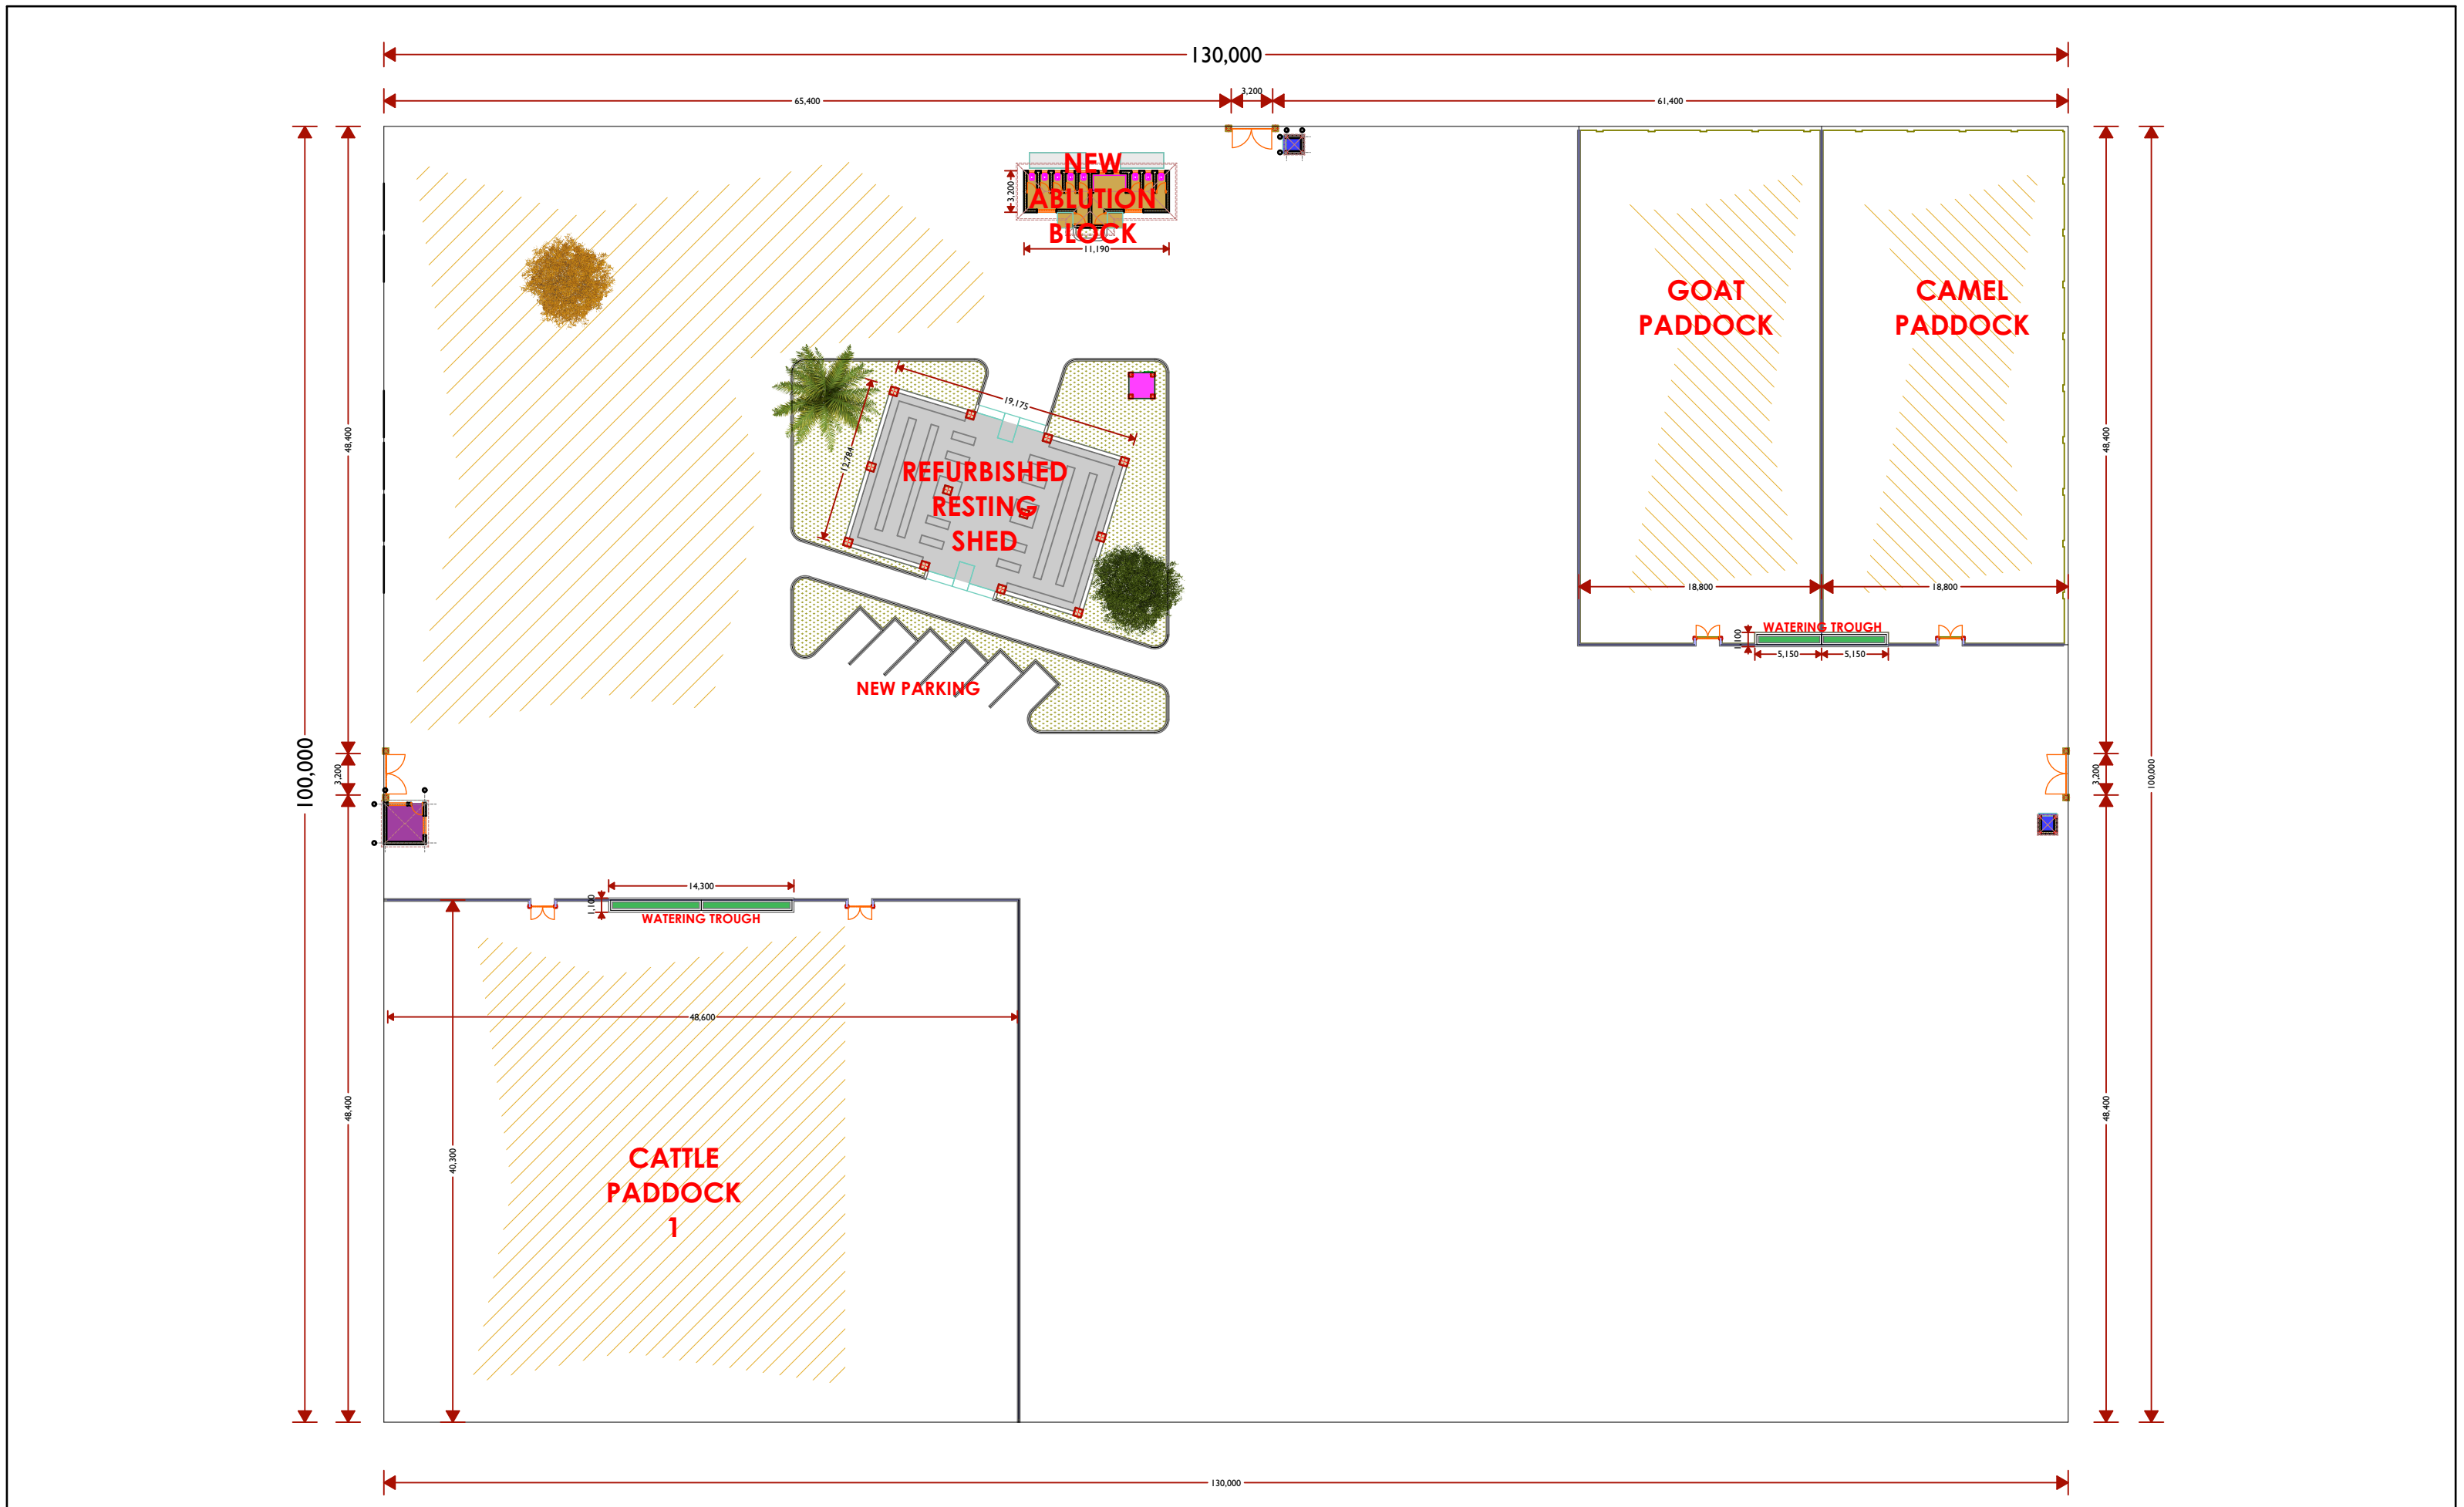Drawing Title: EXISTING SITE PLAN		Revision No. --	
Drawn by: D.Salah	Checked & Approved by:	Sheet No. A-01	Scale: As Shown
Date: JAN. 2019	ARCHITECTURAL DRAWINGS		



CLIENT

Jubaland State of Somalia

PROJECT DETAILS

Project Title:


REHABILITATION OF AFMADOW LIVESTOCK MARKET

IMPLEMENTING



IOM
Reintegration and Durable Solutions
(RDS) Unit



Drawing Title: PROPOSED SITE PLAN		Revision No. --	
Drawn by: D.Salah	Checked & Approved by:	Sheet No. A-02	Scale: As Shown
Date: JAN. 2019	ARCHITECTURAL DRAWINGS		

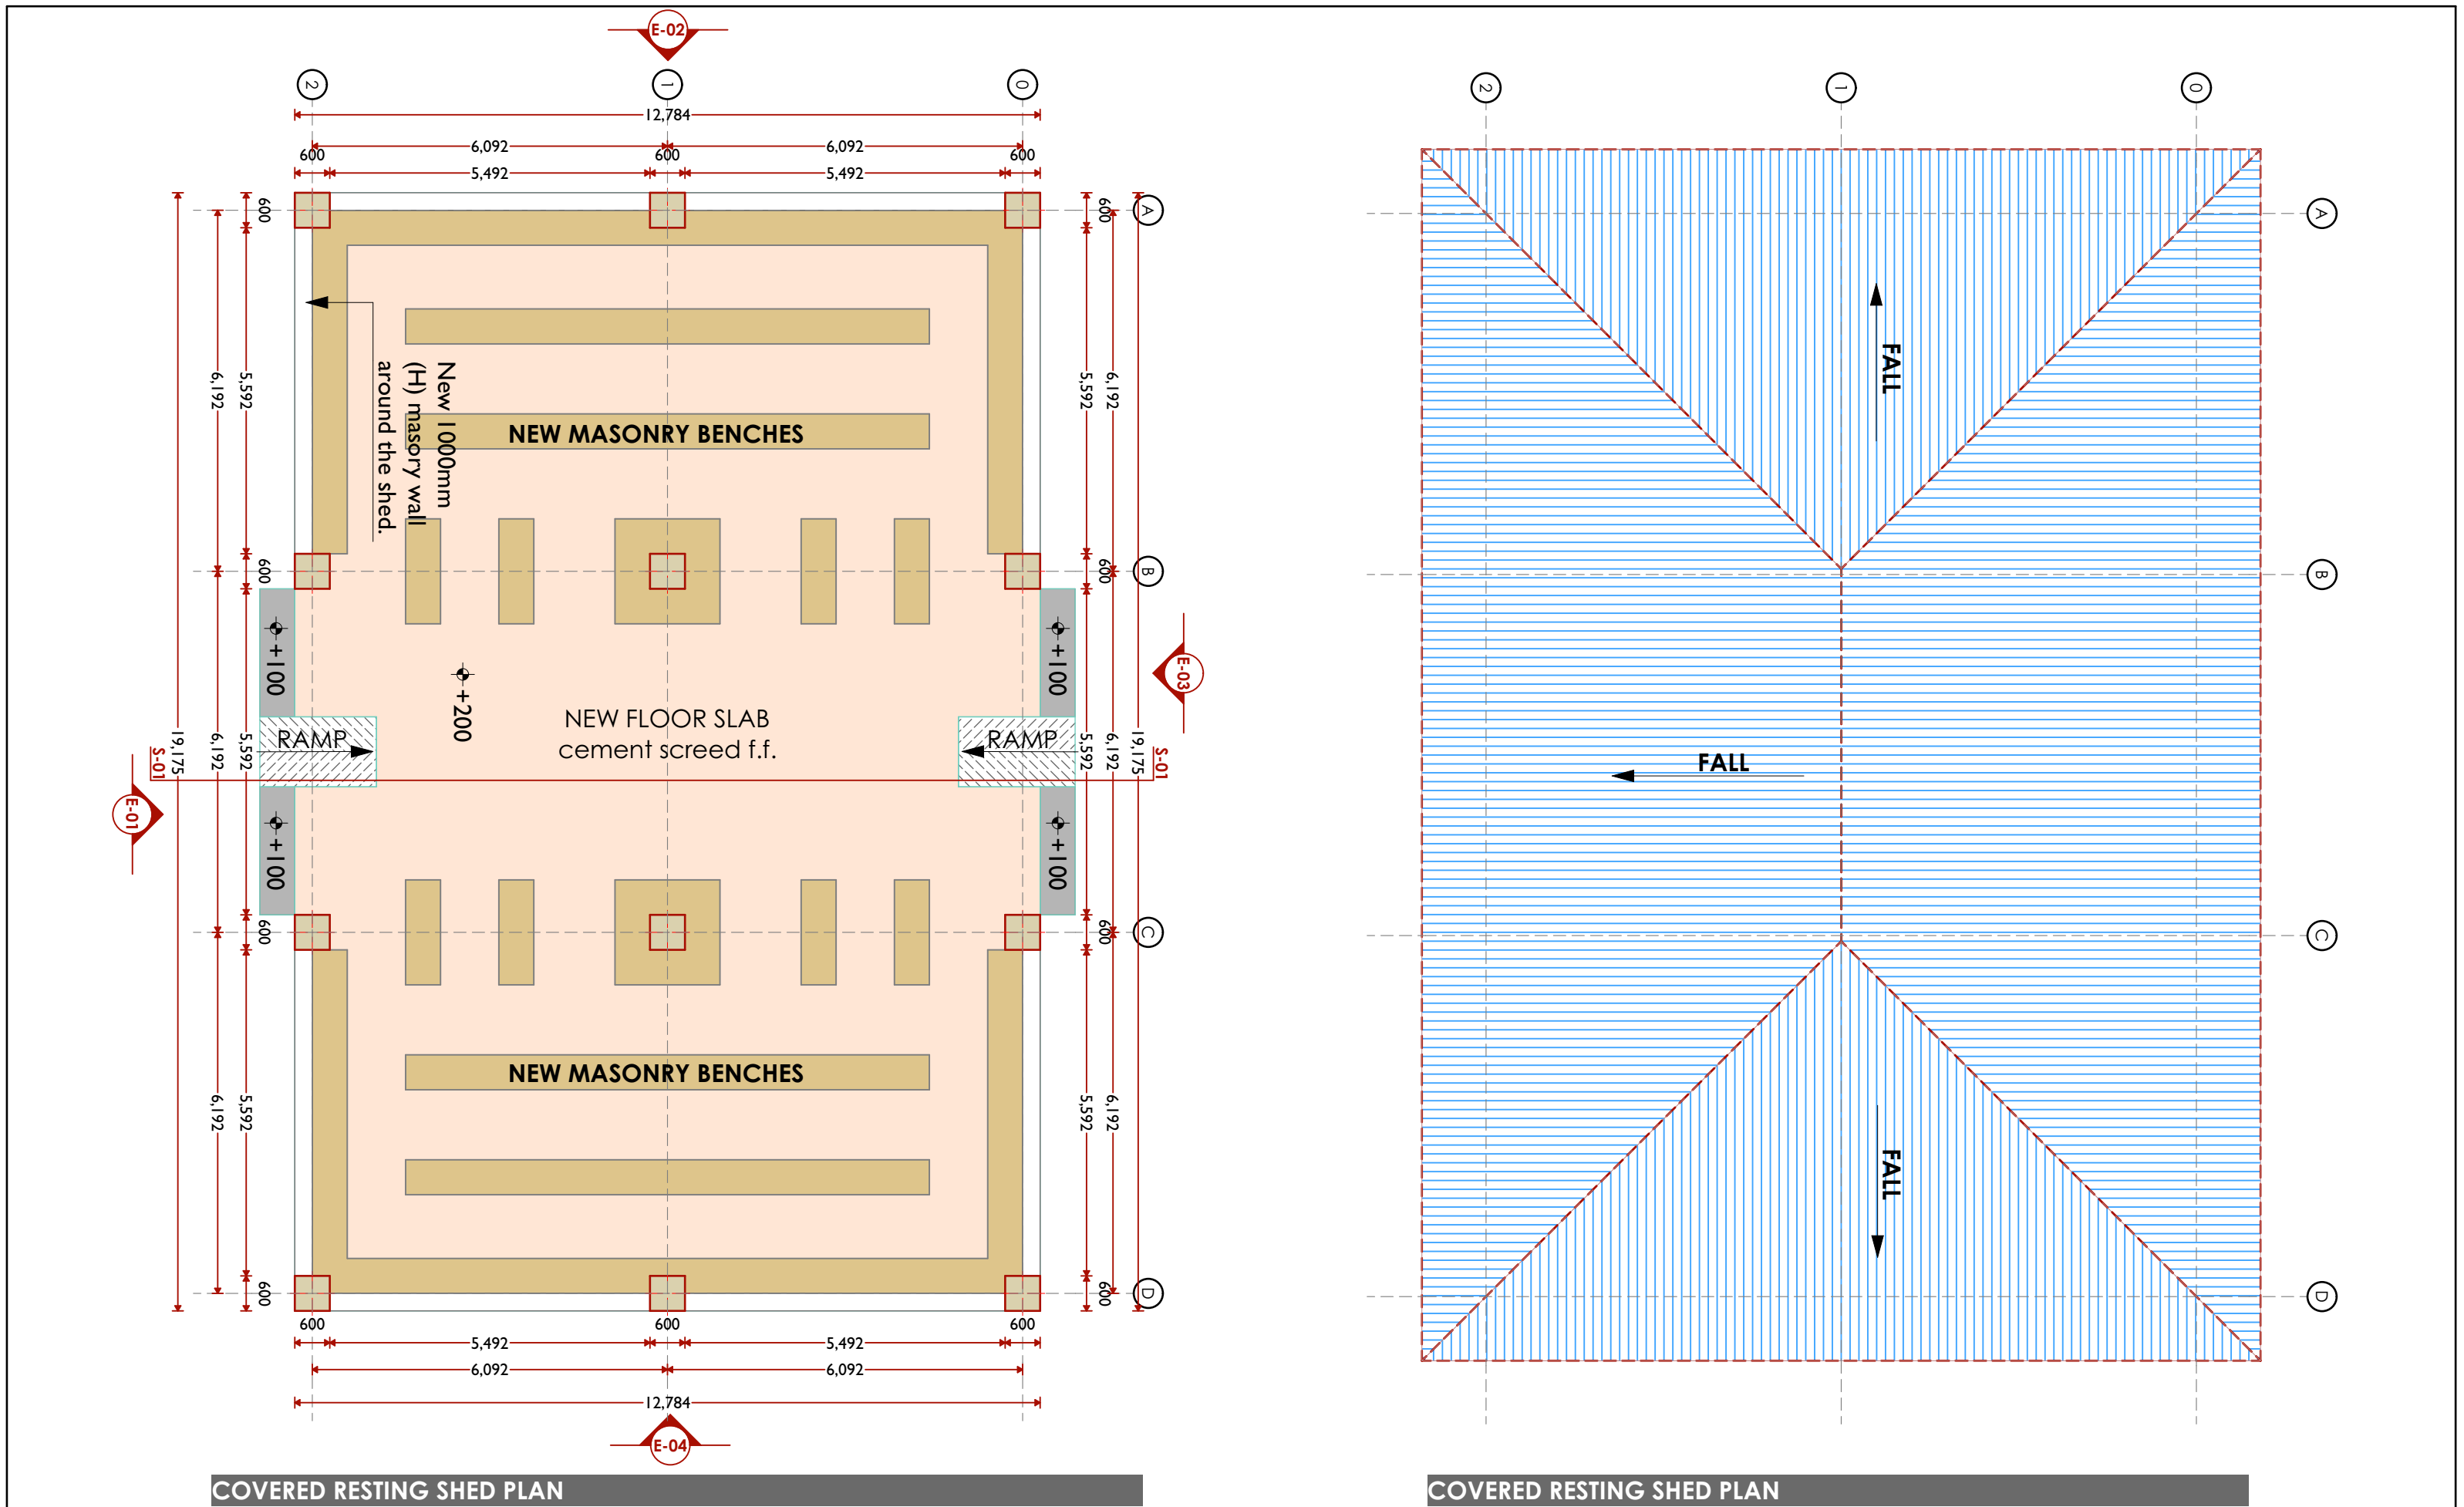

COVERED RESTING SHED PLAN

COVERED RESTING SHED PLAN

CLIENT

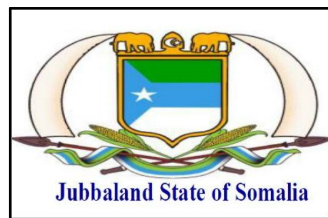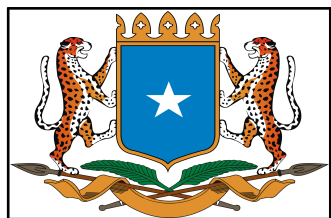

PROJECT DETAILS

Project Title:

REHABILITATION OF AFMADOW LIVESTOCK MARKET

IMPLEMENTING



IOM
Reintegration and Durable Solutions
(RDS) Unit

Drawing Title:

COVERED SHED FLOOR AND ROOF PLAN

Revision No.

--

Drawn by:

D.Salah

Checked & Approved by:

Sheet No.


A-03

Scale:



As Shown

Date: JAN. 2019

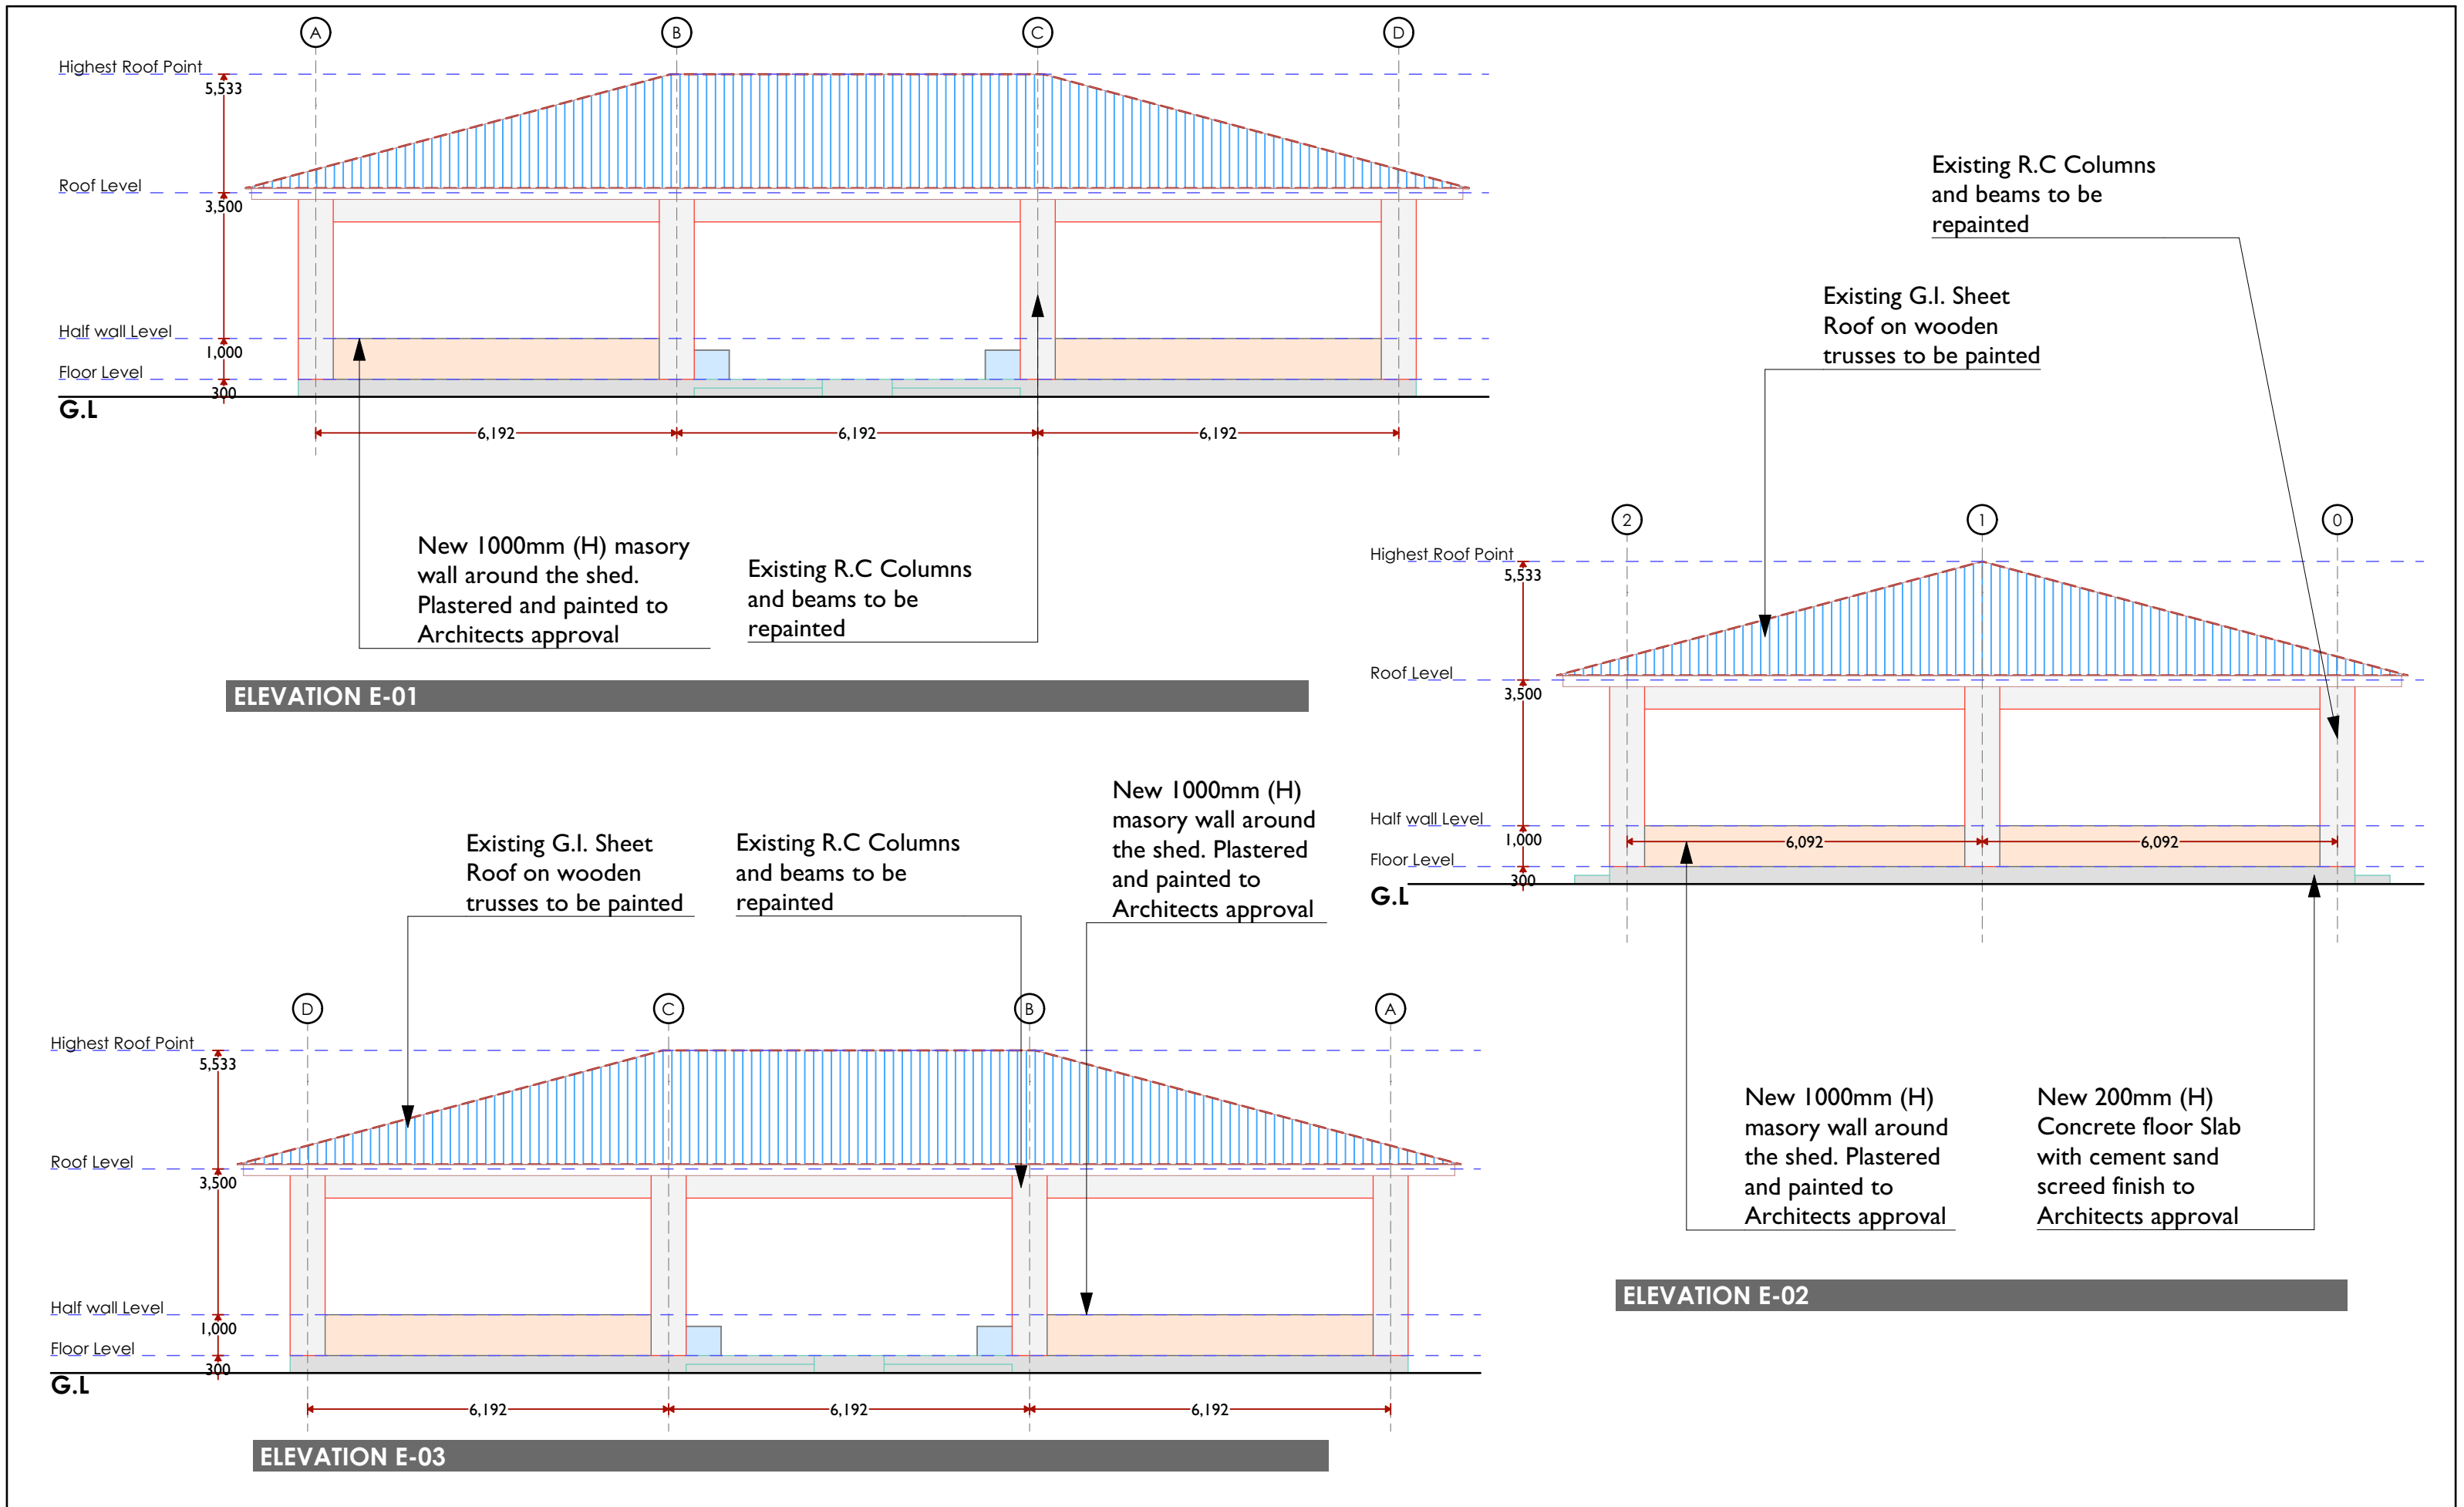ARCHITECTURAL DRAWINGS



CLIENT

Jubbaland State of Somalia

PROJECT DETAILS









Project Title: REHABILITATION OF AFMADOW LIVESTOCK MARKET

IMPLEMENTING





IOM
Reintegration and Durable Solutions
(RDS) Unit

Drawing Title: COVERED SHED ELEVATIONS		Revision No. --	
Drawn by: D.Salah	Checked & Approved by:	Sheet No. A-04	Scale: 1:100
Date: JAN. 2019	ARCHITECTURAL DRAWINGS		

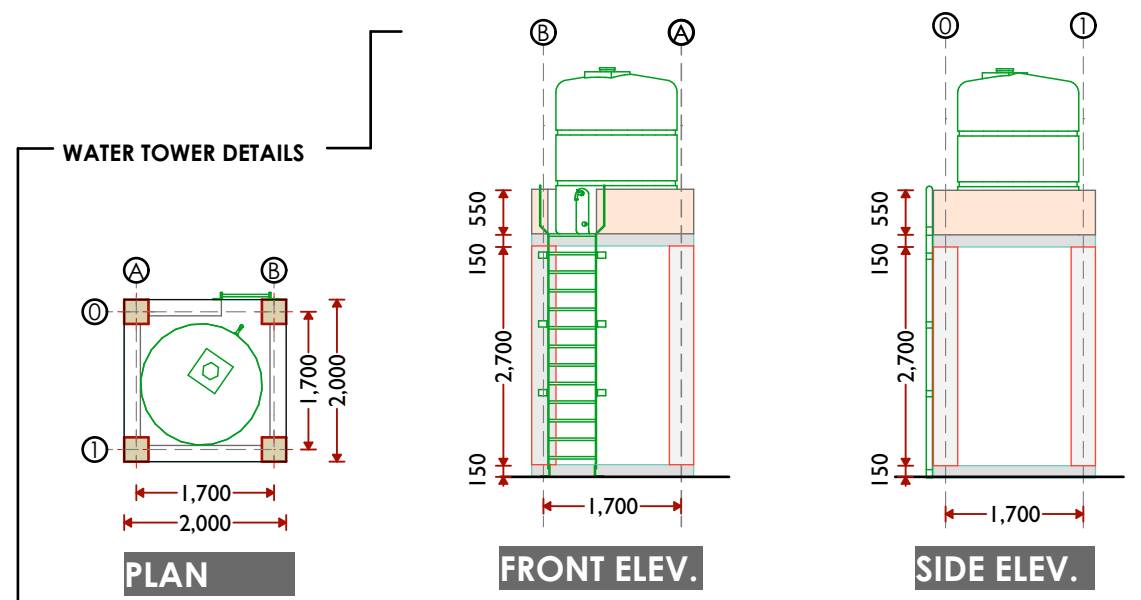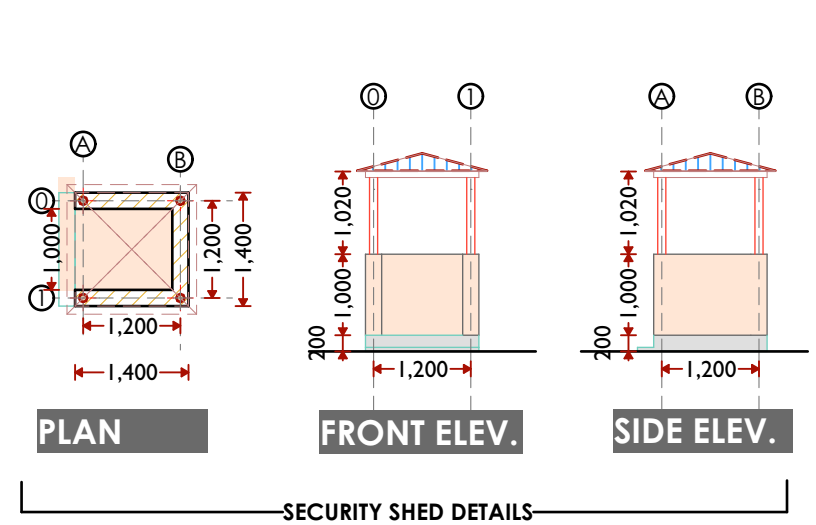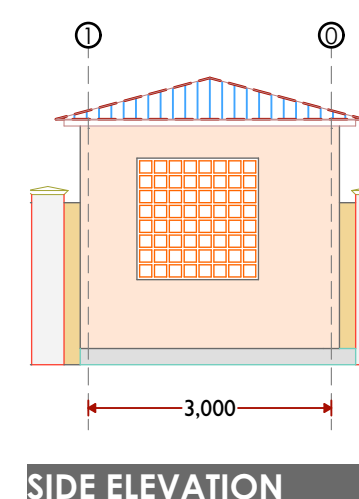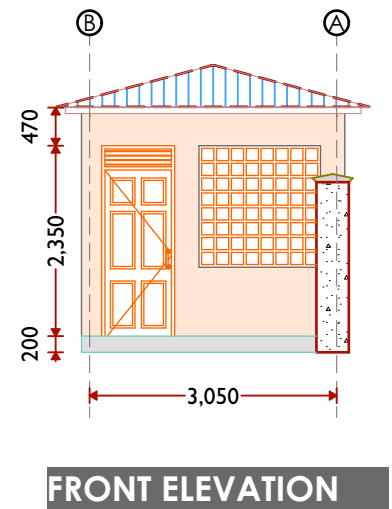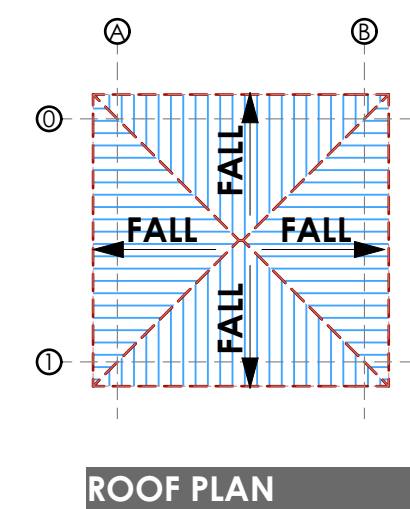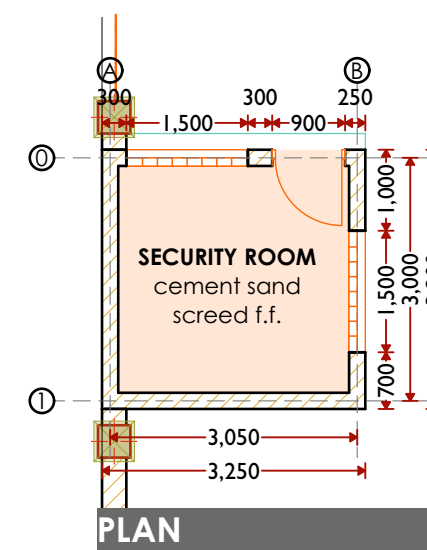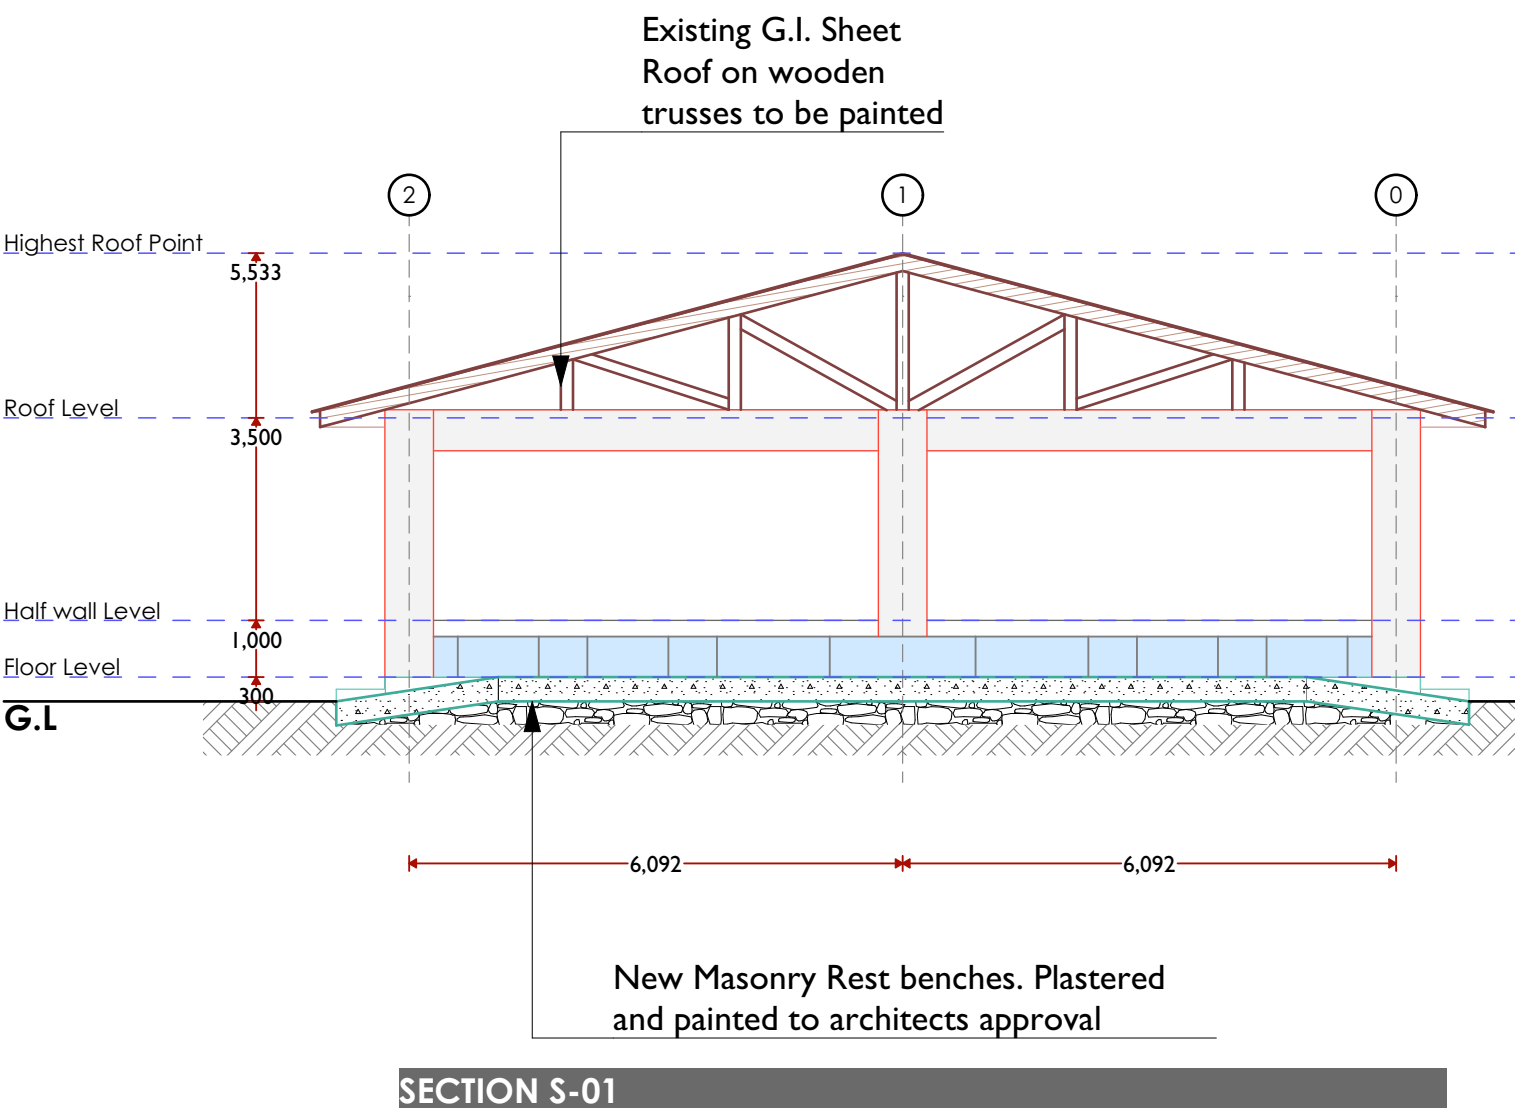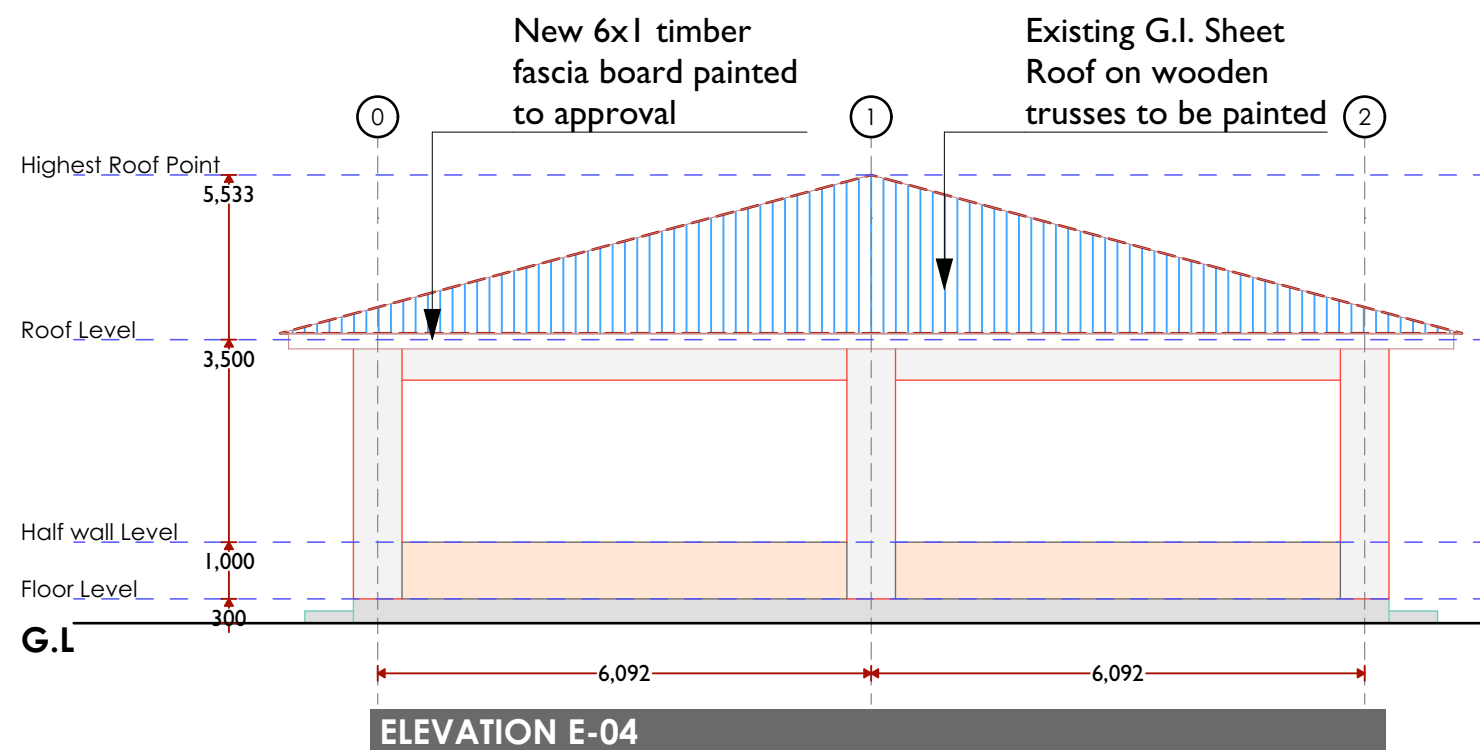

CLIENT

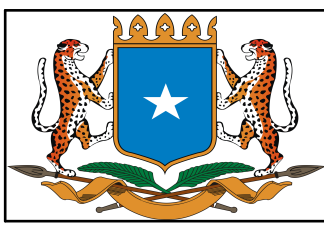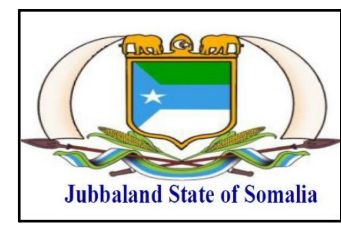Jubbaland State of Somalia

PROJECT DETAILS

Project Title: REHABILITATION OF AFMADOW LIVESTOCK MARKET

IMPLEMENTING



IOM
Reintegration and Durable Solutions
(RDS) Unit

Drawing Title: COVERED SHEDSECTION, SECURITY ROOM & SHED, WATER TOWER

Revision No. --

Drawn by: D.Salah


Checked & Approved by:

Sheet No. A-05


Scale: As Shown

Date: JAN. 2019


ARCHITECTURAL DRAWINGS

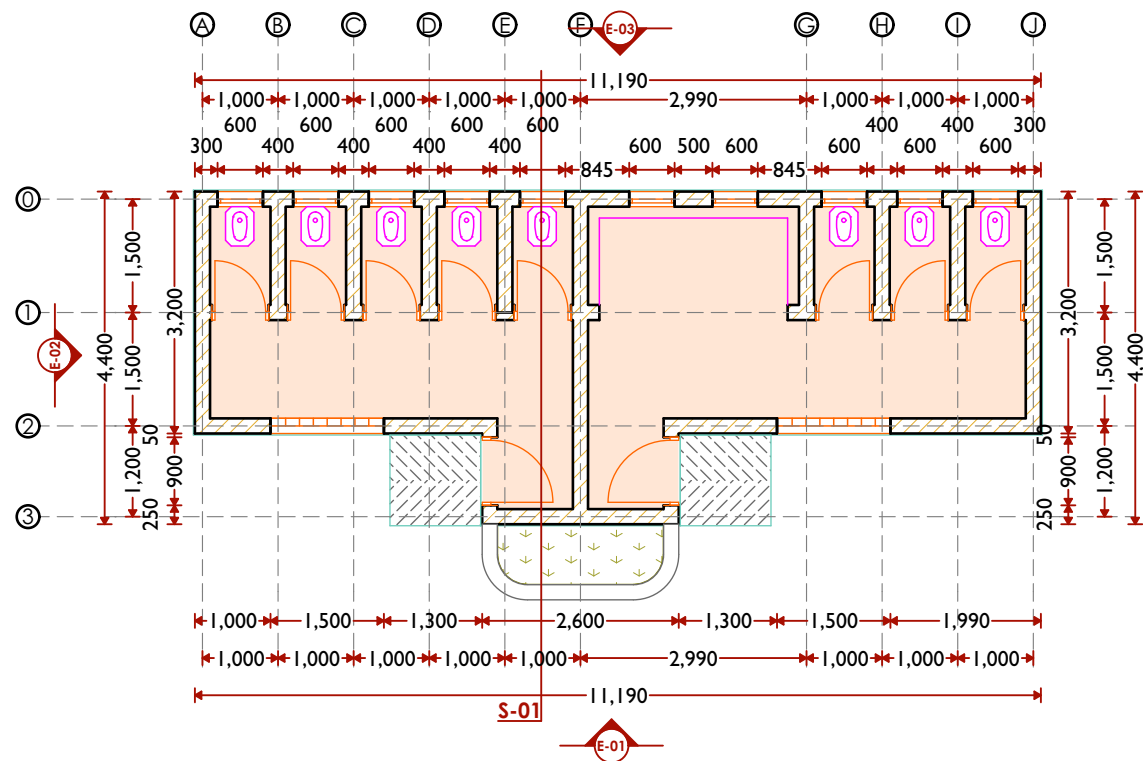

ABLUION BLOCK PLAN

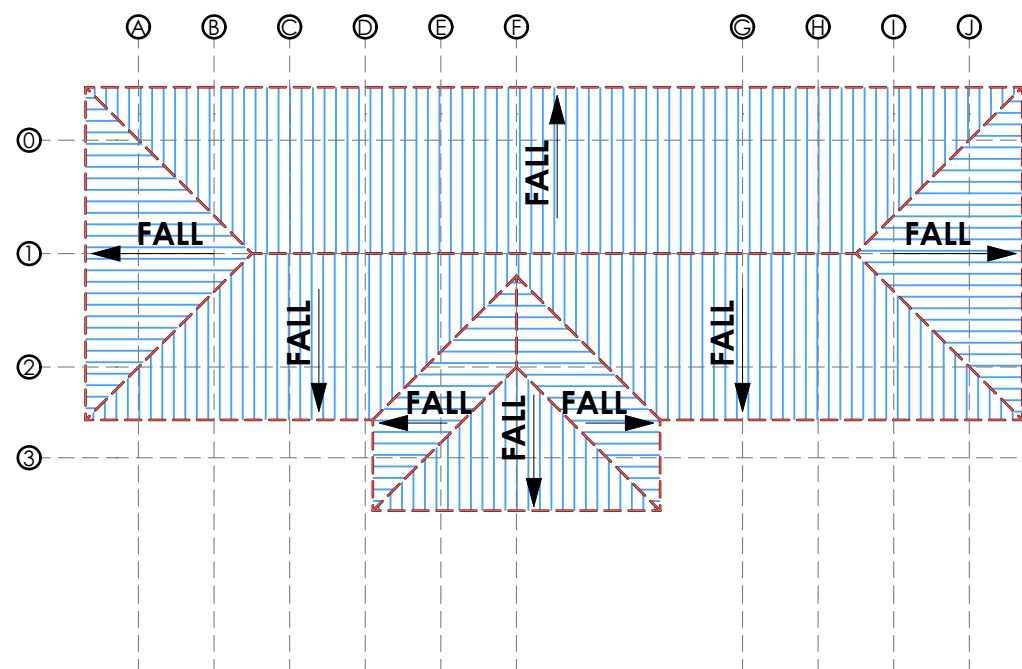


ABLUION BLOCK ROOF PLAN

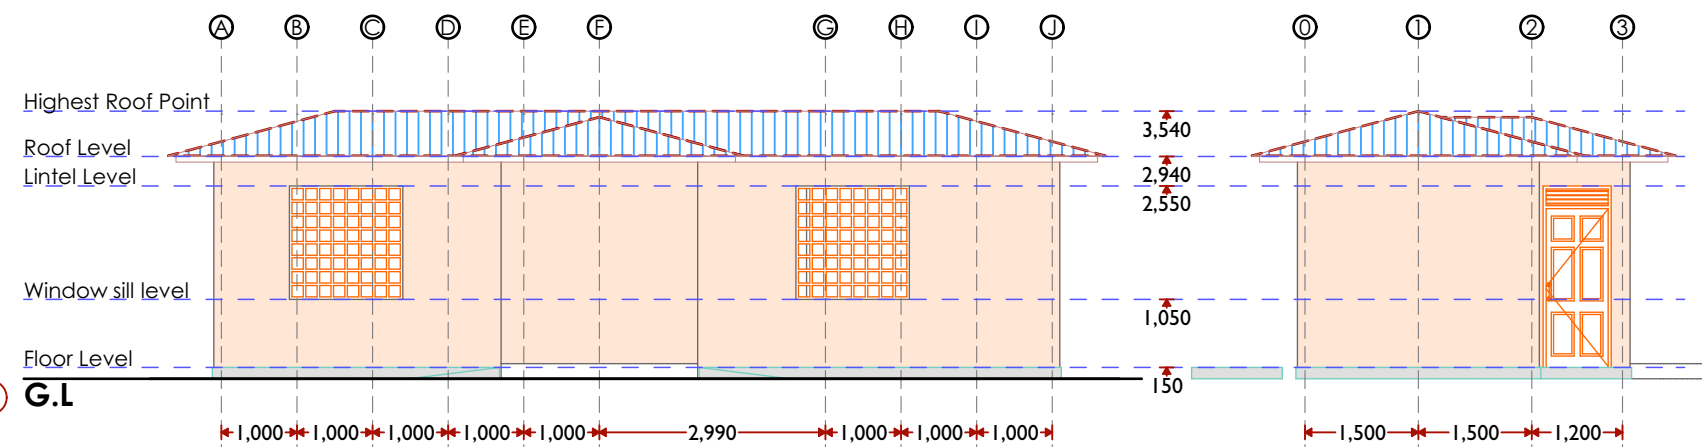


ELEVATION E-01

ELEVATION E-02

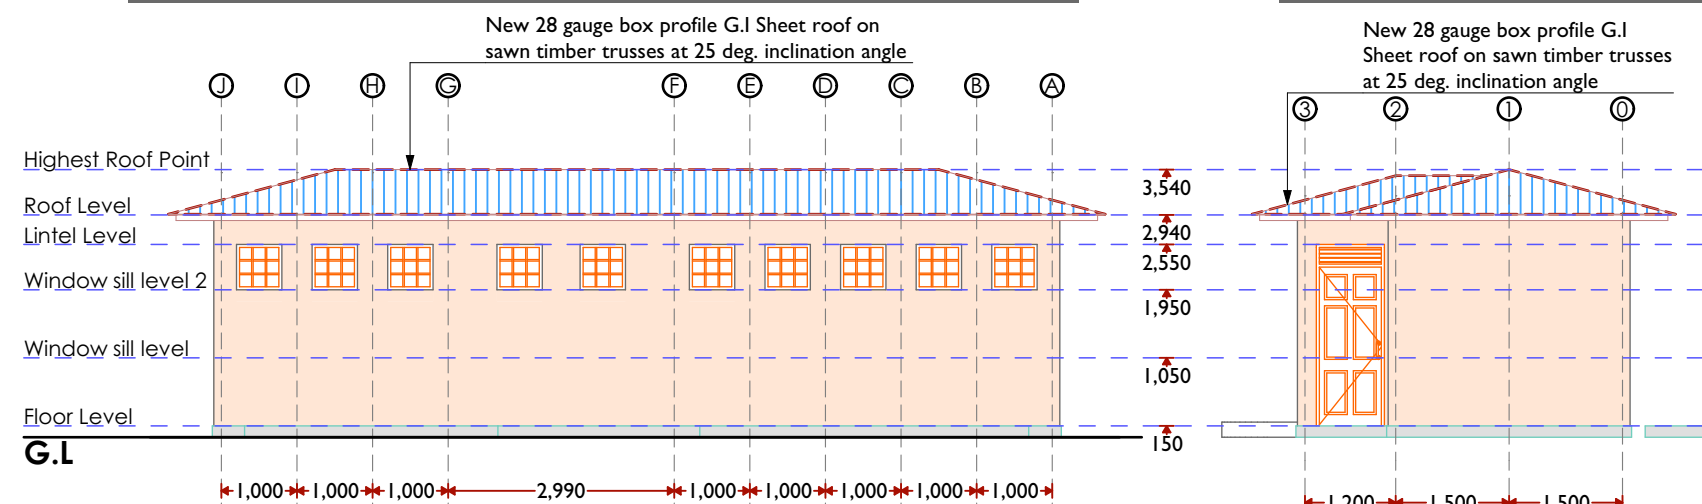


ELEVATION E-03

ELEVATION E-04


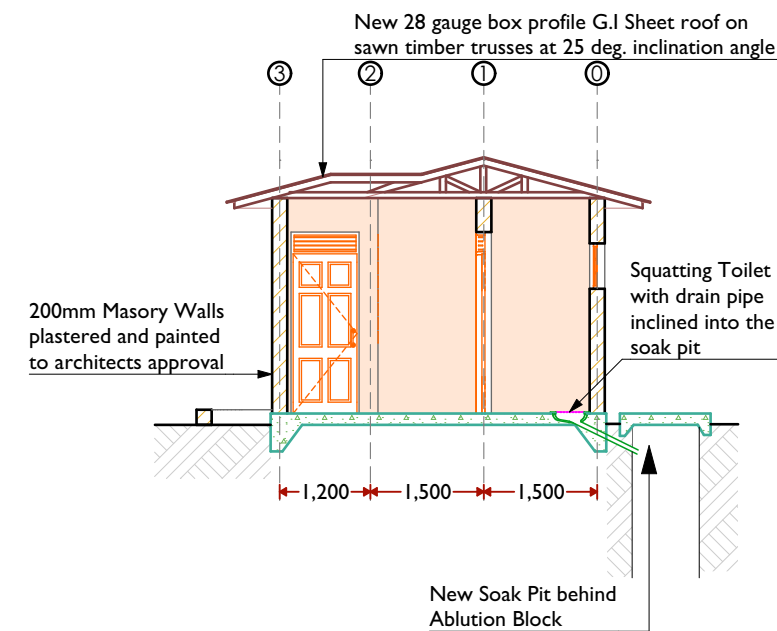


SECTION S-01

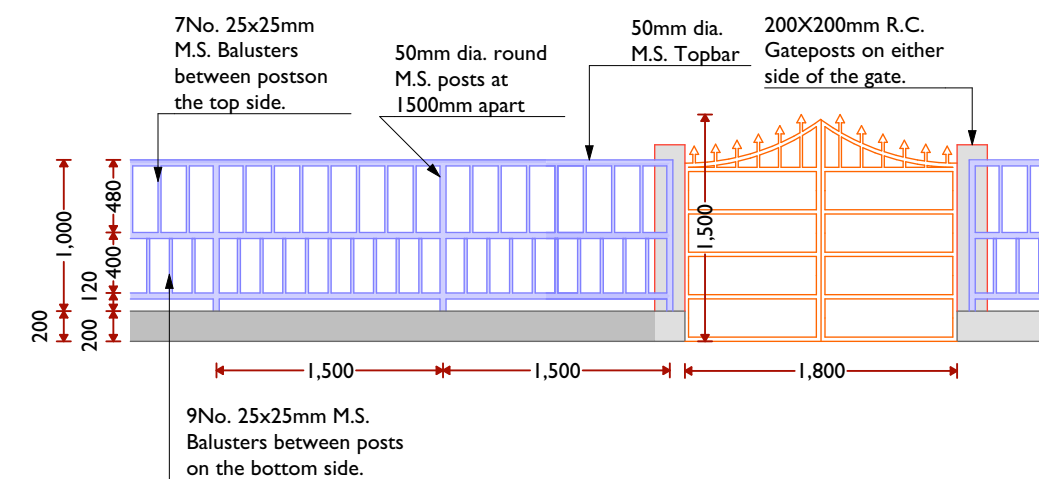

PADDOCK PARTITIONING DETAILS

CLIENT

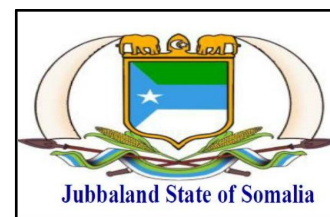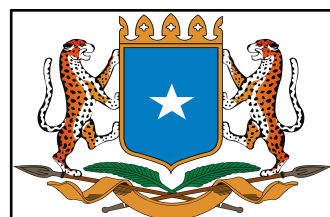

PROJECT DETAILS

Project Title:

REHABILITATION OF AFMADOW LIVESTOCK MARKET

IMPLEMENTING



IOM
Reintegration and Durable Solutions
(RDS) Unit

Drawing Title:

WASHROOMS, PADDOCK PARTITION AND GATE

Revision No.

--

Drawn by:

D.Salah

Checked & Approved by:

Sheet No.




 


A-06

Scale:



As Shown

Date: JAN. 2019

ARCHITECTURAL DRAWINGS

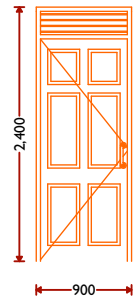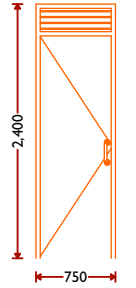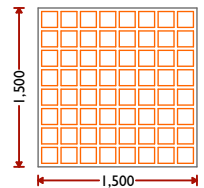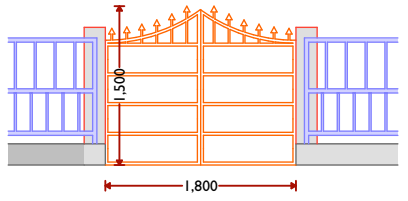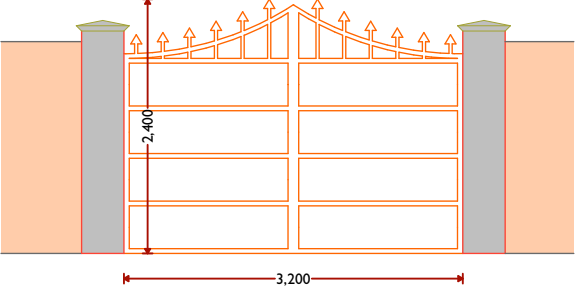OPENING	NAME	QTY.	WIDTH	HEIGHT	
	D-01	3	900	2400	TIMBER PANEL SWING DOOR WITH LOCKABLE DOOR LATCH AND 3 WELDED HINGES
	D-02	8	750	2400	FLUSH SWING DOOR WITH DOOR LATCH AND 3 HINGES FOR TOILET CUBICLES
	W-01	3	1500	1500	PRECAST CONCRETE VENTILATION BLOCKS FOR ABLUTION BLOCK AND SECURITY ROOM
	W-02	10	600	600	M.S. CASEMENT WINDOW WITH 4mm GLASS PANES TO FABRICATOR'S DETAILS
	G-01	9	1800	1500	M.S HEAVY METAL DOUBLE SWING GATE BOITED TO 200x200MM REINFORCED COLLUMN ON EITHER SIDES.
	G-02	3	3200	2400	M.S HEAVY METAL DOUBLE SWING GATE BOITED TO 300x300MM REINFORCED COLLUMN ON EITHER SIDES.

CLIENT

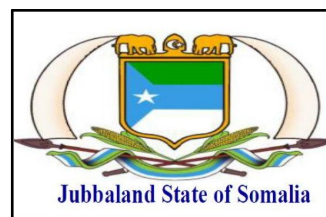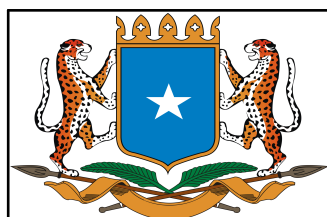

PROJECT DETAILS

Project Title:

REHABILITATION OF AFMADOW LIVESTOCK MARKET

IMPLEMENTING



IOM
Reintegration and Durable Solutions
(RDS) Unit

Drawing Title: OPENINGS SCHEDULE

Revision No. --

Drawn by: D.Salah	Checked & Approved by:	Sheet No. A-07	Scale: As Shown
----------------------	------------------------	-------------------	--------------------



Date: JAN. 2019

ARCHITECTURAL DRAWINGS

EXISTING SITE PHOTOS



CLIENT

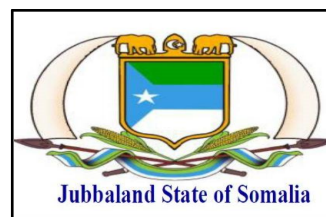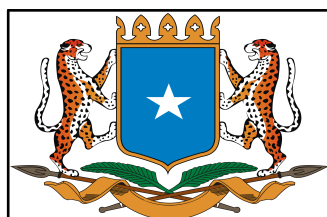

PROJECT DETAILS

Project Title:

REHABILITATION OF AFMADOW LIVESTOCK MARKET

IMPLEMENTING



IOM
Reintegration and Durable Solutions
(RDS) Unit

Drawing Title:

EXISTING SITE PHOTOS

Revision No.

--

Drawn by:

D.Salah

Checked & Approved by:

Sheet No.


A-08

Scale:



As Shown

Date: JAN. 2019

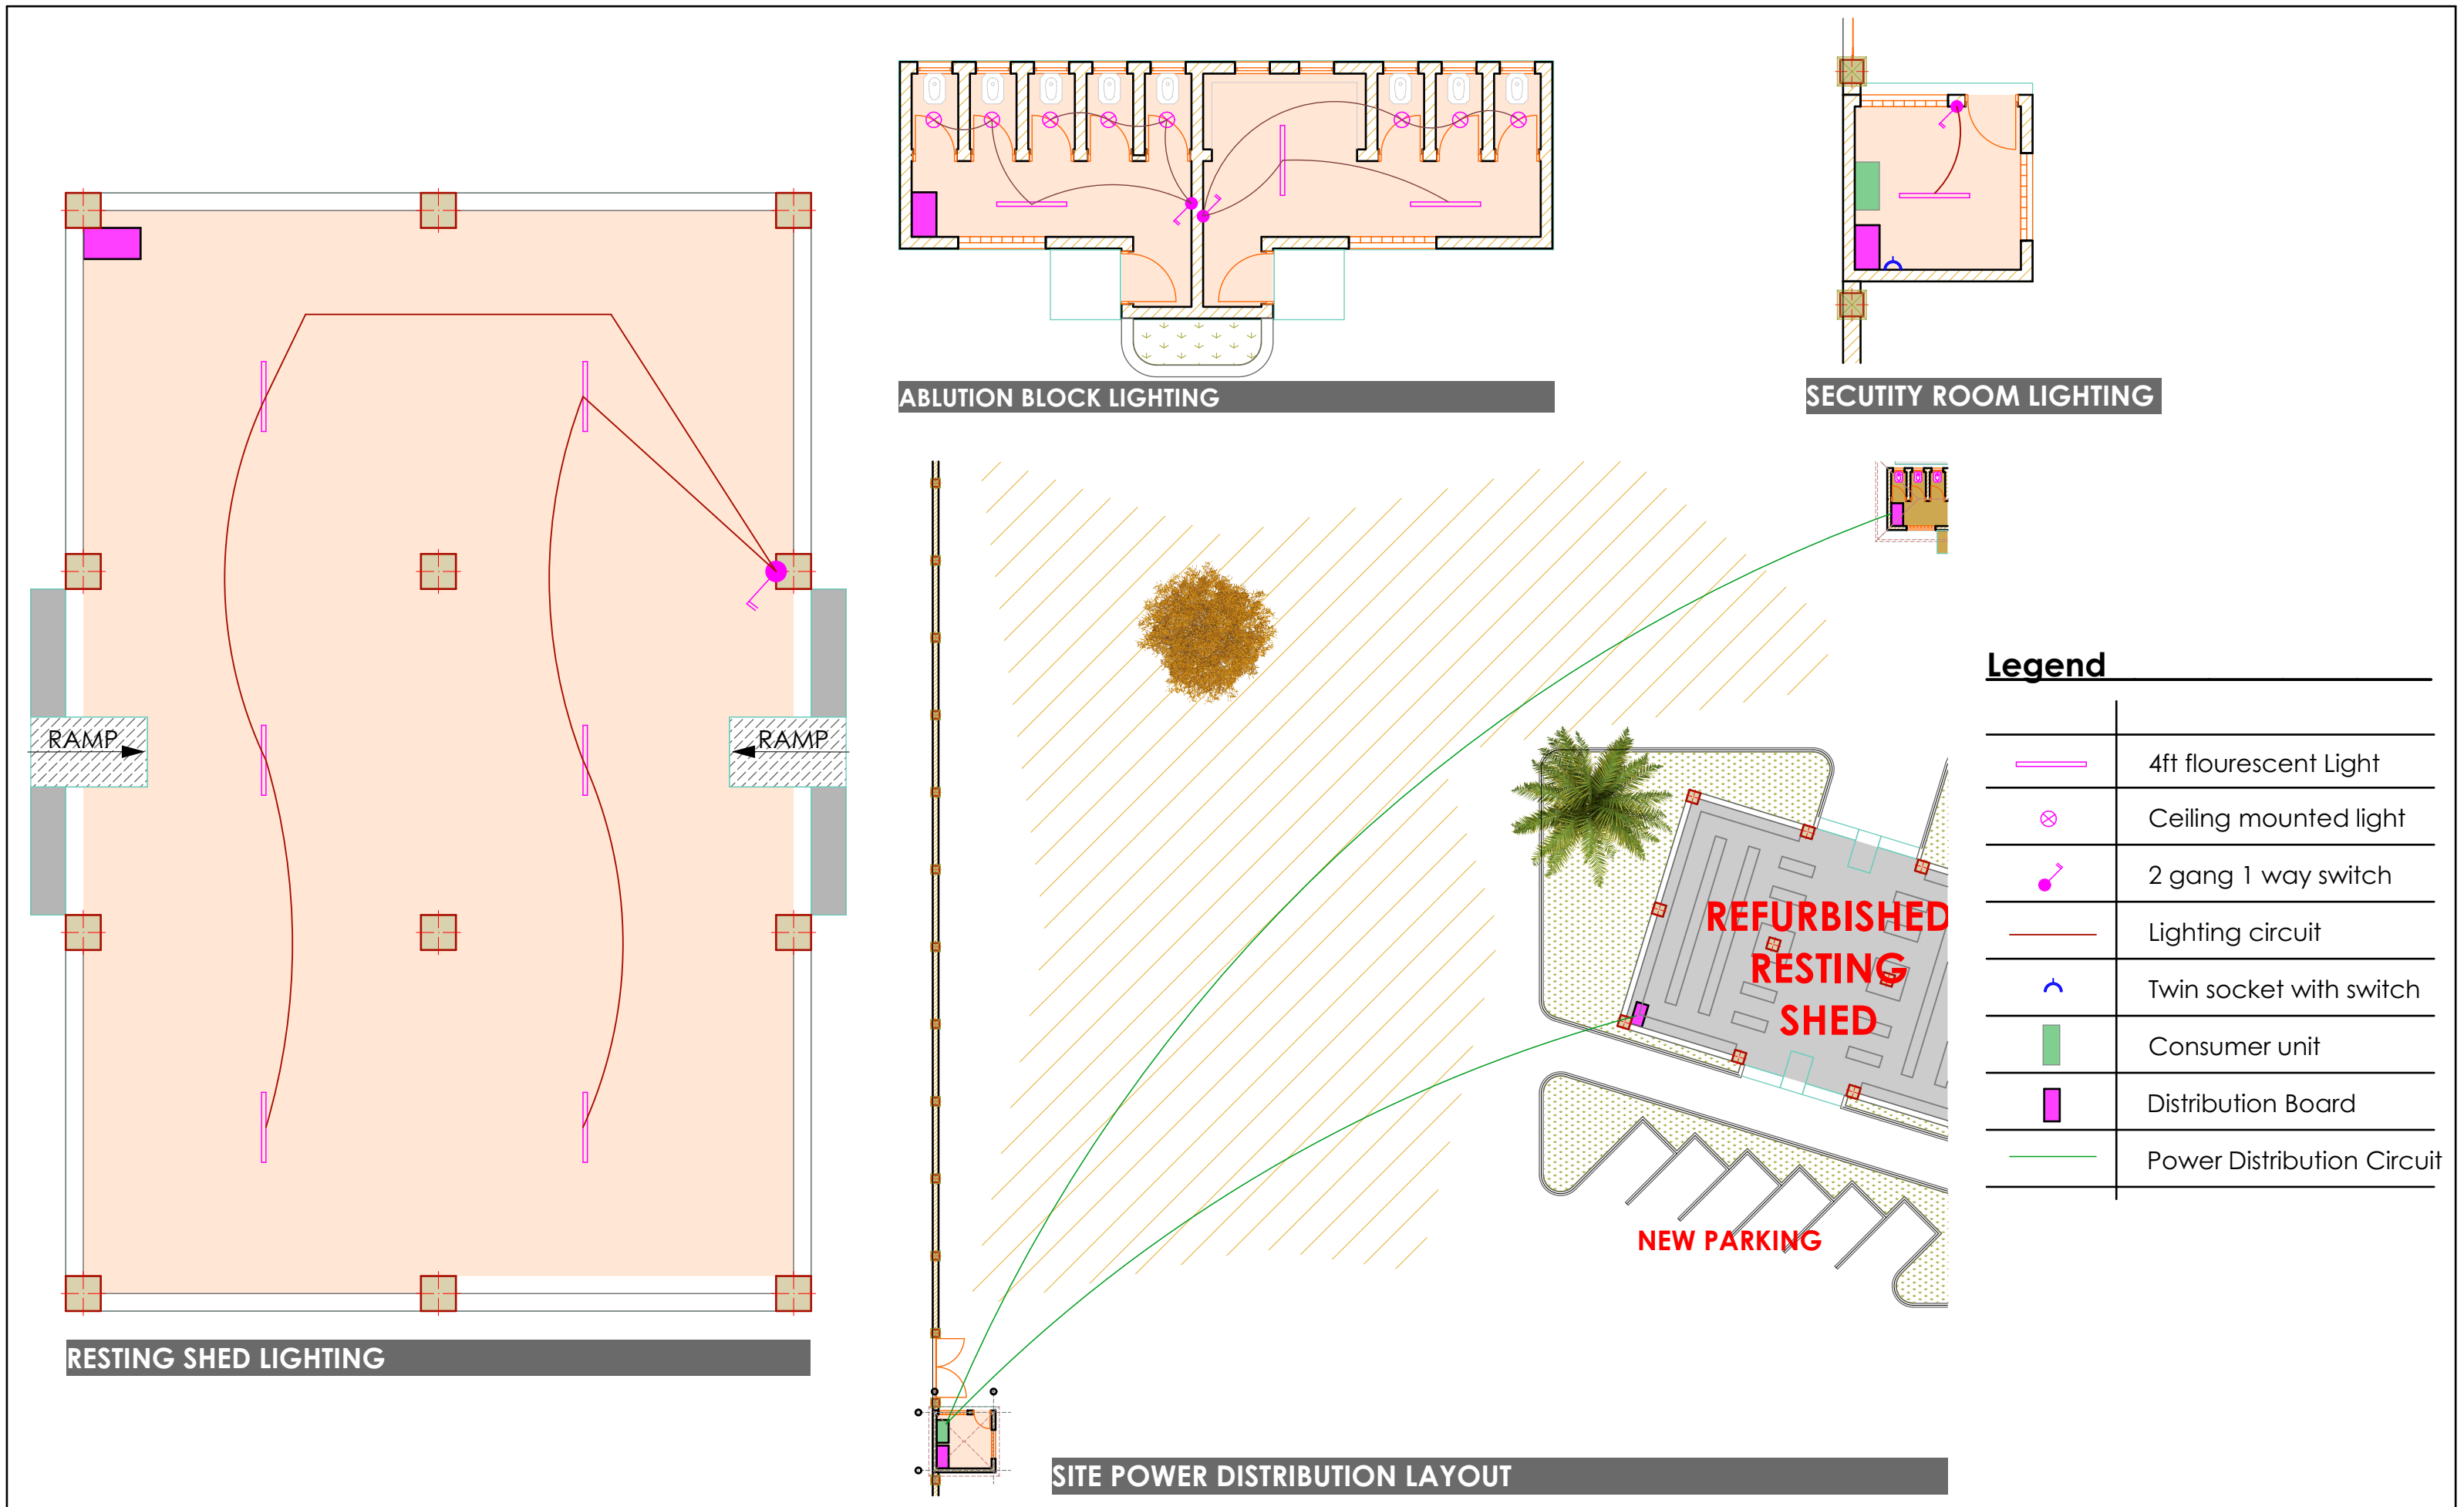ARCHITECTURAL DRAWINGS



CLIENT

Jubbaland State of Somalia

PROJECT DETAILS


Project Title: REHABILITATION OF AFMADOW LIVESTOCK MARKET

IMPLEMENTING





IOM
Reintegration and Durable Solutions
(RDS) Unit

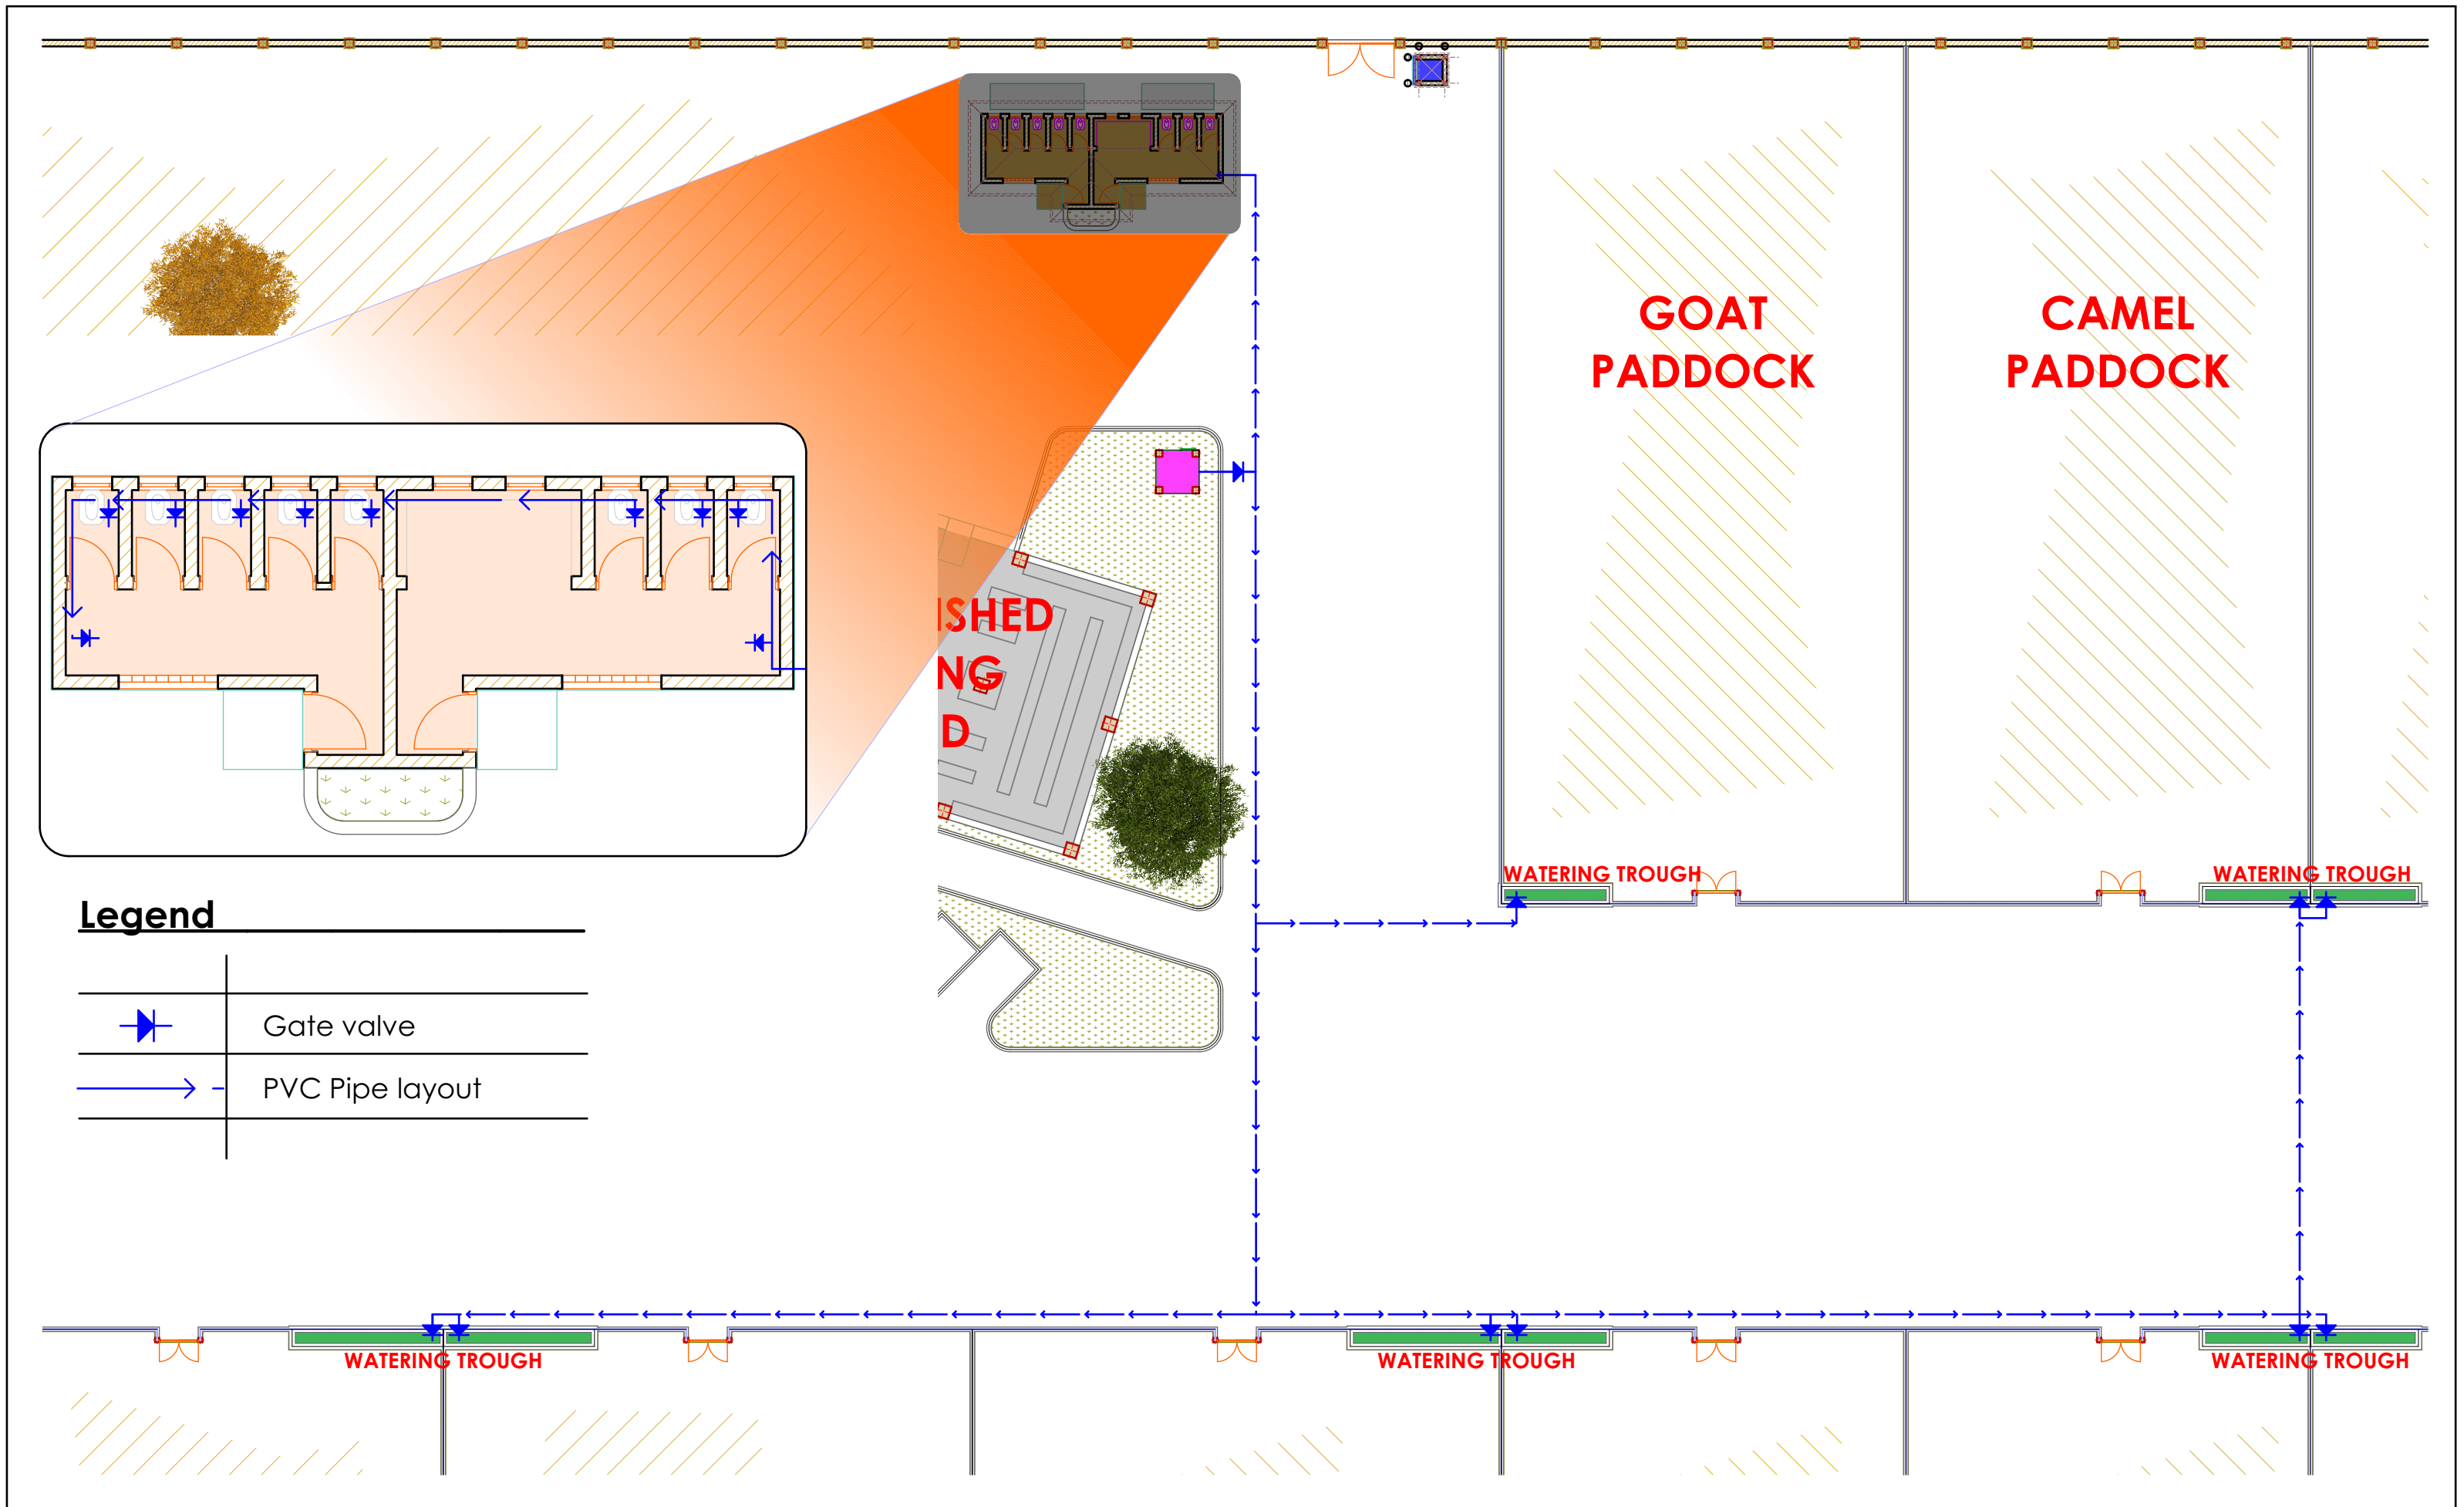Drawing Title: ELECTRICAL LAYOUT		Revision No. --	
Drawn by: D.Salah	Checked & Approved by:	Sheet No. E-01	Scale: As Shown
Date: JAN. 2019	ELECTRICAL DRAWINGS		



CLIENT

Jubbaland State of Somalia

PROJECT DETAILS




Project Title: REHABILITATION OF AFMADOW LIVESTOCK MARKET

IMPLEMENTING



IOM
Reintegration and Durable Solutions
(RDS) Unit

Drawing Title: PLUMBING LAYOUT		Revision No. --	
Drawn by: D.Salah	Checked & Approved by:	Sheet No. M-01	Scale: As Shown
Date: JAN. 2019	MECHANICAL DRAWINGS		

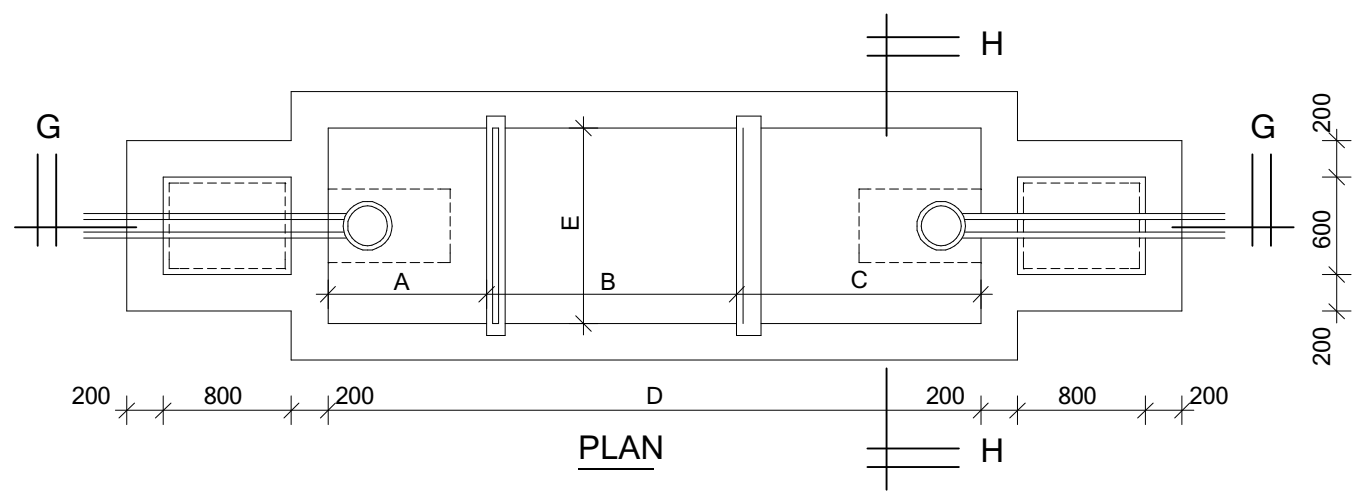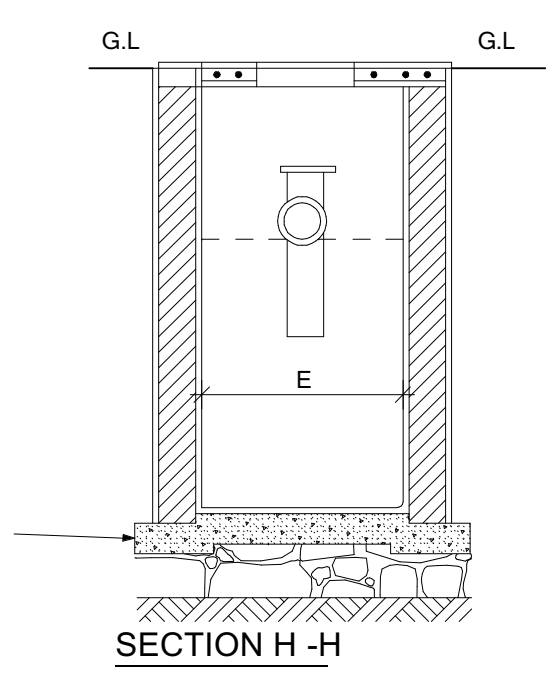
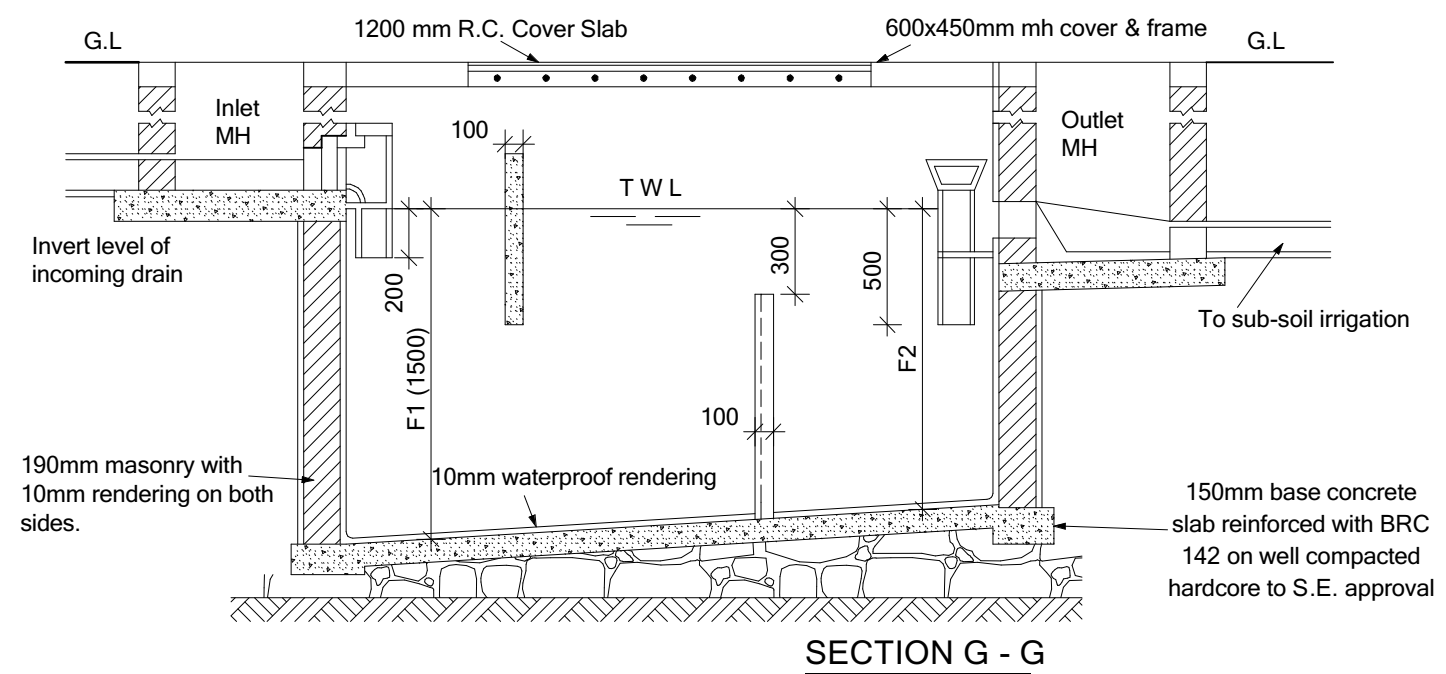


NOTES

- Cover slab to be reinforced with 10mm dia. bar at 100mm c/c (conc. 20 / 20 mix 1:2:4)
- Base slab to be conc. class mix 1:3:6
- Outlet and inlet pipes to be 100mm dia. cast iron.
- Scum baffle to be 100mm thick reinforced with 2 No. 100mm at both ends conc 80(20)
- Dividing wall to be 100mm thick conc. class 20(20) reinforced with weld mesh No. 65.

TYPE	CAPACITY IN LITRES	No. OF PERSONS	DESLUDGING INTERVAL (YRS)	DIMENSIONS IN MM						
				A	B	C	D	E	F1	F2
A	3000	10	2	800	1000	1000	3000	800	1200	1400
B	6000	20	2	800	1400	1200	3600	1400	1500	1400
C	9000	30	2	800	1400	1200	3600	1800	1500	1400
D	12000	40	2	800	1600	1400	4000	2000	1500	1300
E	15000	50	2	800	1600	1400	4000	2400	1500	1200

CLIENT

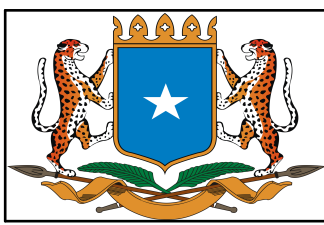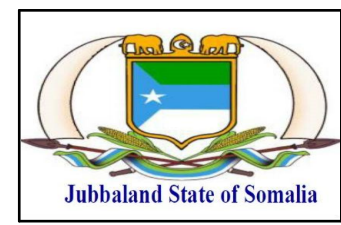Jubbaland State of Somalia

PROJECT DETAILS

Project Title: REHABILITATION OF AFMADOW LIVESTOCK MARKET

IMPLEMENTING



IOM
Reintegration and Durable Solutions
(RDS) Unit

Drawing Title: Septic tank

Revision No. --

Drawn by: D.Salah

Checked & Approved by:

Sheet No.


Scale: As Shown

Date: JAN. 2019

ARCHITECTURAL DRAWINGS




CLIENT

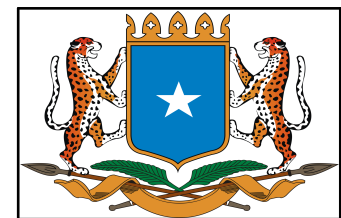

PROJECT DETAILS

Project Title:
 REHABILITATION OF AFMADOW LIVESTOCK MARKET

IMPLEMENTING

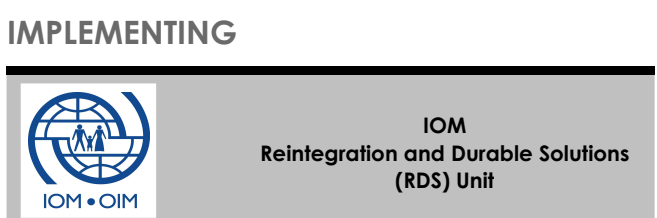

Drawing Title:

3 DIMENSIONAL PROJECTION

Revision No.

--

Drawn by:
D.Salah

Checked & Approved by:

Sheet No.
3D-01



Scale:
N/A

Date: JAN. 2019

ARCHITECTURAL DRAWINGS




CLIENT

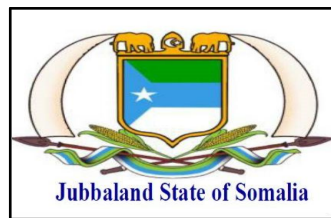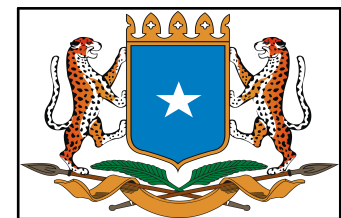

PROJECT DETAILS

Project Title:
 REHABILITATION OF AFMADOW LIVESTOCK MARKET



IMPLEMENTING

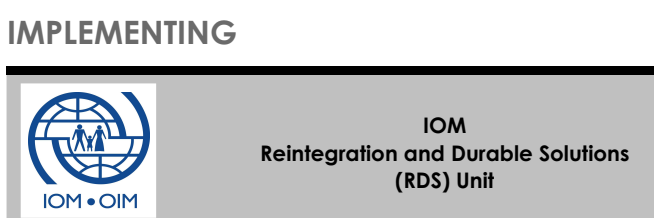

Drawing Title: 3 DIMENSIONAL PROJECTION		Revision No. --	
Drawn by: D.Salah	Checked & Approved by:	Sheet No. 3D-02	Scale: N/A
Date: JAN. 2019	ARCHITECTURAL DRAWINGS		




CLIENT

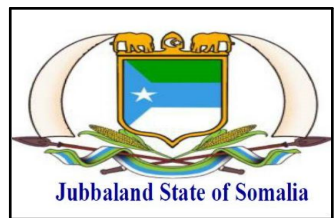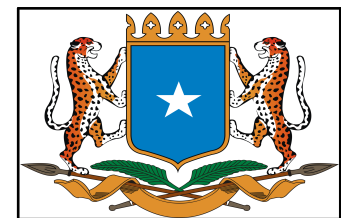

PROJECT DETAILS

Project Title:
 REHABILITATION OF AFMADOW LIVESTOCK MARKET

IMPLEMENTING

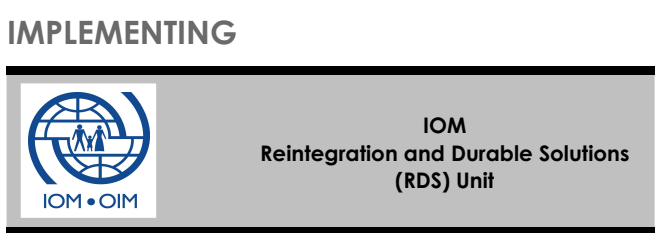

Drawing Title:
 3 DIMENSIONAL PROJECTION


Drawn by:
 D.Salah

Date: JAN. 2019



Revision No.
 --

Checked & Approved by:
 Sheet No. 3D-03
 Scale: N/A

ARCHITECTURAL DRAWINGS

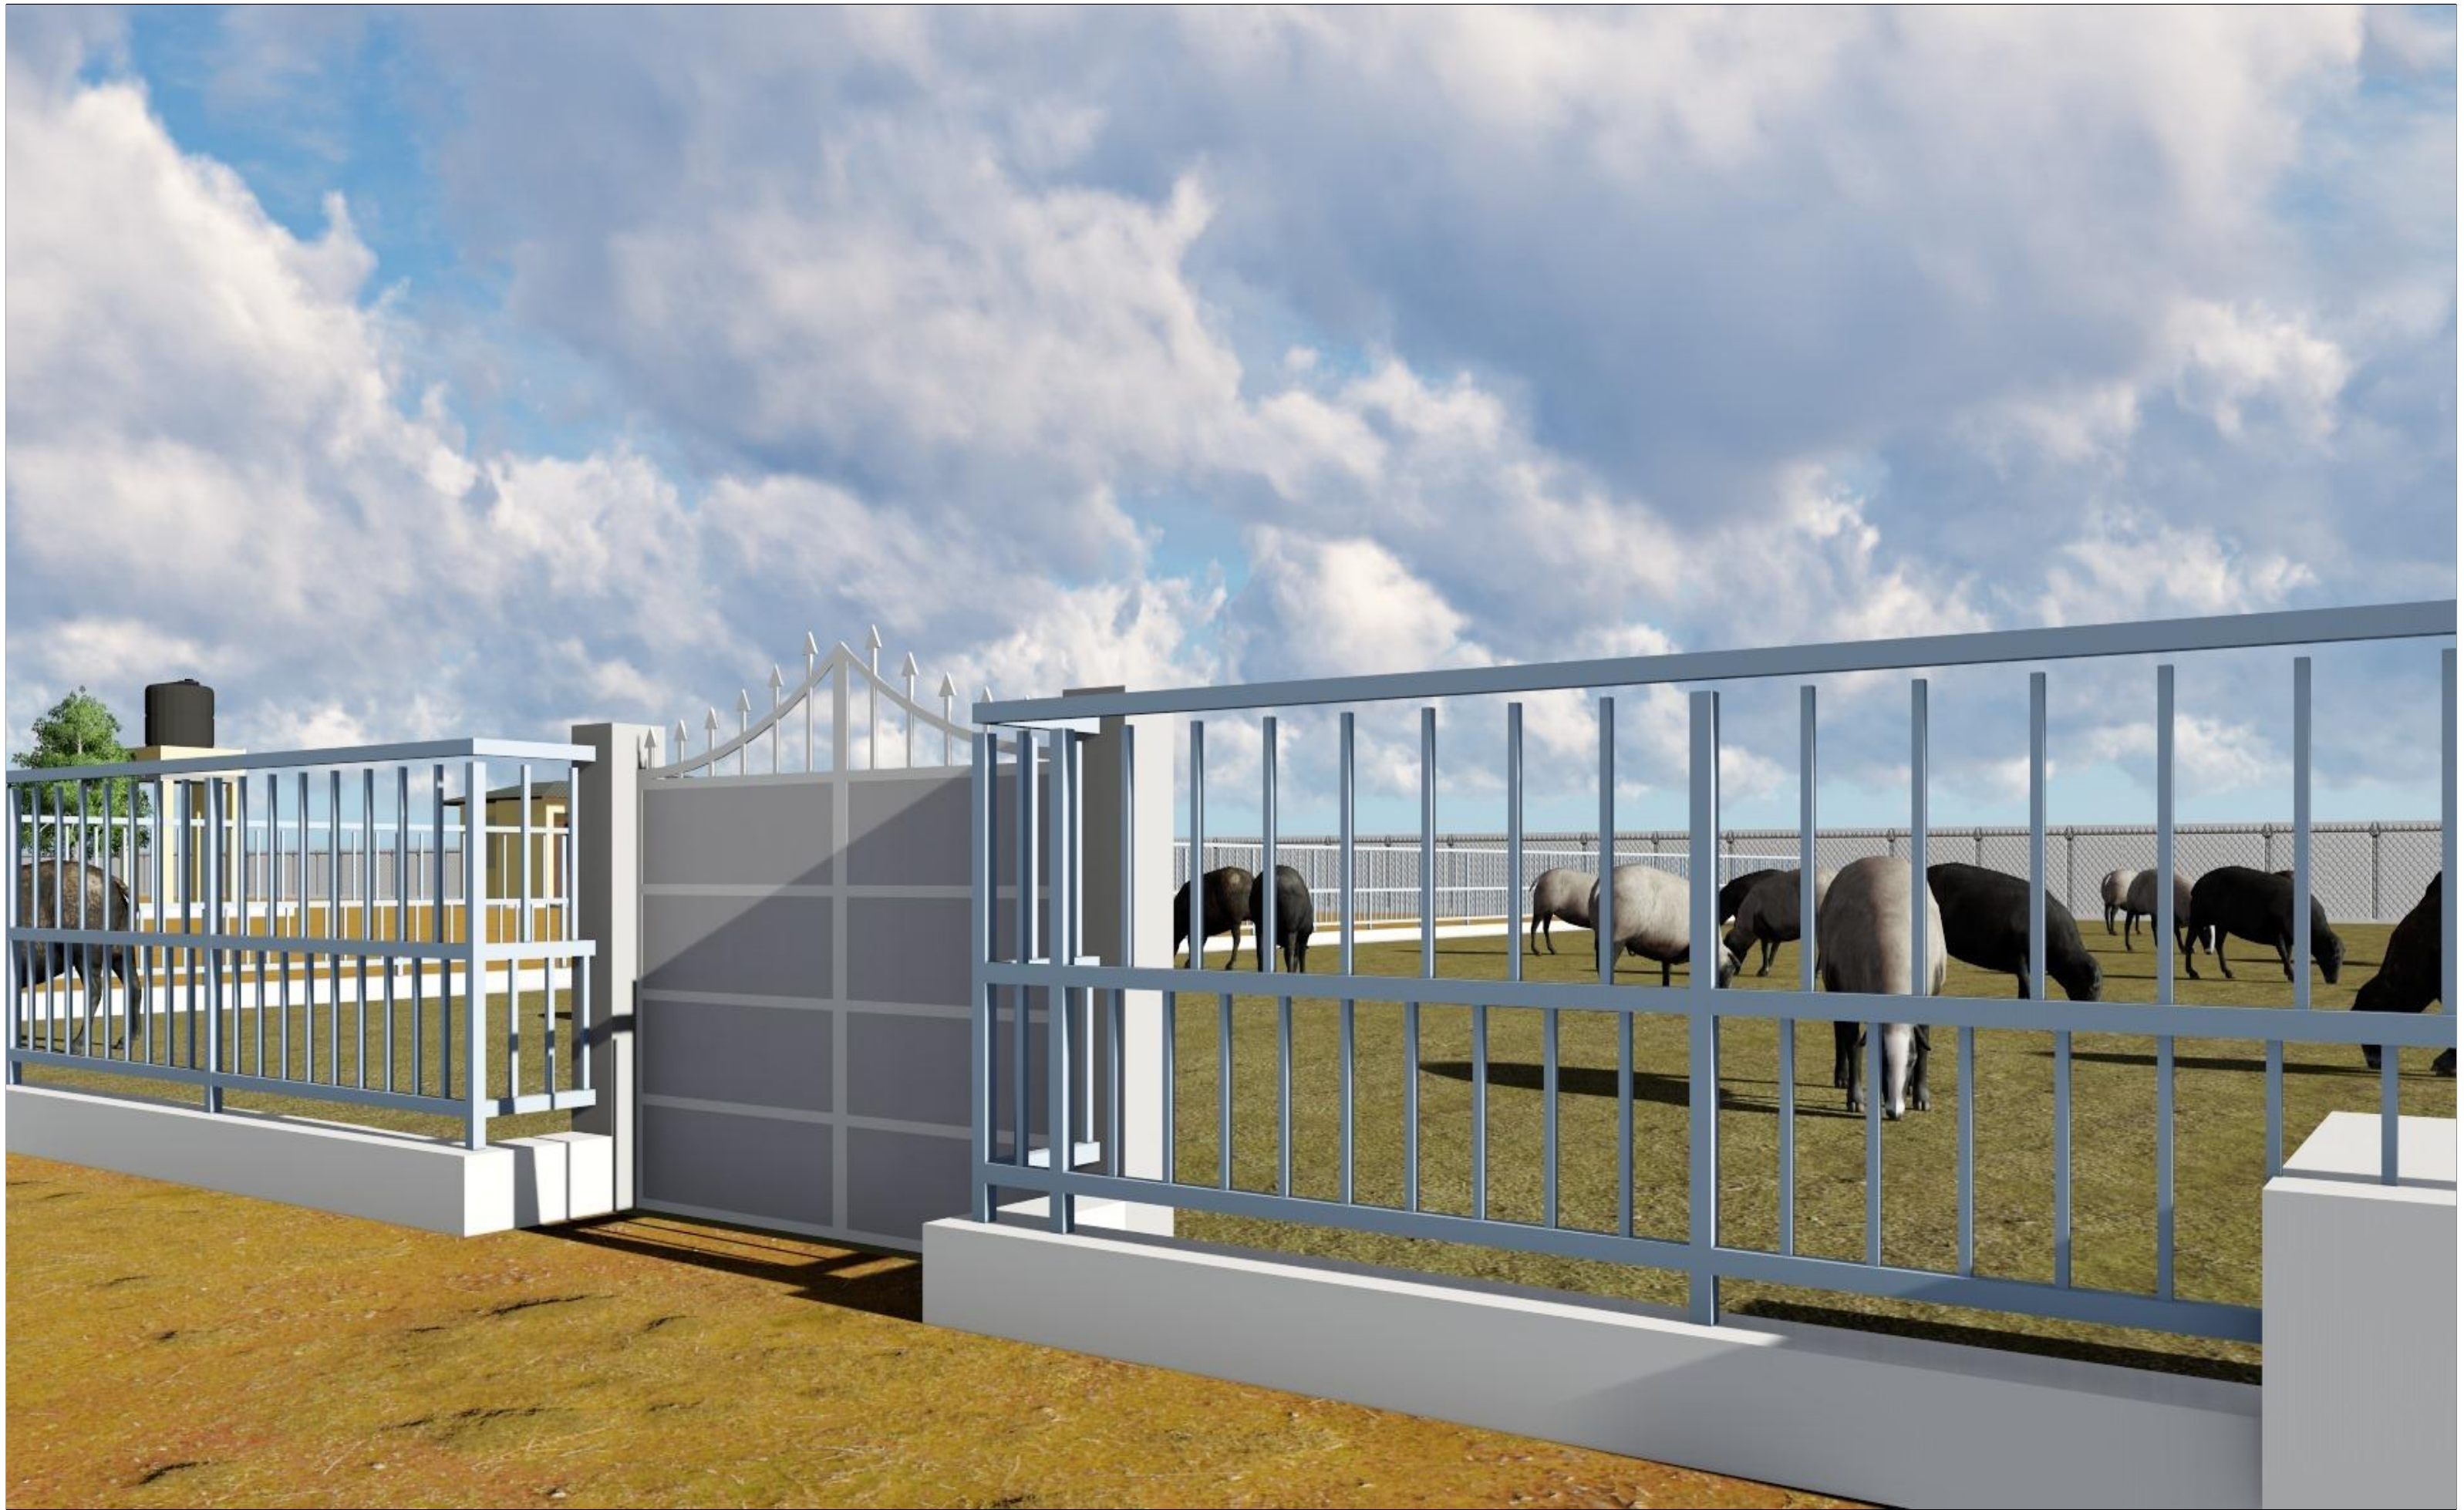

CLIENT

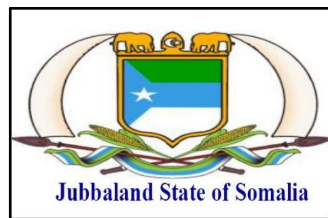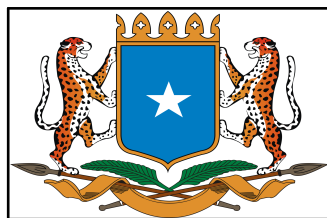

PROJECT DETAILS

Project Title:

REHABILITATION OF AFMADOW LIVESTOCK MARKET

IMPLEMENTING





IOM
Reintegration and Durable Solutions
(RDS) Unit

Drawing Title:		Revision No.	
3 DIMENSIONAL PROJECTION		--	
Drawn by:	Checked & Approved by:	Sheet No.	Scale:
D.Salah		3D-04	N/A
Date:	JAN. 2019		
ARCHITECTURAL DRAWINGS			




CLIENT

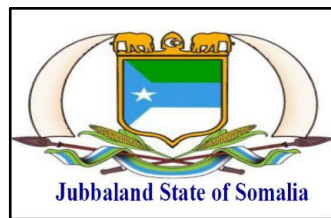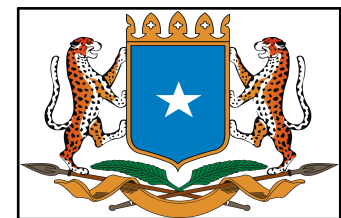

PROJECT DETAILS

Project Title:
 REHABILITATION OF AFMADOW LIVESTOCK MARKET

IMPLEMENTING

 IOM
 Reintegration and Durable Solutions
 (RDS) Unit

Drawing Title:
 3 DIMENSIONAL PROJECTION

Revision No.
 --

Drawn by:
 D.Salah

Checked & Approved by:

Sheet No.
 3D-05

Scale:
 N/A

Date: JAN. 2019

ARCHITECTURAL DRAWINGS