

PROPOSED REHABILITATION OF LAND AUTHORITY OFFICES IN
KISMAYO TOWN, JUBBALAND STATE - SOMLAIA

IOM
Recovery Durable
Solutions (RDS) Unit



NOTES

All dimensions are in mm unless stated Any discrepancies in the drawings should be reported to the consultants before the contractor commences work on site. All drawings and concepts remain the property of IOM.

Project.

Proposed REHABILITATION
OF LAND AUTHORITY OFFICES .
- KISMAYO TOWN - SOMALIA

Client:



Implemented by:



Drawing Title:

Date:

Scale:

Designed by:

Eng Abdirisak Dirie

Drawing No:

Project No:


COVER PAGE

Sheet No:

01/25

PROPOSED REHABILITATION OF LAND AUTHORITY OFFICES - KISMAYO TOWN - DRAWING INDEX

September 2019

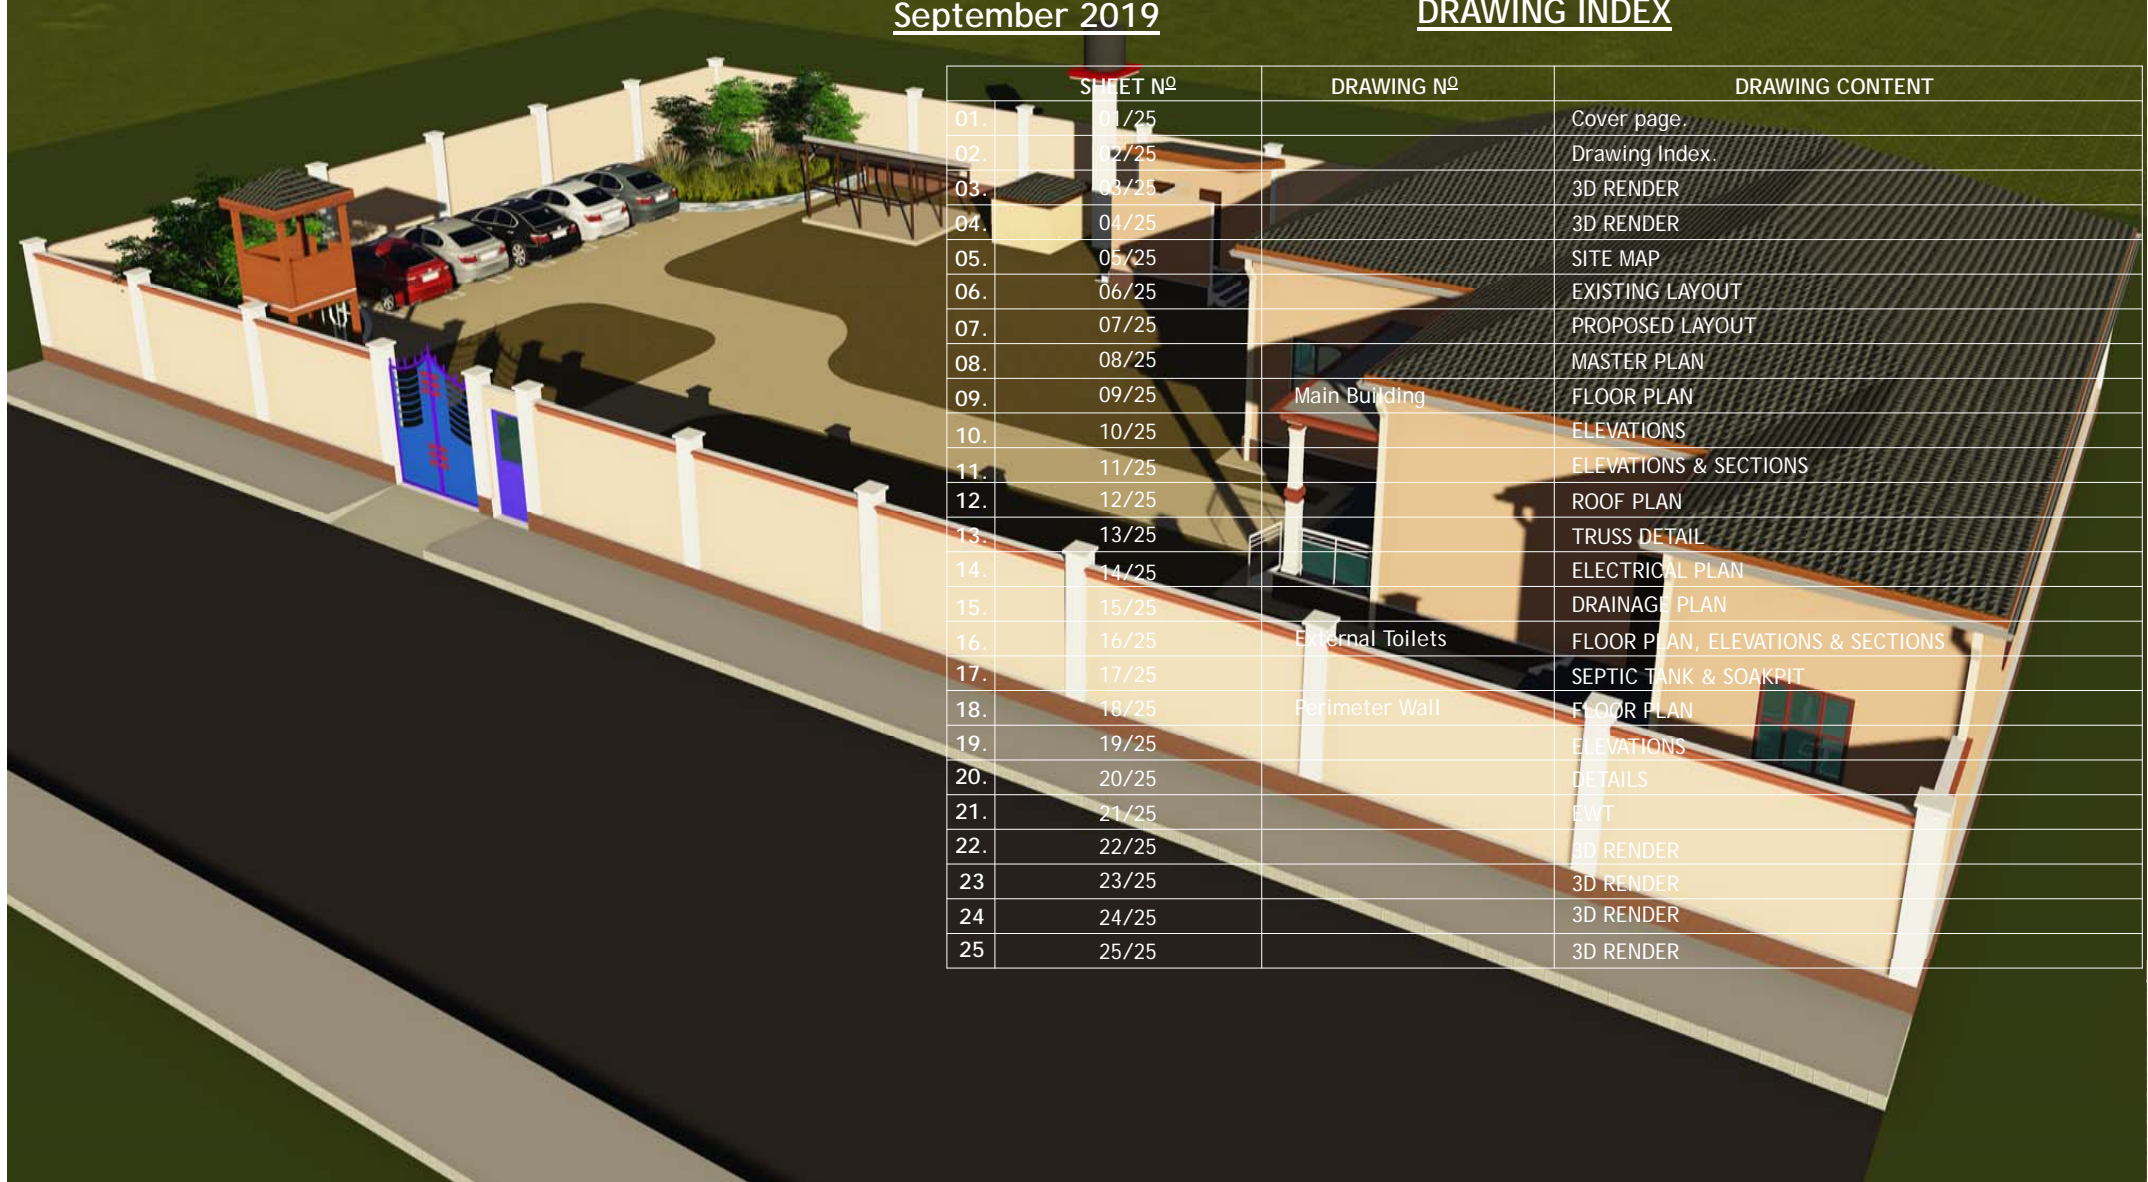

	SHEET N ^o	DRAWING N ^o	DRAWING CONTENT
01.	01/25		Cover page.
02.	02/25		Drawing Index.
03.	03/25		3D RENDER
04.	04/25		3D RENDER
05.	05/25		SITE MAP
06.	06/25		EXISTING LAYOUT
07.	07/25		PROPOSED LAYOUT
08.	08/25		MASTER PLAN
09.	09/25	Main Building	FLOOR PLAN
10.	10/25		ELEVATIONS
11.	11/25		ELEVATIONS & SECTIONS
12.	12/25		ROOF PLAN
13.	13/25		TRUSS DETAIL
14.	14/25		ELECTRICAL PLAN
15.	15/25		DRAINAGE PLAN
16.	16/25	External Toilets	FLOOR PLAN, ELEVATIONS & SECTIONS
17.	17/25		SEPTIC TANK & SOAKPIT
18.	18/25	Perimeter Wall	FLOOR PLAN
19.	19/25		ELEVATIONS
20.	20/25		DETAILS
21.	21/25		EWT
22.	22/25		3D RENDER
23.	23/25		3D RENDER
24.	24/25		3D RENDER
25.	25/25		3D RENDER

SIGNED & STAMPED:



NOTES

All dimensions are in mm unless stated Any discrepancies in the drawings should be reported to the consultants before the contractor commences work on site. All drawings and concepts remain the property of IOM.

Project.

Proposed REHABILITATION
OF LAND AUTHORITY OFFICES .
- KISMAYO TOWN - SOMALIA

Client:



Implemented by:



Drawing Title:		3D RENDER
Date:		
Scale:	-	Drawing No:
Designed by:	Eng Abdirisak Dirie	Project No:
		Sheet No:
		03/25



NOTES
 All dimensions are in mm unless stated Any discrepancies in the drawings should be reported to the consultants before the contractor commences work on site. All drawings and concepts remain the property of IOM.

Project.
 Proposed REHABILITATION
 OF LAND AUTHORITY OFFICES .
 - KISMAYO TOWN - SOMALIA

Client:



Implemented by:



Drawing Title:	
Date:	
Scale:	Drawing No:
Designed by: Eng Abdirisak Dirie	Project No:

3D RENDER
Sheet No: 04/25

Land Authority Offies - Kismayo Town

Legend

- Abutment
- Line Measure



NOTES
 All dimensions are in mm unless stated Any discrepancies in the drawings should be reported to the consultants before the contractor commences work on site.
 All drawings and concepts remain the property of IOM

Project.
Proposed LAND AUTHORITY OFFICES REHABILITATION.
- KISMAYO TOWN


COORDINATES

Latitude	0°21'55.63"S
Longitude	42° 32'52.88"E

Drawing Title:	
Date:	08/08/2019
Scale:	1:100
Designed by:	Eng. Abdirisak Dirie
Drawing No:	
Project No:	
IOM Grant No:	

SITE LOCATION

Sheet No:
05/25

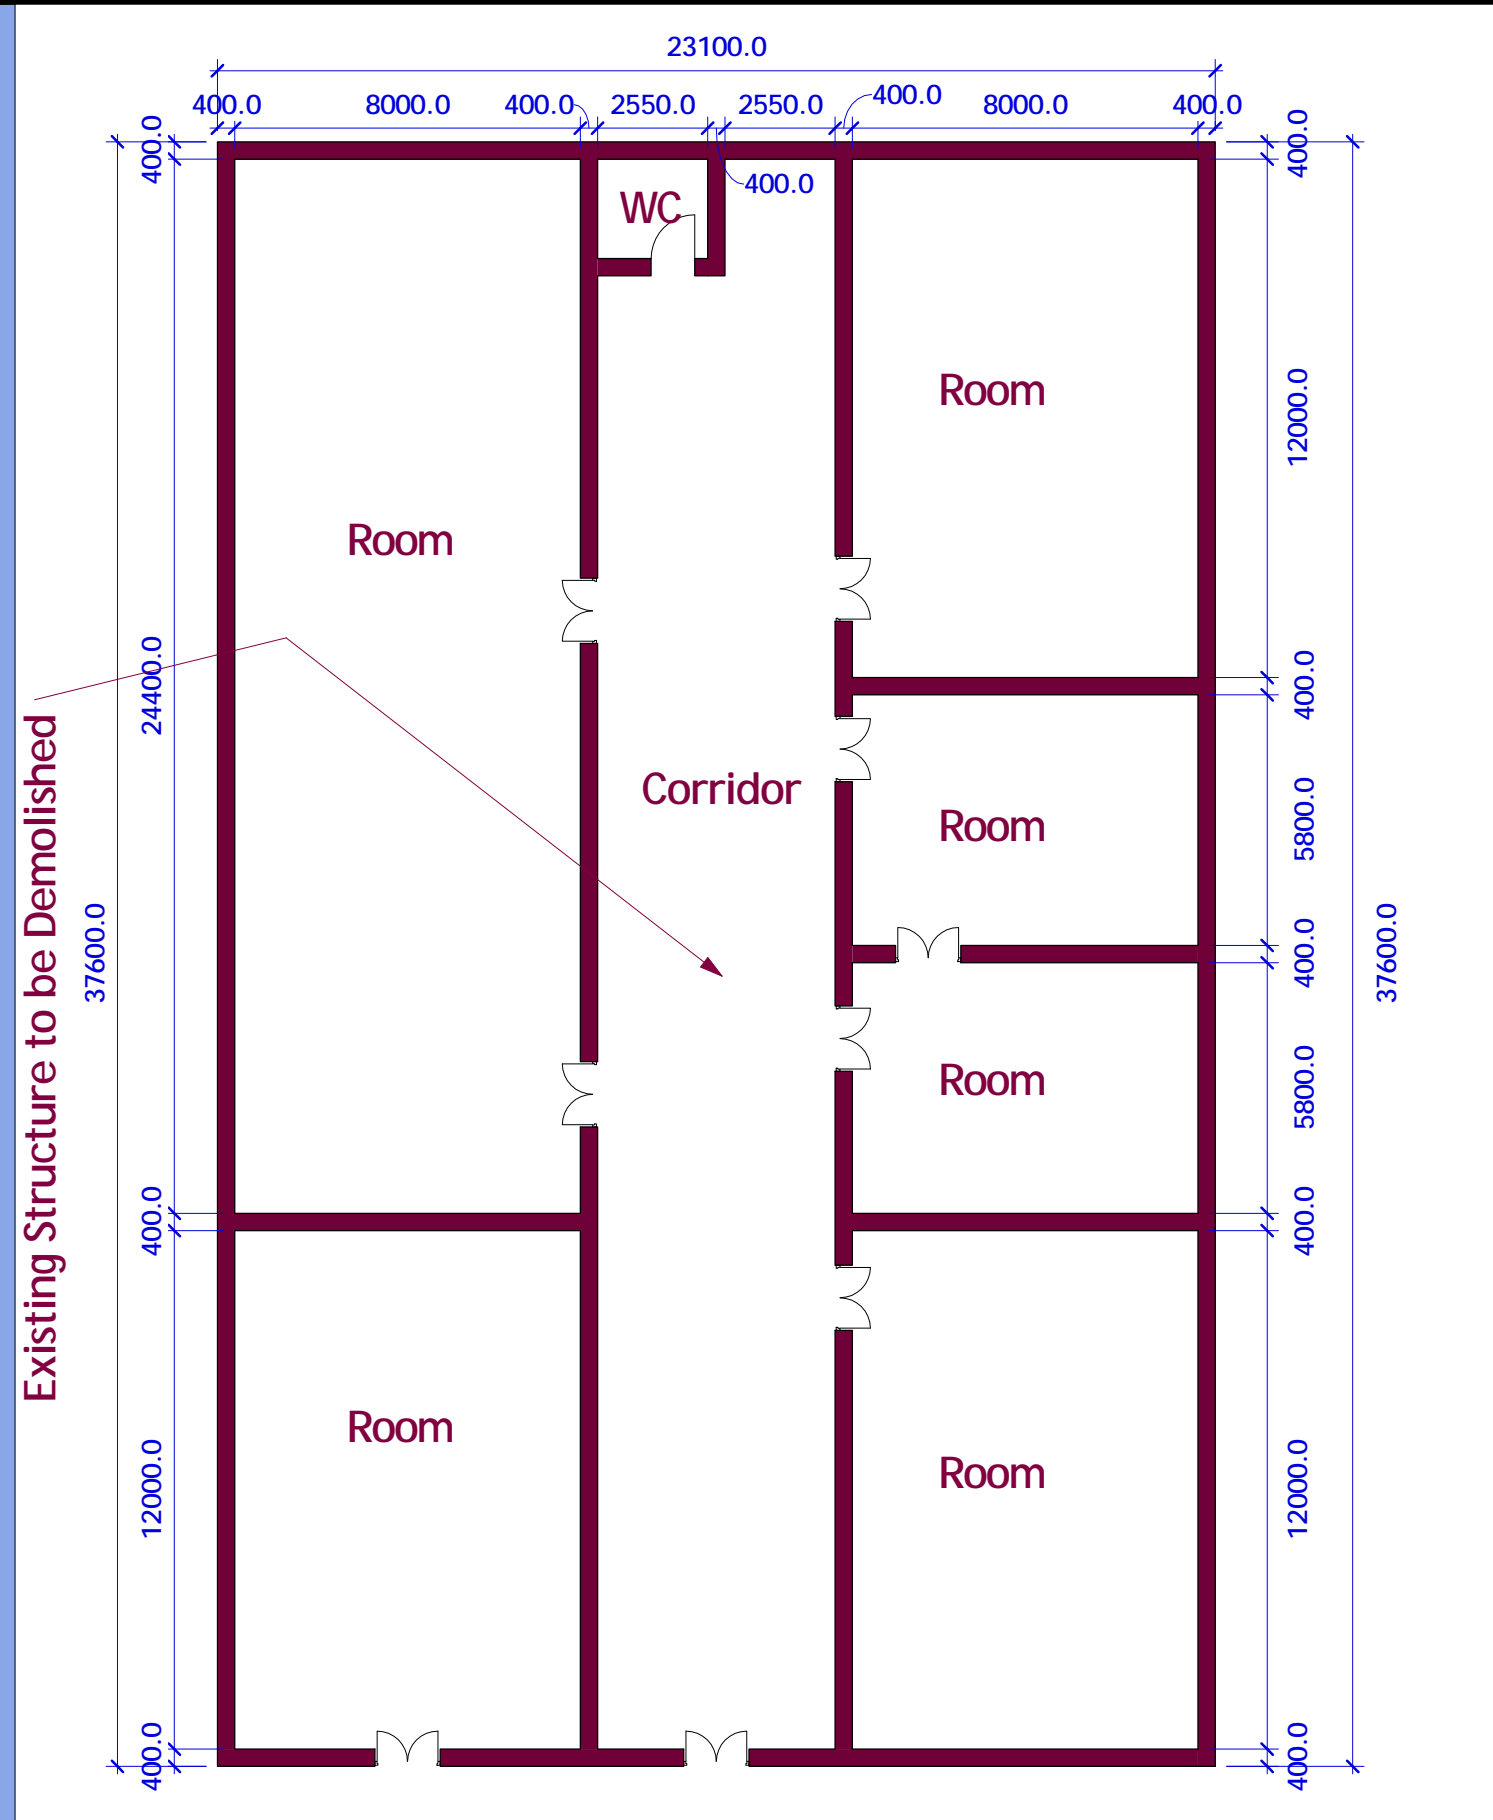


NOTES
 All dimensions are in mm unless stated Any discrepancies in the drawings should be reported to the consultants before the contractor commences work on site. All drawings and concepts remain the property of IOM.

Project.
 Proposed REHABILITATION
 OF LAND AUTHORITY OFFICES .
 - KISMAYO TOWN - SOMALIA



Drawing Title:		EXISTING LAYOUT
Date:		
Scale:	Drawing No:	sheet No: 06/23
Designed by: Eng Abdirisak Dirie	Project No:	

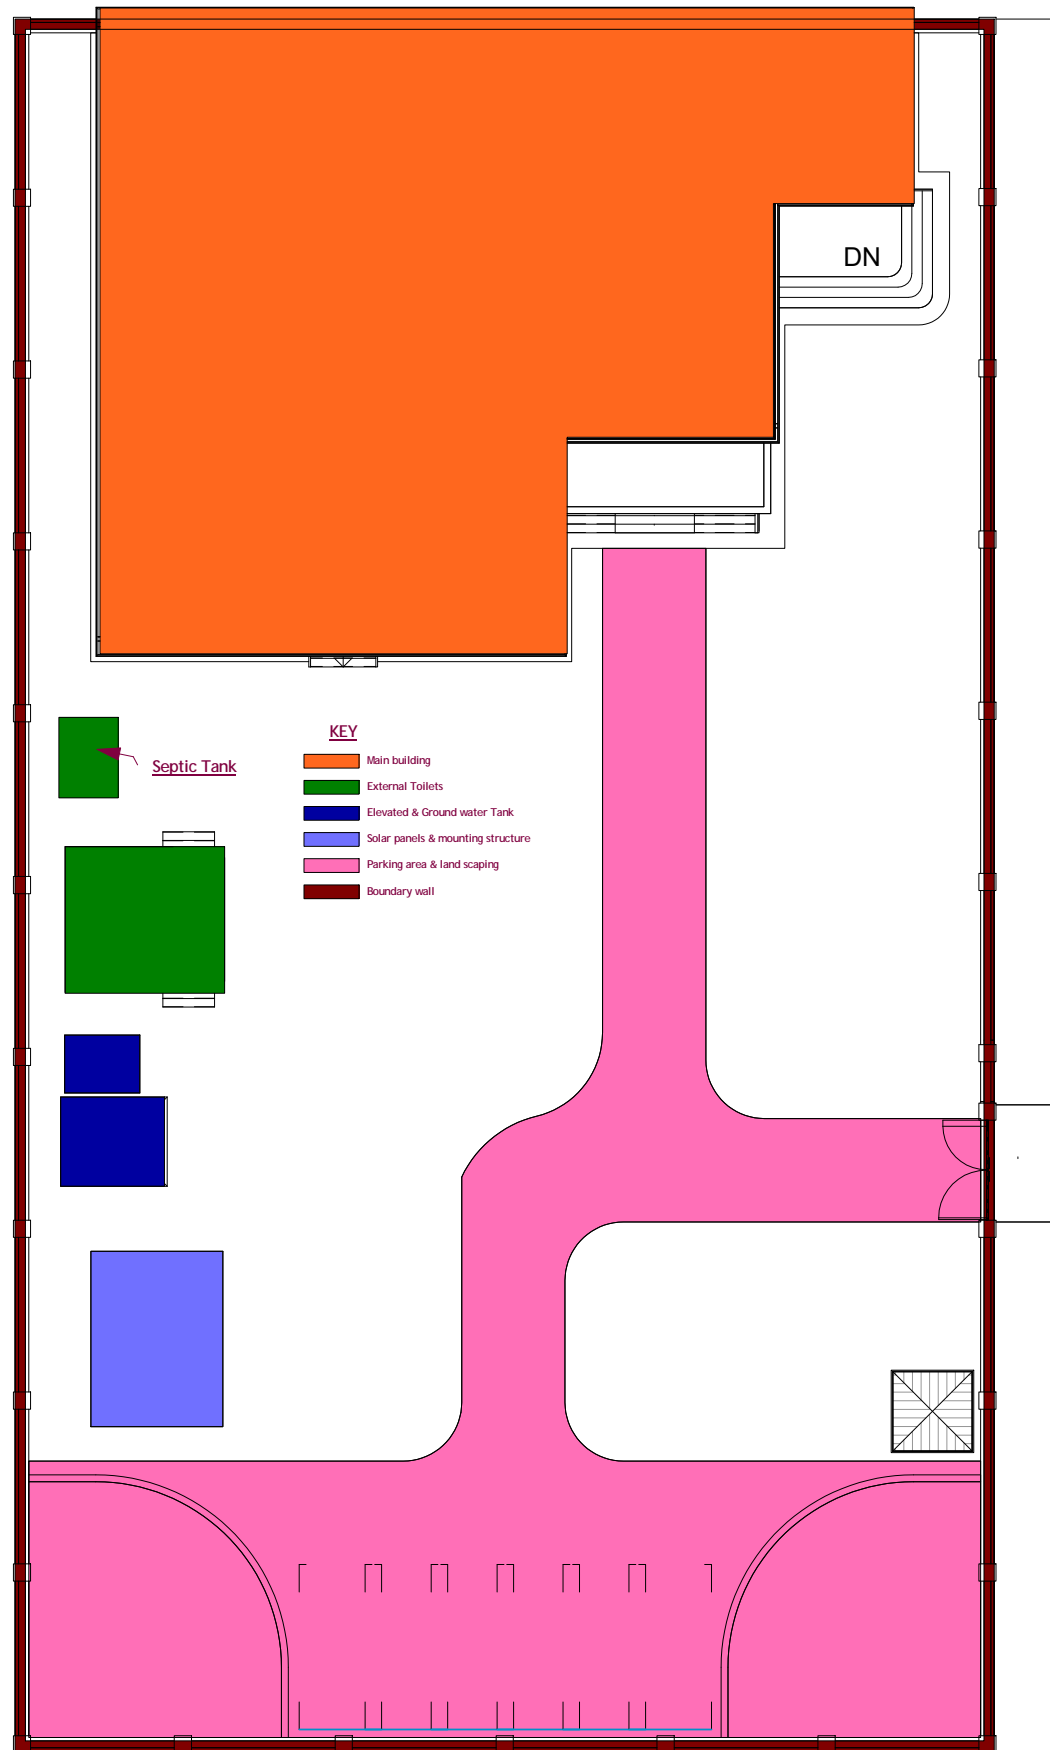

NOTES

All dimensions are in mm unless stated Any discrepancies in the drawings should be reported to the consultants before the contractor commences work on site. All drawings and concepts remain the property of IOM.

Project.

Proposed REHABILITATION OF LAND AUTHORITY OFFICES . - KISMAYO TOWN - SOMALIA

Client:



Implemented by:



Drawing Title:

Date:

Scale:

Designed by:

Eng Abdirisak Dirie


Drawing No:

Project No:

PROPOSED LAYOUT

sheet No:

07/25

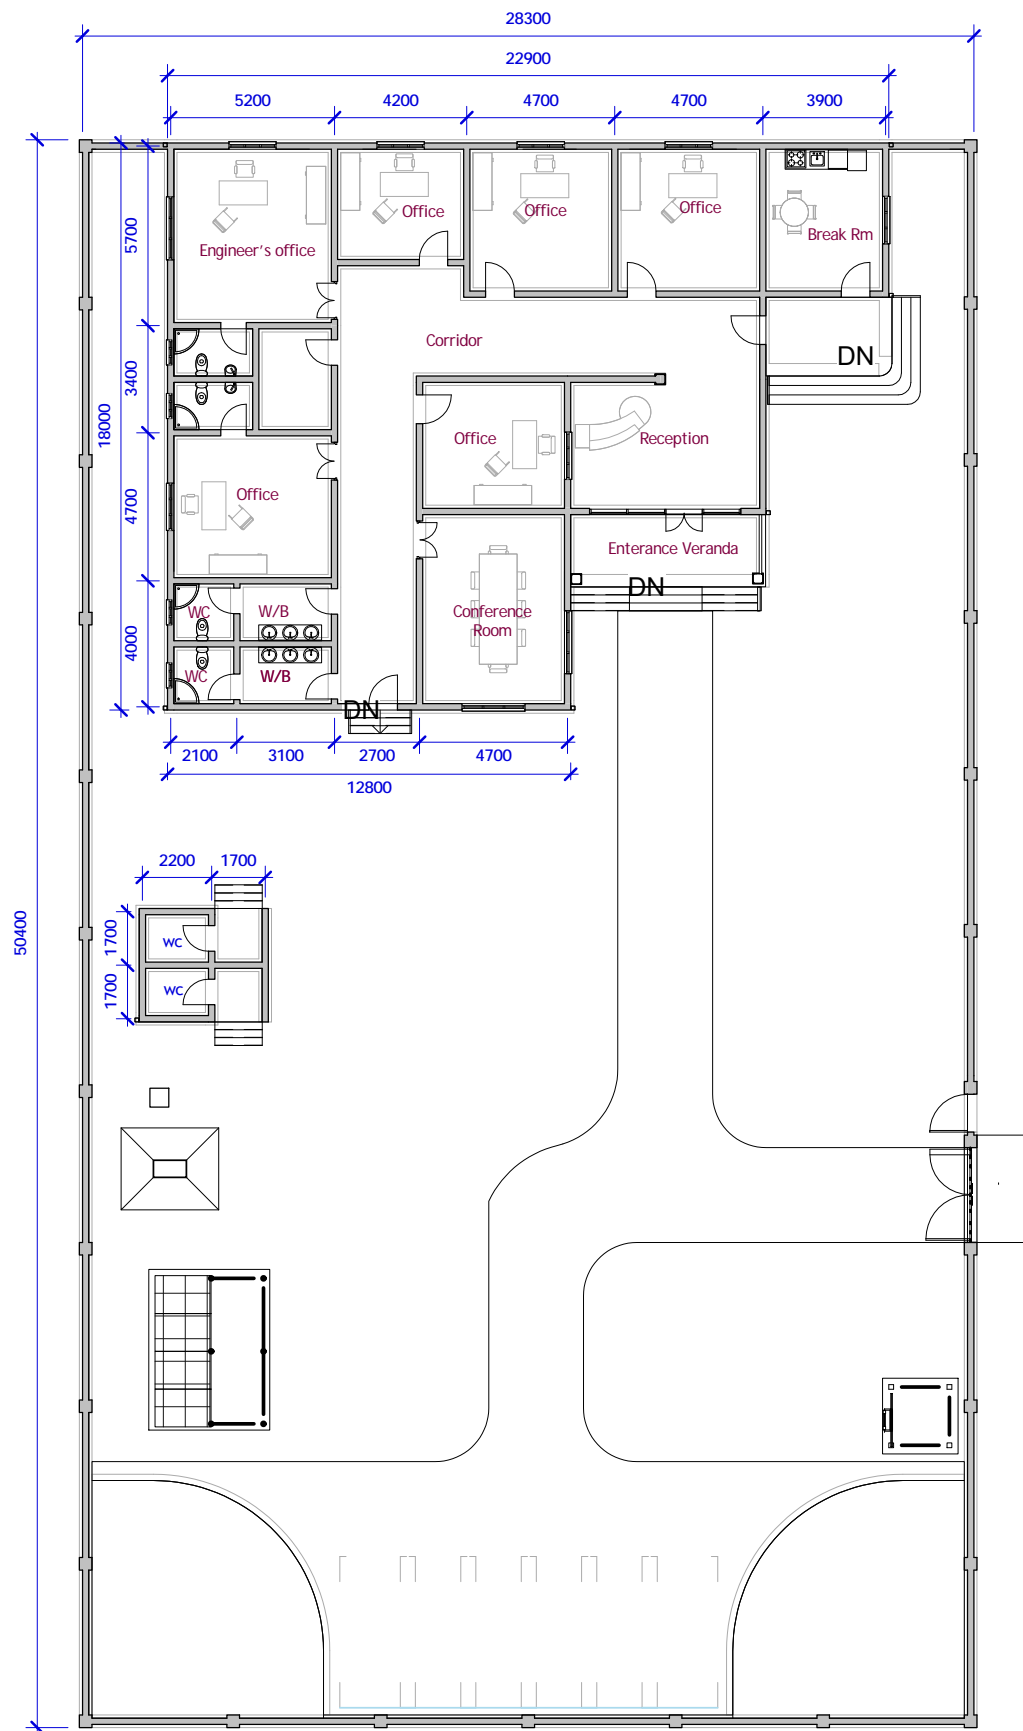

NOTES

All dimensions are in mm unless stated Any discrepancies in the drawings should be reported to the consultants before the contractor commences work on site. All drawings and concepts remain the property of IOM.

Project.

Proposed REHABILITATION OF LAND AUTHORITY OFFICES .
- KISMAYO TOWN - SOMALIA

Client:



Implemented by:



Drawing Title:		MASTER PLAN
Date:		
Scale:	Drawing No:	sheet No: 08/25
Designed by: Eng Abdirisak Dirie	Project No:	



NOTES

All dimensions are in mm unless stated Any discrepancies in the drawings should be reported to the consultants before the contractor commences work on site. All drawings and concepts remain the property of IOM.

Project.

Proposed REHABILITATION OF LAND AUTHORITY OFFICES . - KISMAYO TOWN - SOMALIA

Client:




Implemented by:




Drawing Title:	
Date:	
Scale:	Drawing No:
Designed by: Eng Abdirisak Dirie	Project No:

FLOOR PLAN
Main Building

sheet No:
09/25

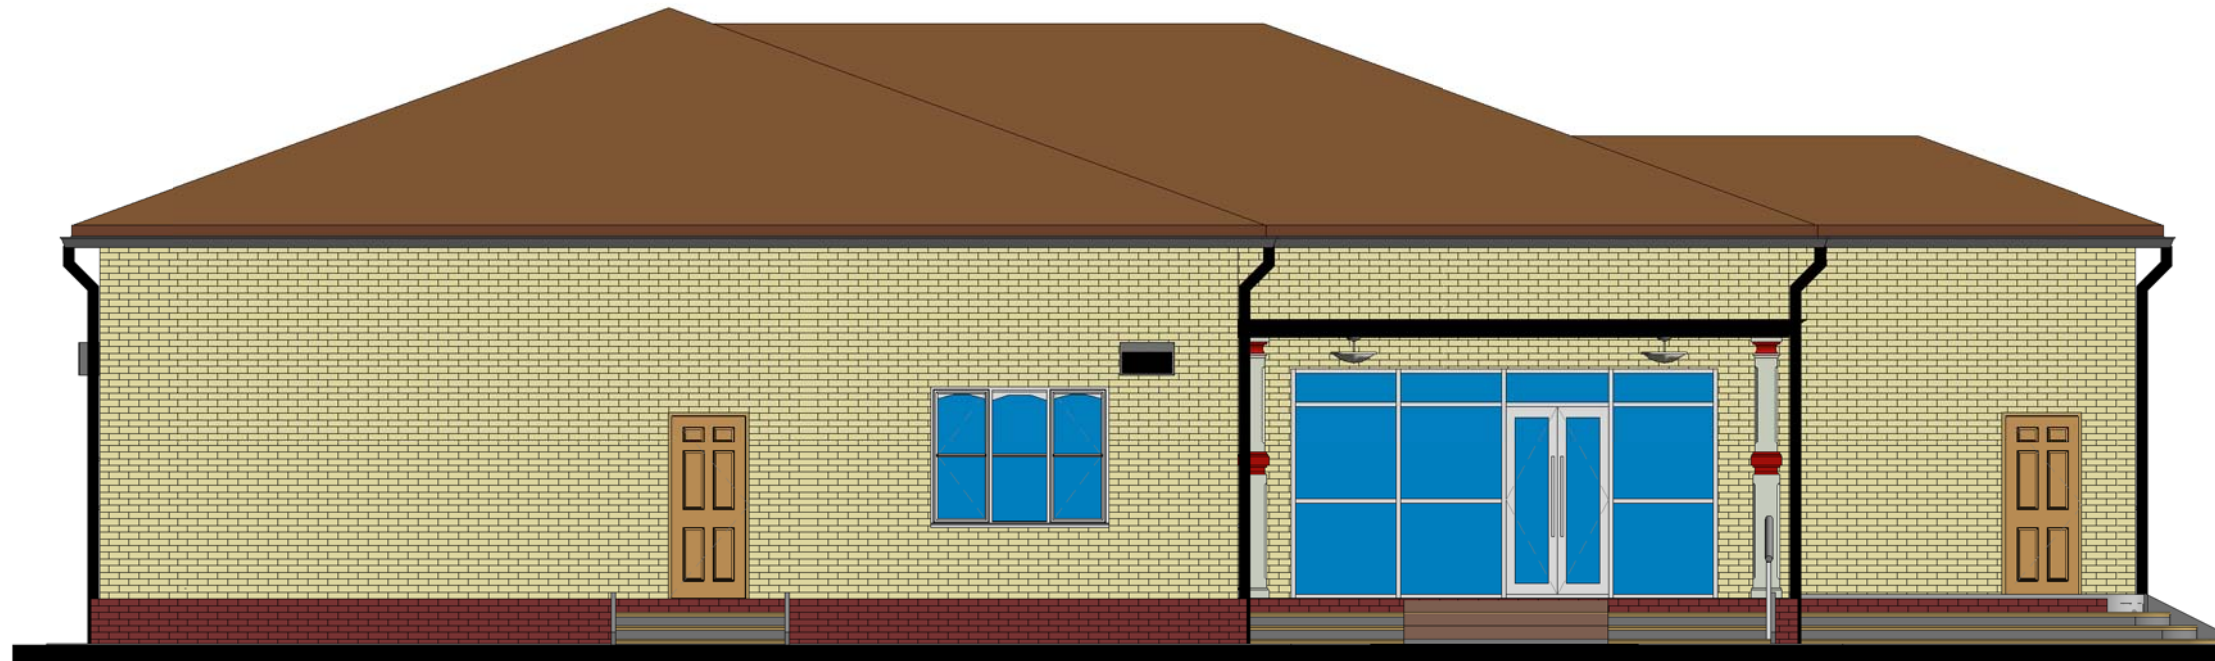

SOUTH ELEVATION

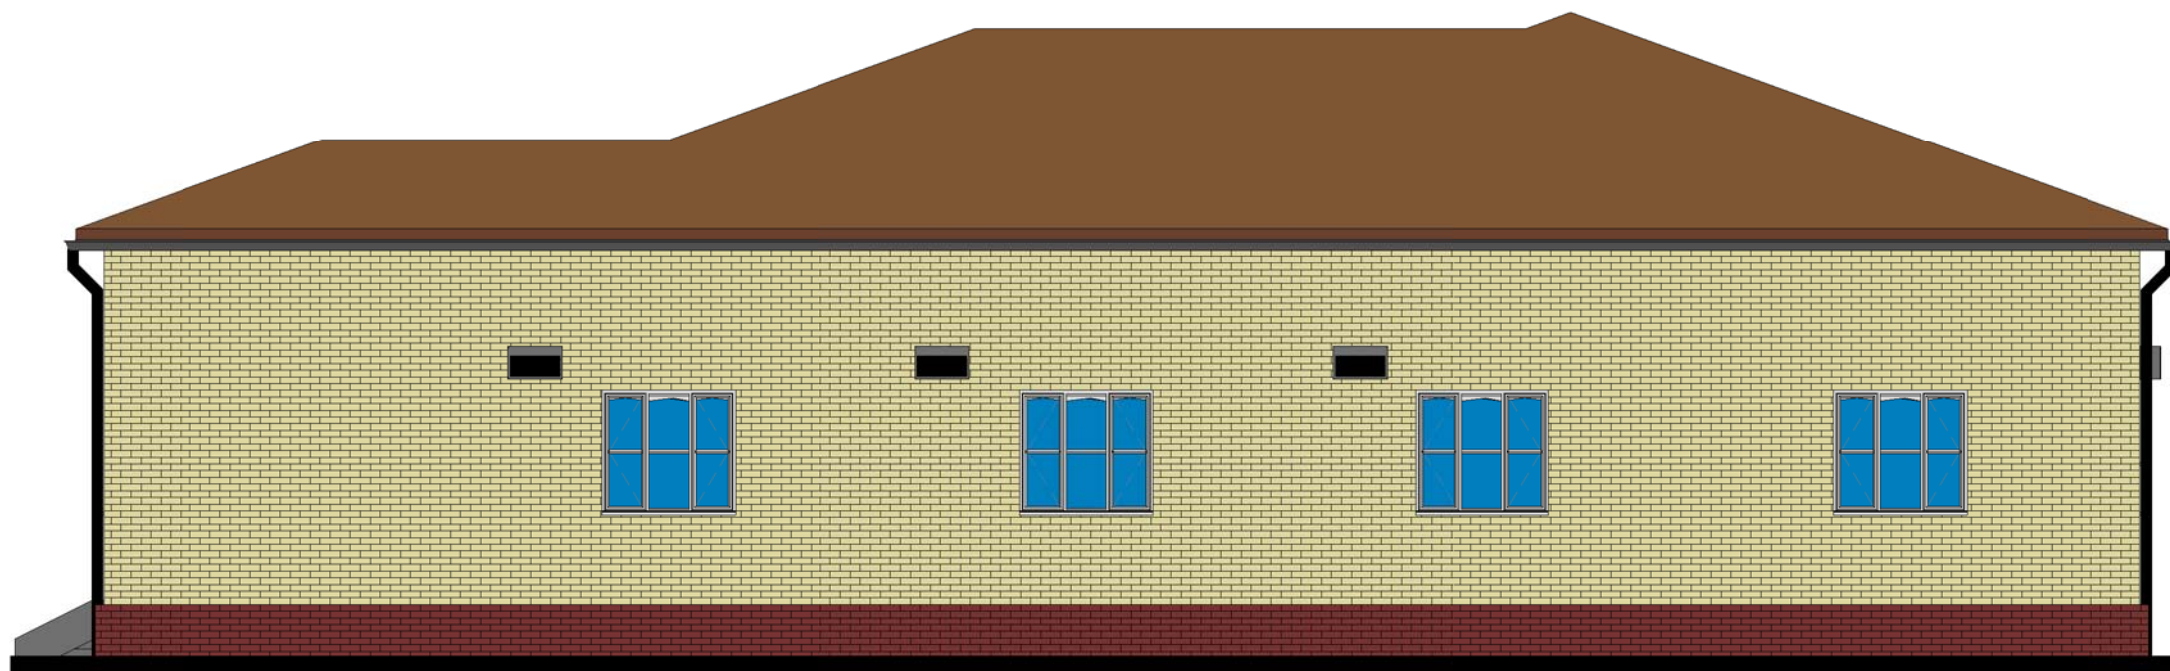

NORTH ELEVATION

NOTES

All dimensions are in mm unless stated Any discrepancies in the drawings should be reported to the consultants before the contractor commences work on site. All drawings and concepts remain the property of IOM.

Project.

Proposed REHABILITATION
OF LAND AUTHORITY OFFICES .
- KISMAYO TOWN - SOMALIA

Client:



Implemented by:



Drawing Title:

Date:

Scale:

Designed by:

Eng Abdirisak Dirie


Drawing No:

Project No:

**ELEVATIONS
Main Building**

sheet No:


10/25

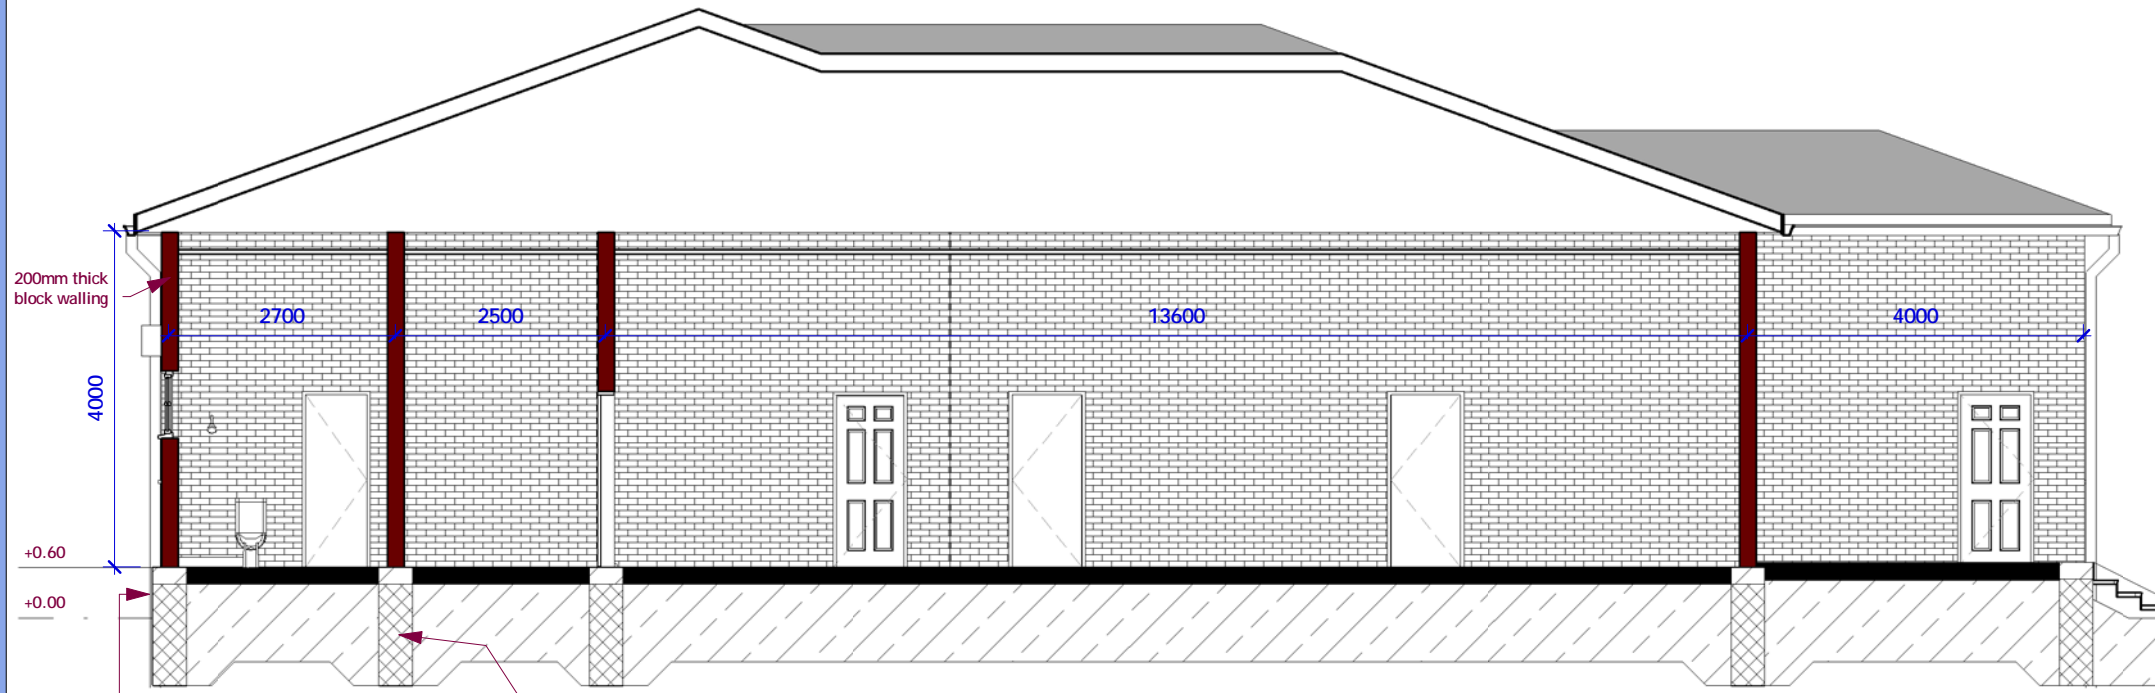


FOUNDATION SPECIFICATION
 100mm thick plain concrete slab
 40cm width foundation
 walling hardcore fill
 consolidated at 300mm level

Foundation depth to be determined on site

SECTION - 01

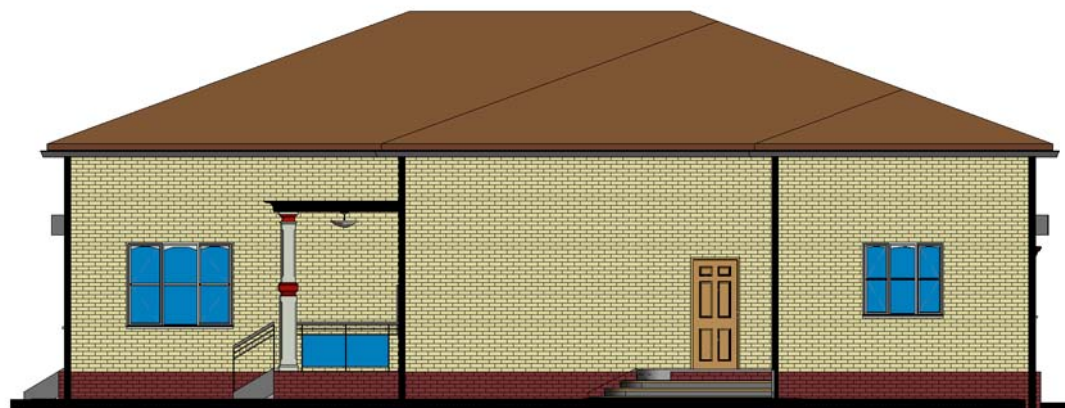

EAST ELEVATION

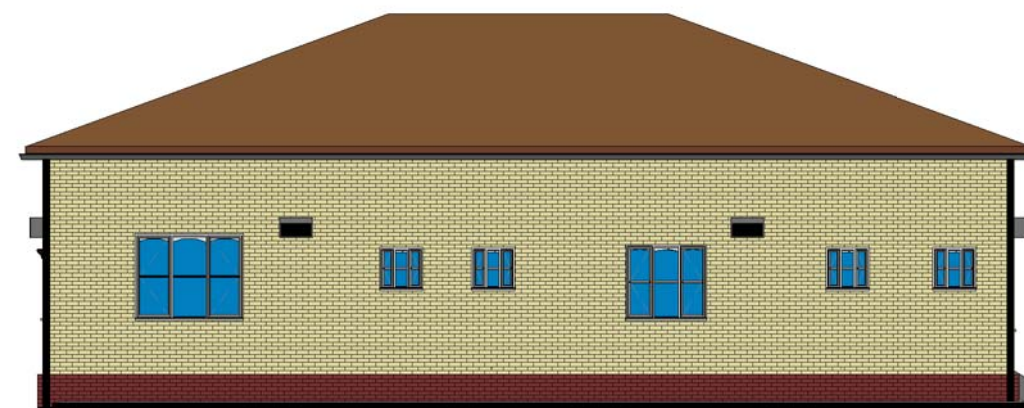

WEST ELEVATION

NOTES

All dimensions are in mm unless stated Any discrepancies in the drawings should be reported to the consultants before the contractor commences work on site. All drawings and concepts remain the property of IOM.

Project.

Proposed REHABILITATION OF LAND AUTHORITY OFFICES .
 - KISMAYO TOWN - SOMALIA


Client:



Implemented by:



Drawing Title:		SECTION & ELEVATIONS	
Date:		Main Building	
Scale:	-	Drawing No:	
Designed by:	Eng Abdirisak Dirie	Project No:	
		sheet No:	
		11/25	

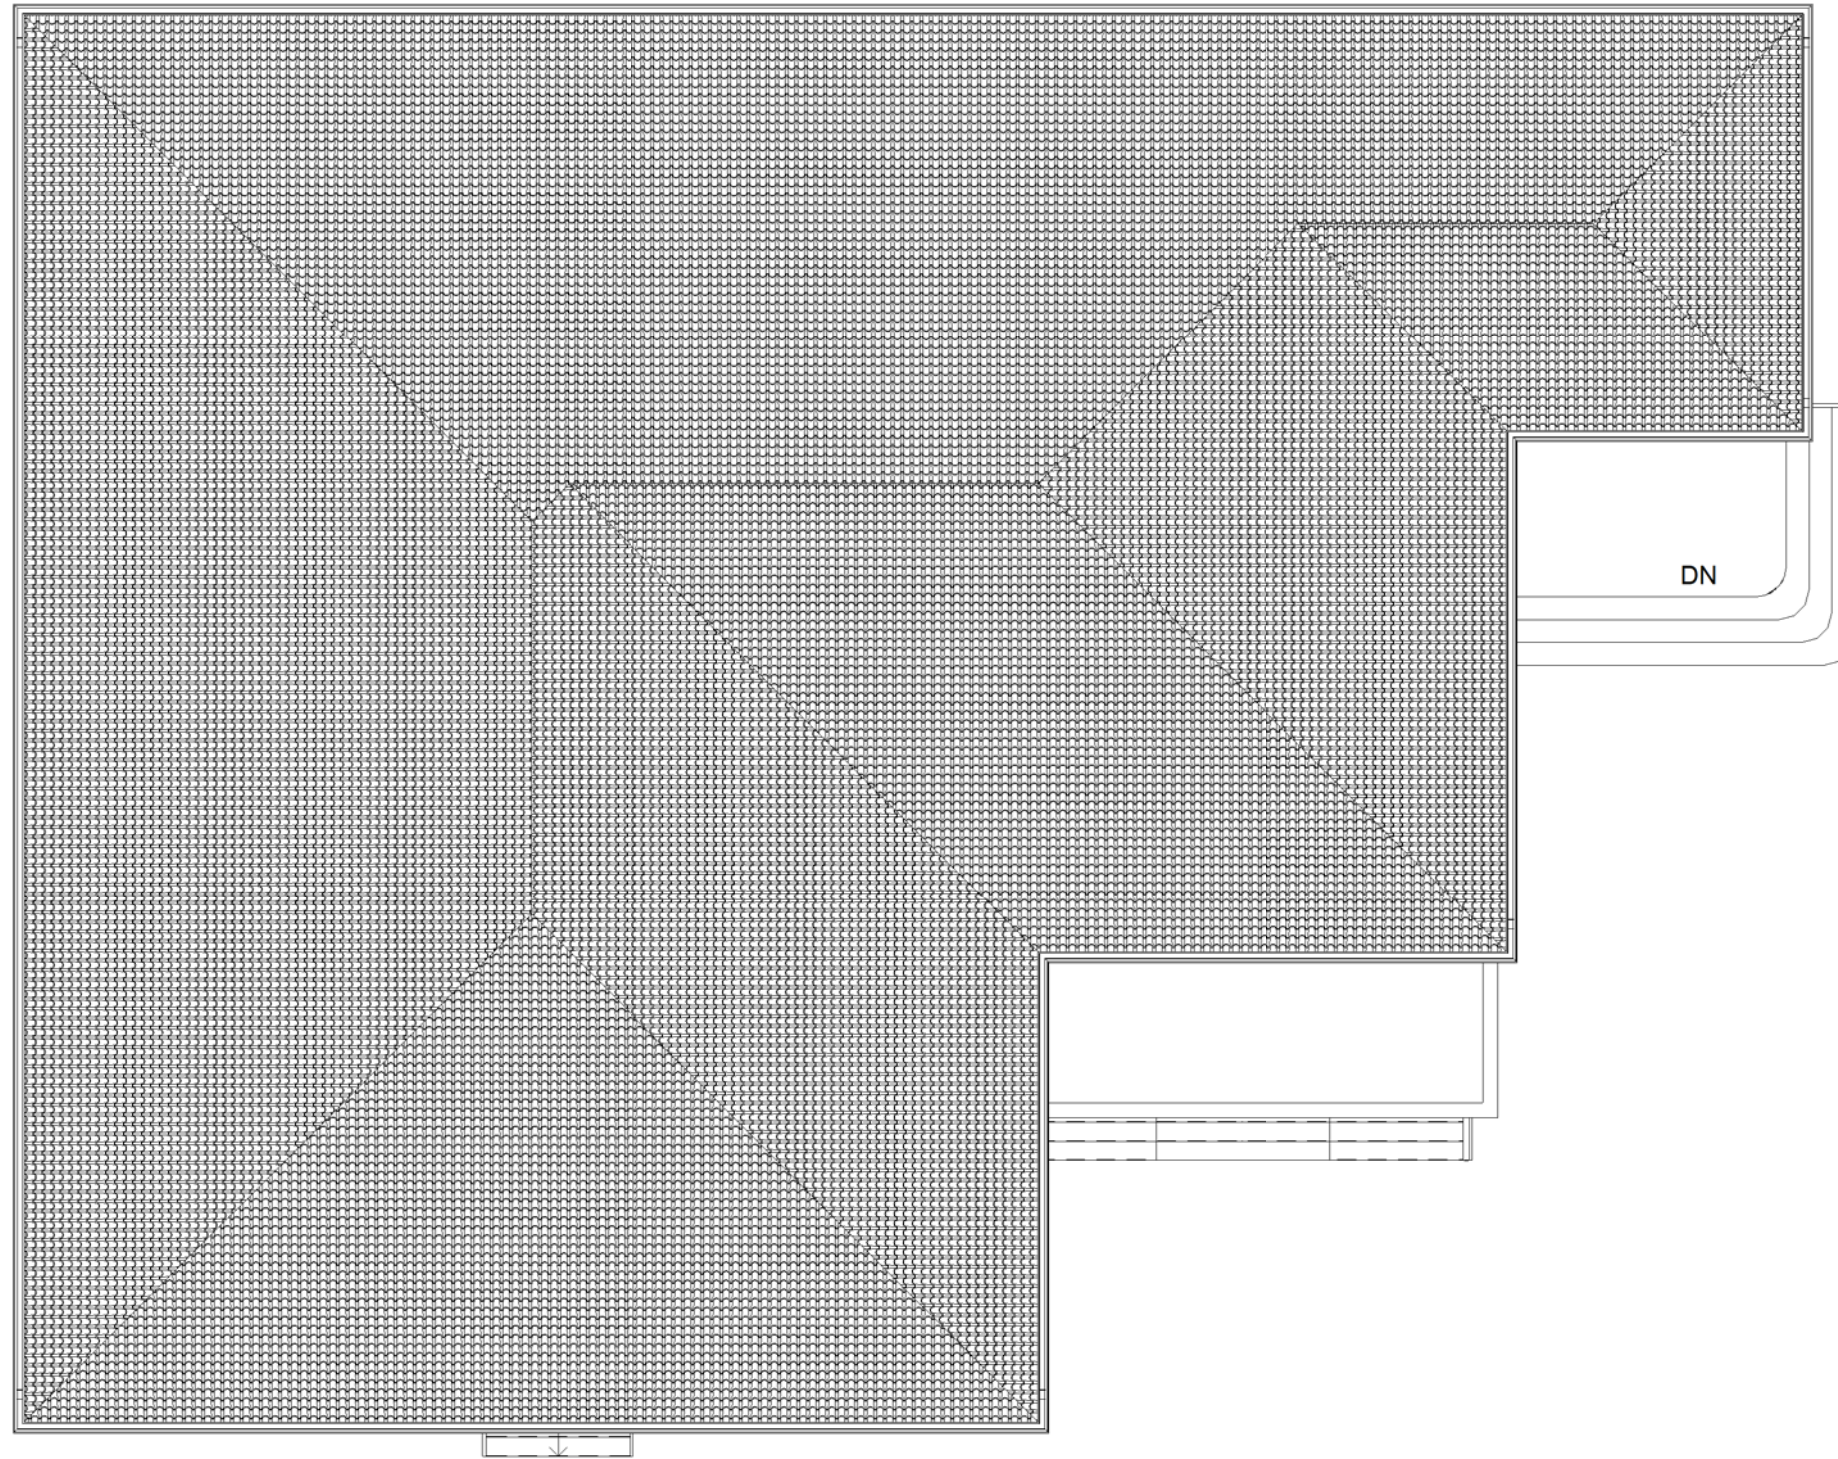

ROOF PLAN

NOTES

All dimensions are in mm unless stated Any discrepancies in the drawings should be reported to the consultants before the contractor commences work on site. All drawings and concepts remain the property of IOM.

Project.

Proposed REHABILITATION
OF LAND AUTHORITY OFFICES .
- KISMAYO TOWN - SOMALIA


Client:



Implemented by:



Drawing Title:		ROOF PLAN Main Building	
Date:			
Scale:	-	Drawing No:	
Designed by:	Eng Abdirisak Dirie	Project No:	
		sheet No: 12/25	

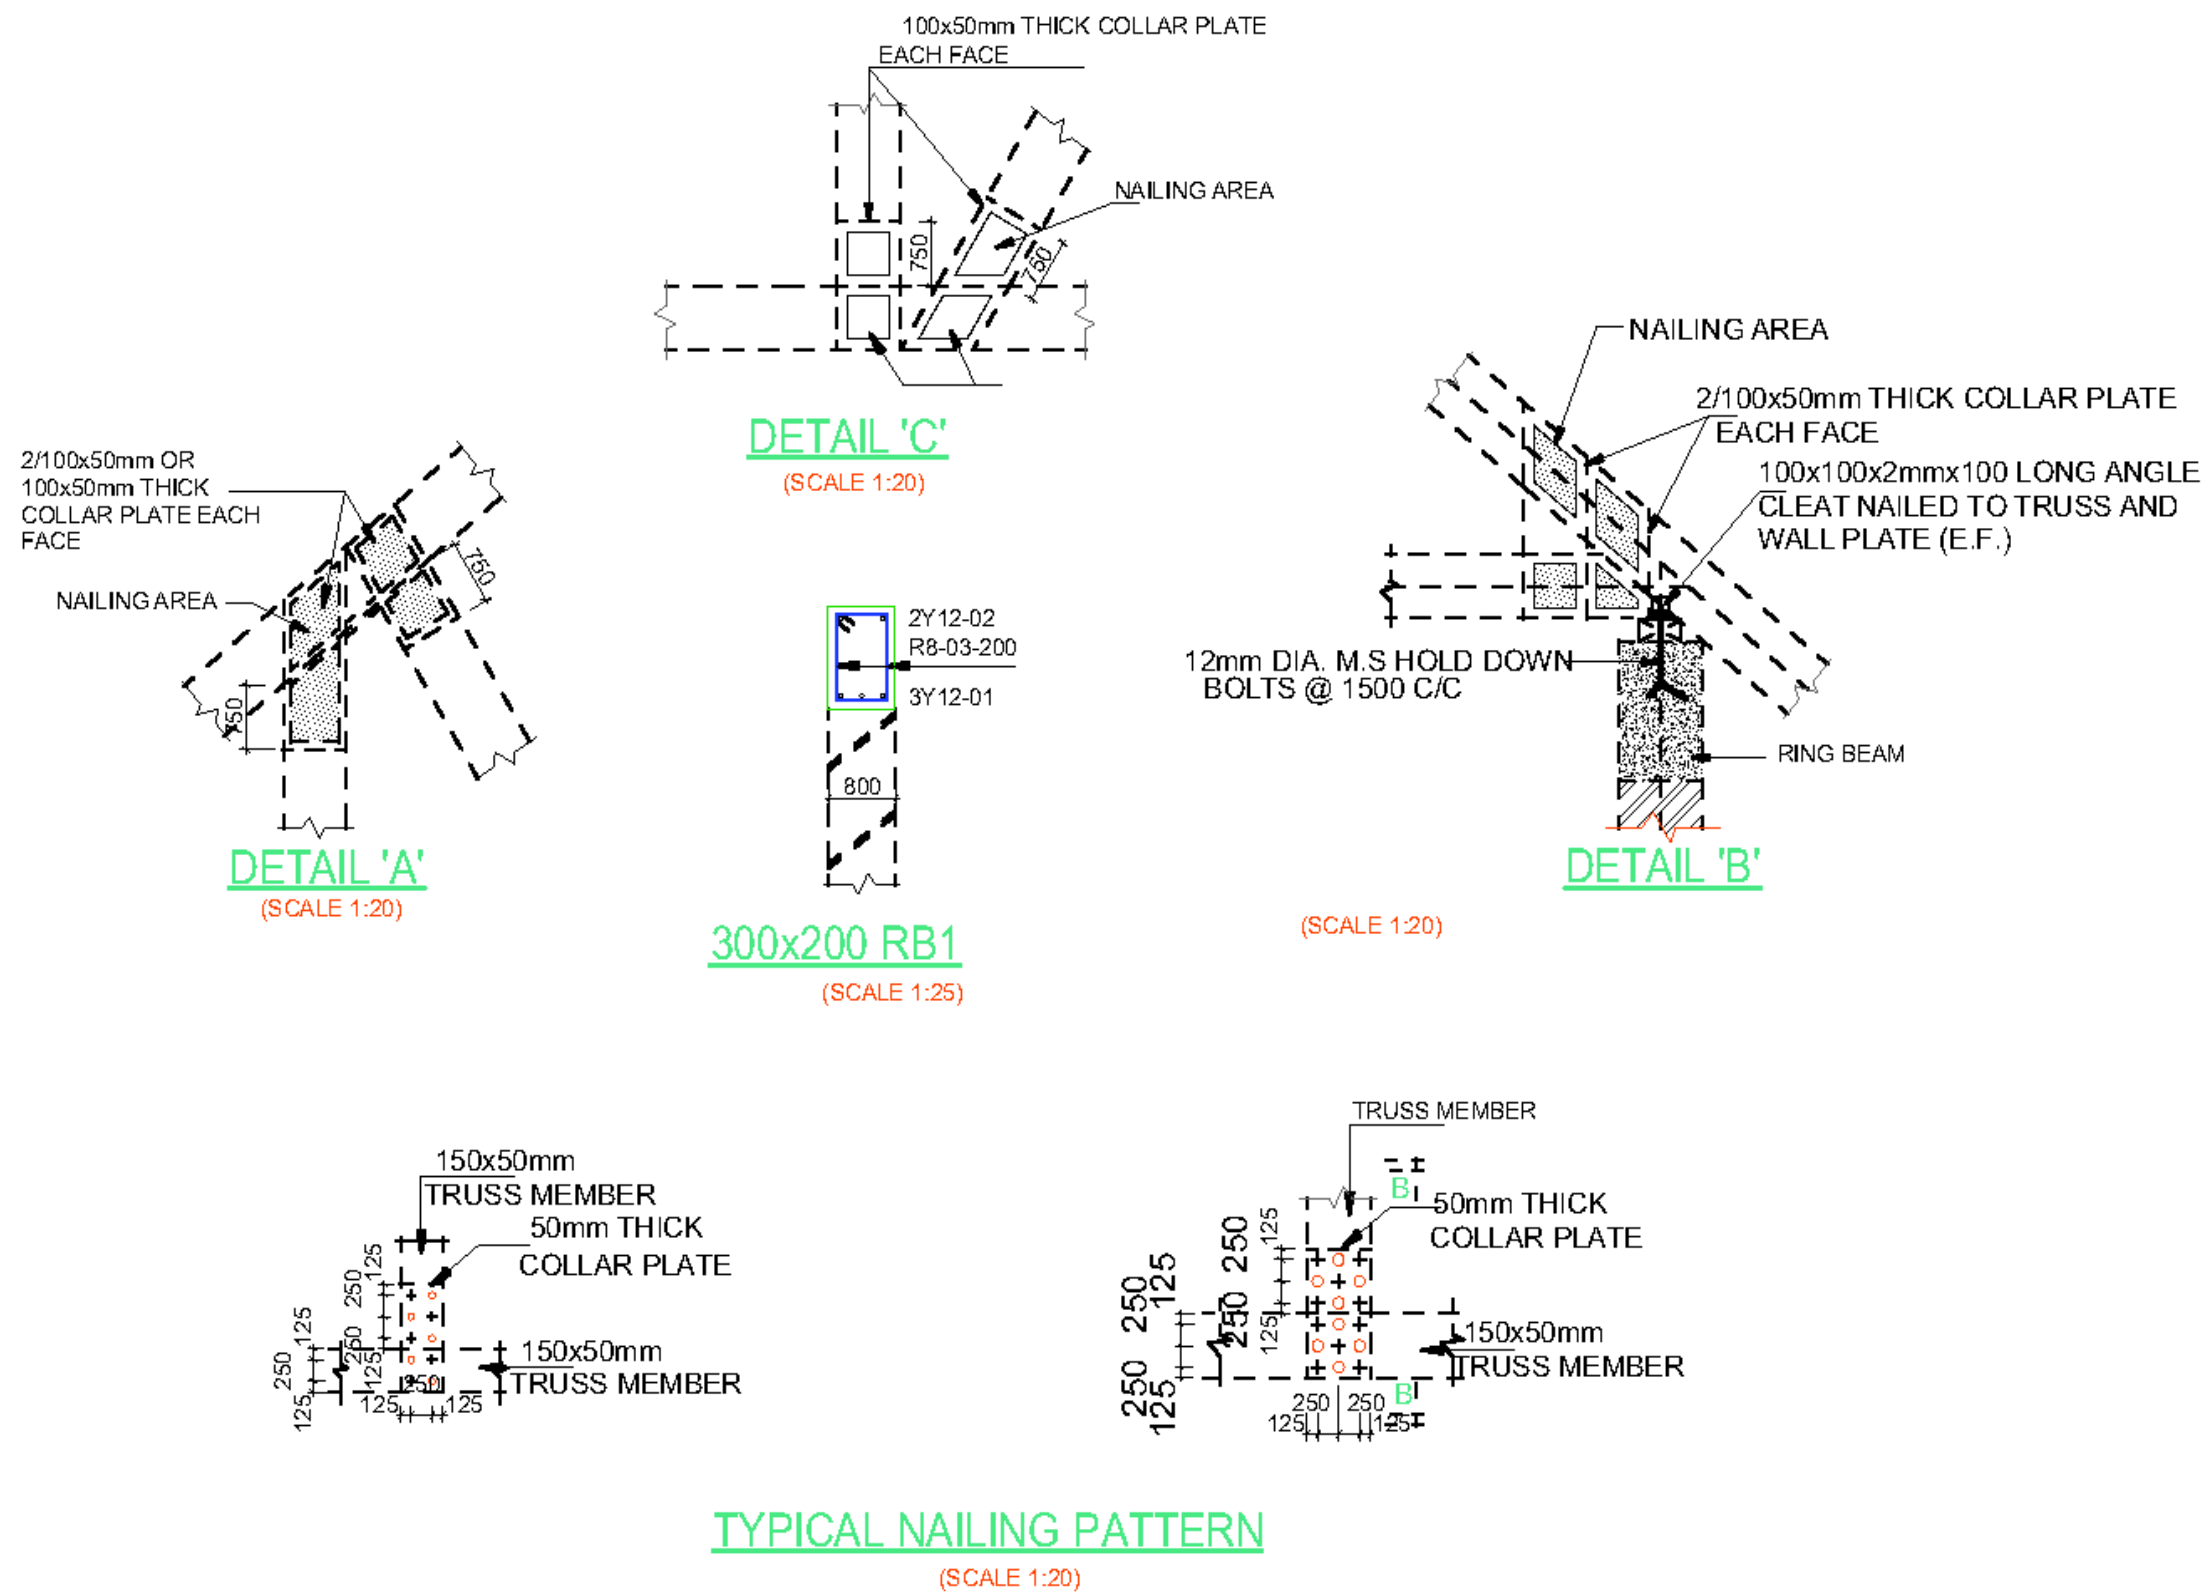


NOTES
All dimensions are in mm unless stated Any discrepancies in the drawings should be reported to the consultants before the contractor commences work on site. All drawings and concepts remain the property of IOM.

Project.
Proposed REHABILITATION OF LAND AUTHORITY OFFICES .
- KISMAYO TOWN - SOMALIA



Drawing Title:		TRUSS DETAIL Main Building	
Date:			
Scale:	-	Drawing No:	
Designed by:	Eng Abdirisak Dirie	Project No:	

sheet No:	13/25
-----------	--------------

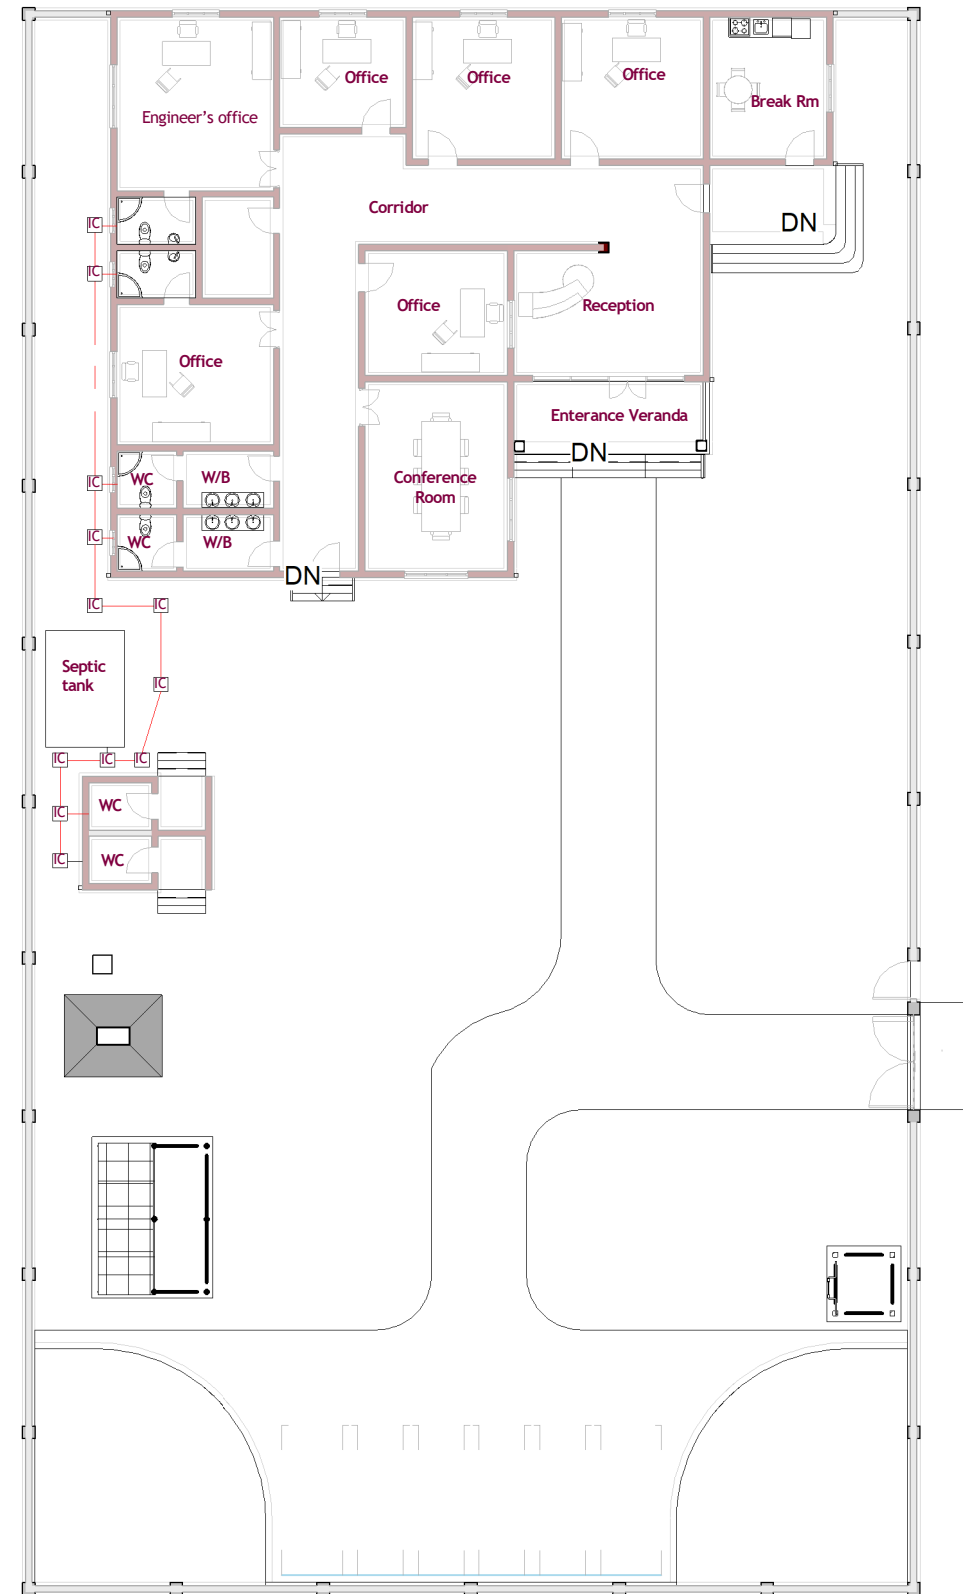

NOTES

All dimensions are in mm unless stated Any discrepancies in the drawings should be reported to the consultants before the contractor commences work on site. All drawings and concepts remain the property of IOM.

Project.

Proposed REHABILITATION
OF LAND AUTHORITY OFFICES .
- KISMAYO TOWN - SOMALIA

Client:



Implemented by:



Drawing Title:

Date:

Scale:

Designed by:

Eng Abdirisak Dirie







Drawing No:

Project No:

**DRAINAGE DETAIL
Main Building**

sheet No:

15/25

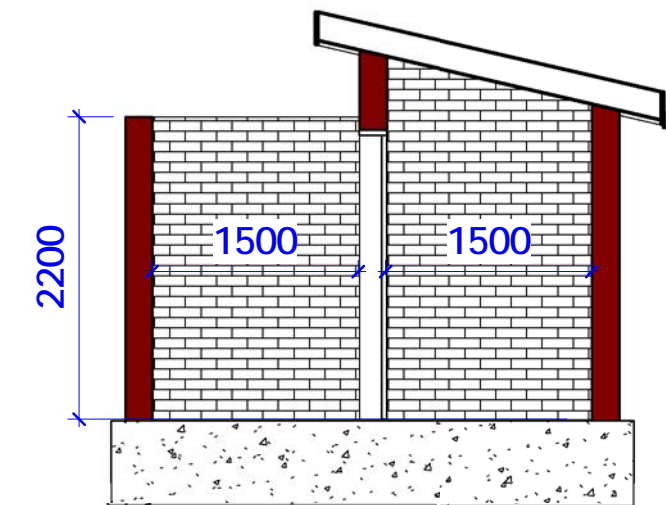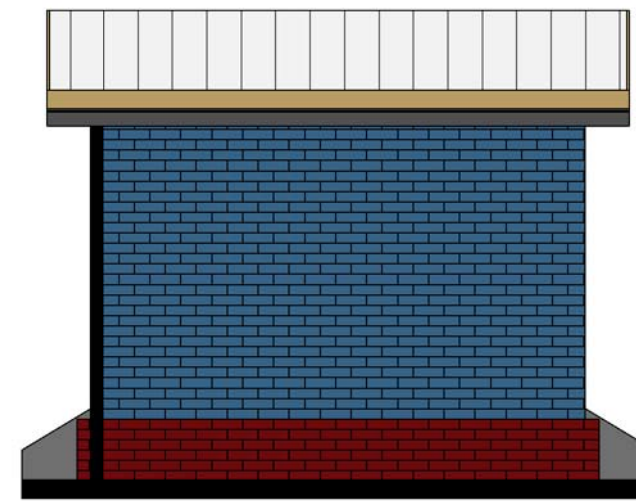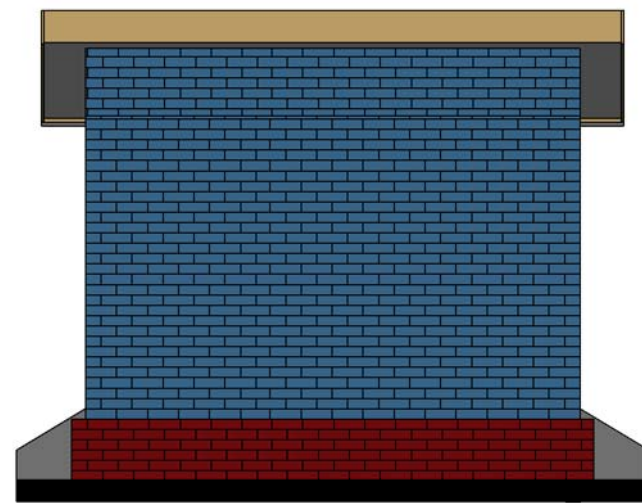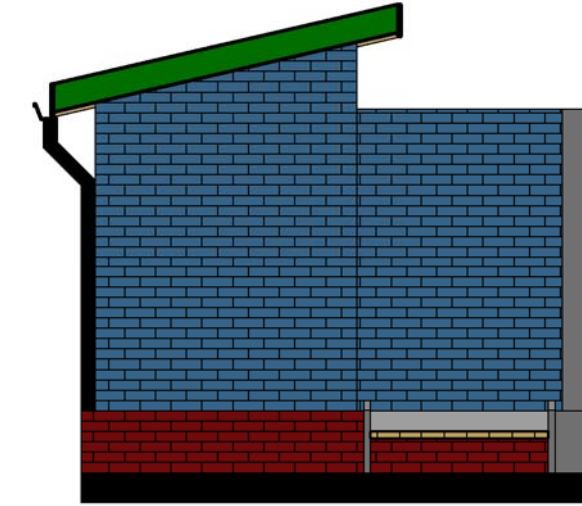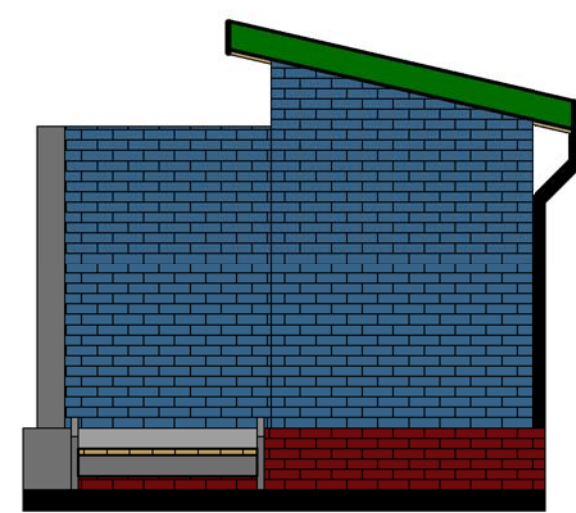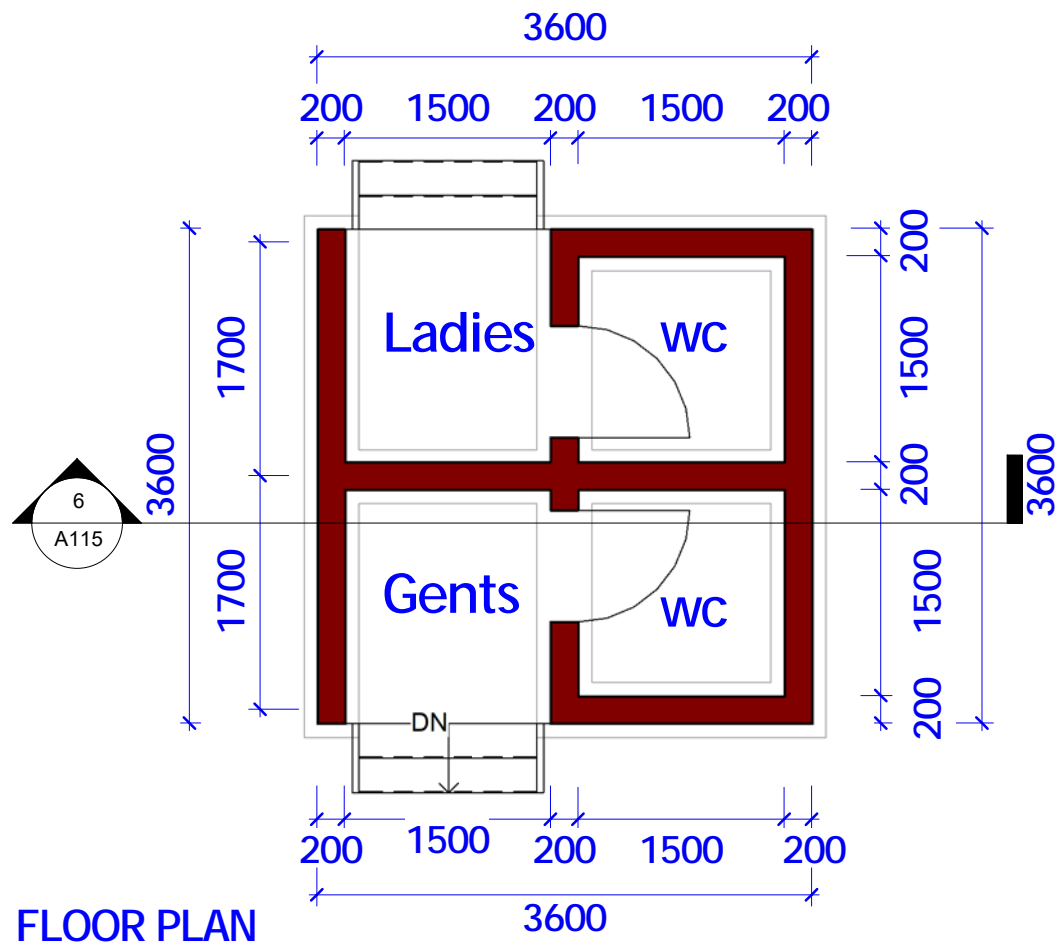

NOTES
 All dimensions are in mm unless stated Any discrepancies in the drawings should be reported to the consultants before the contractor commences work on site. All drawings and concepts remain the property of IOM.

Project.
 Proposed REHABILITATION OF LAND AUTHORITY OFFICES. - KISMAYO TOWN - SOMALIA


Client:



Implemented by:



Drawing Title:		TOILETS	
Date:		Drawing No:	
Scale:		Project No:	
Designed by: Eng Abdirisak Dirie		sheet No: 16/25	

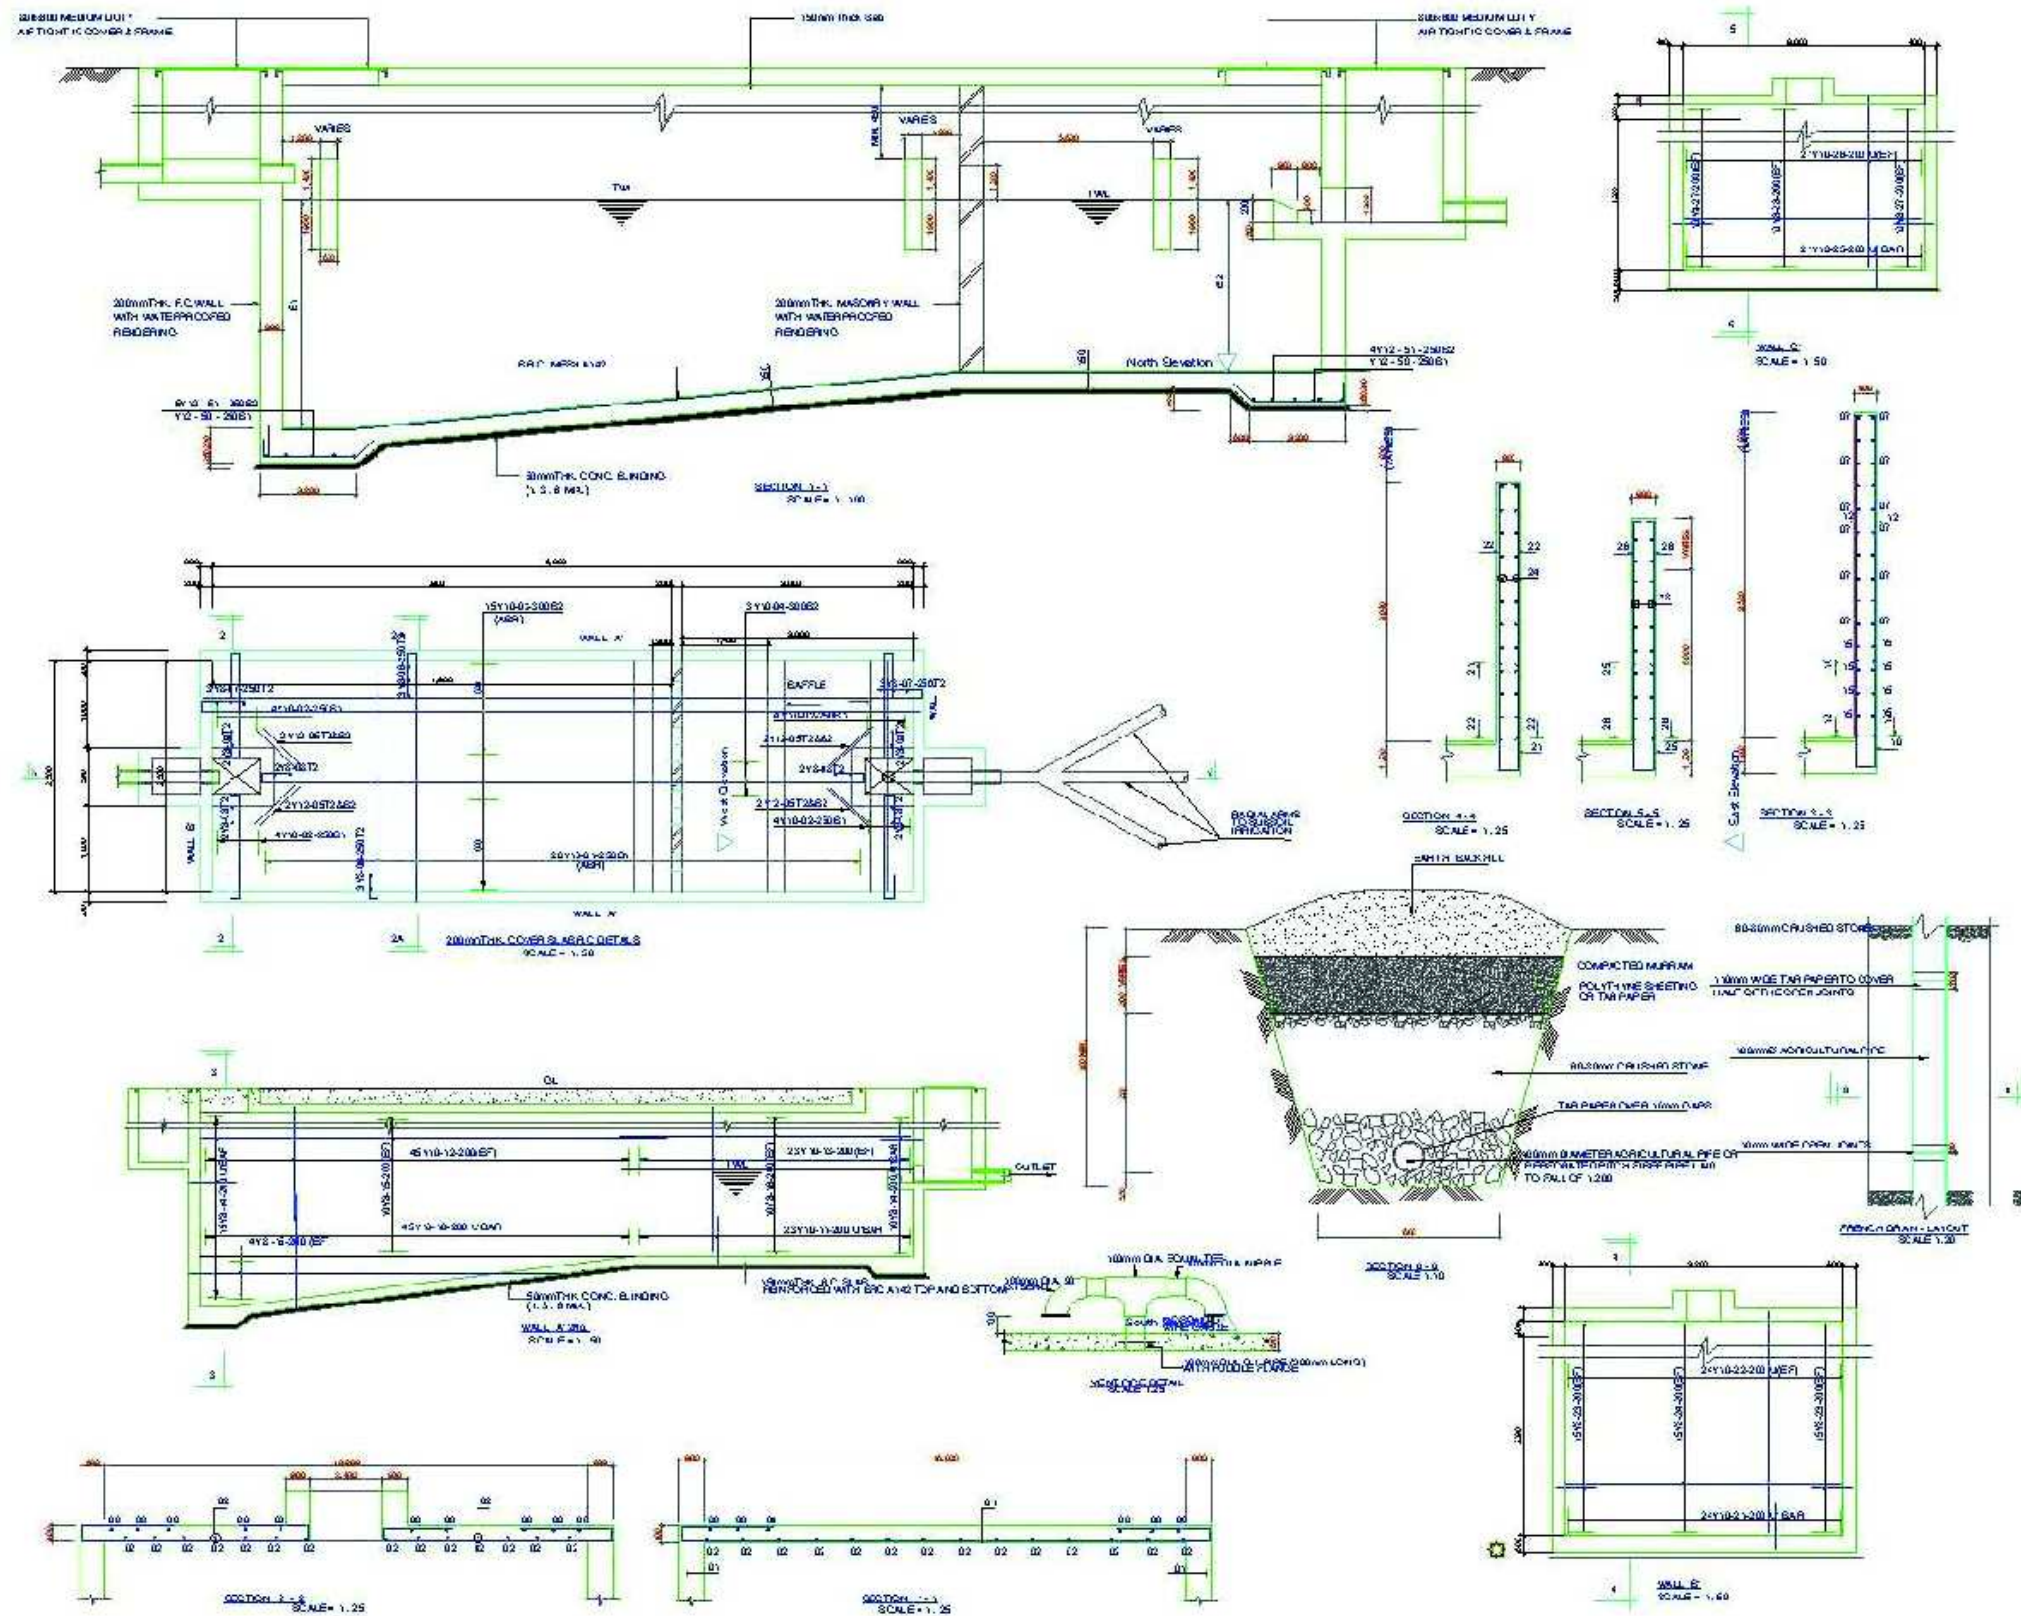


NOTES
 All dimensions are in mm unless stated Any discrepancies in the drawings should be reported to the consultants before the contractor commences work on site. All drawings and concepts remain the property of IOM.

Project.
 Proposed REHABILITATION
 OF LAND AUTHORITY OFFICES
 - KISMAYO TOWN - SOMALIA



Drawing Title:		SEPTIC TANK
Date:		
Scale:	Drawing No:	sheet No: 17/25
Designed by: Eng Abdirisak Dirie	Project No:	

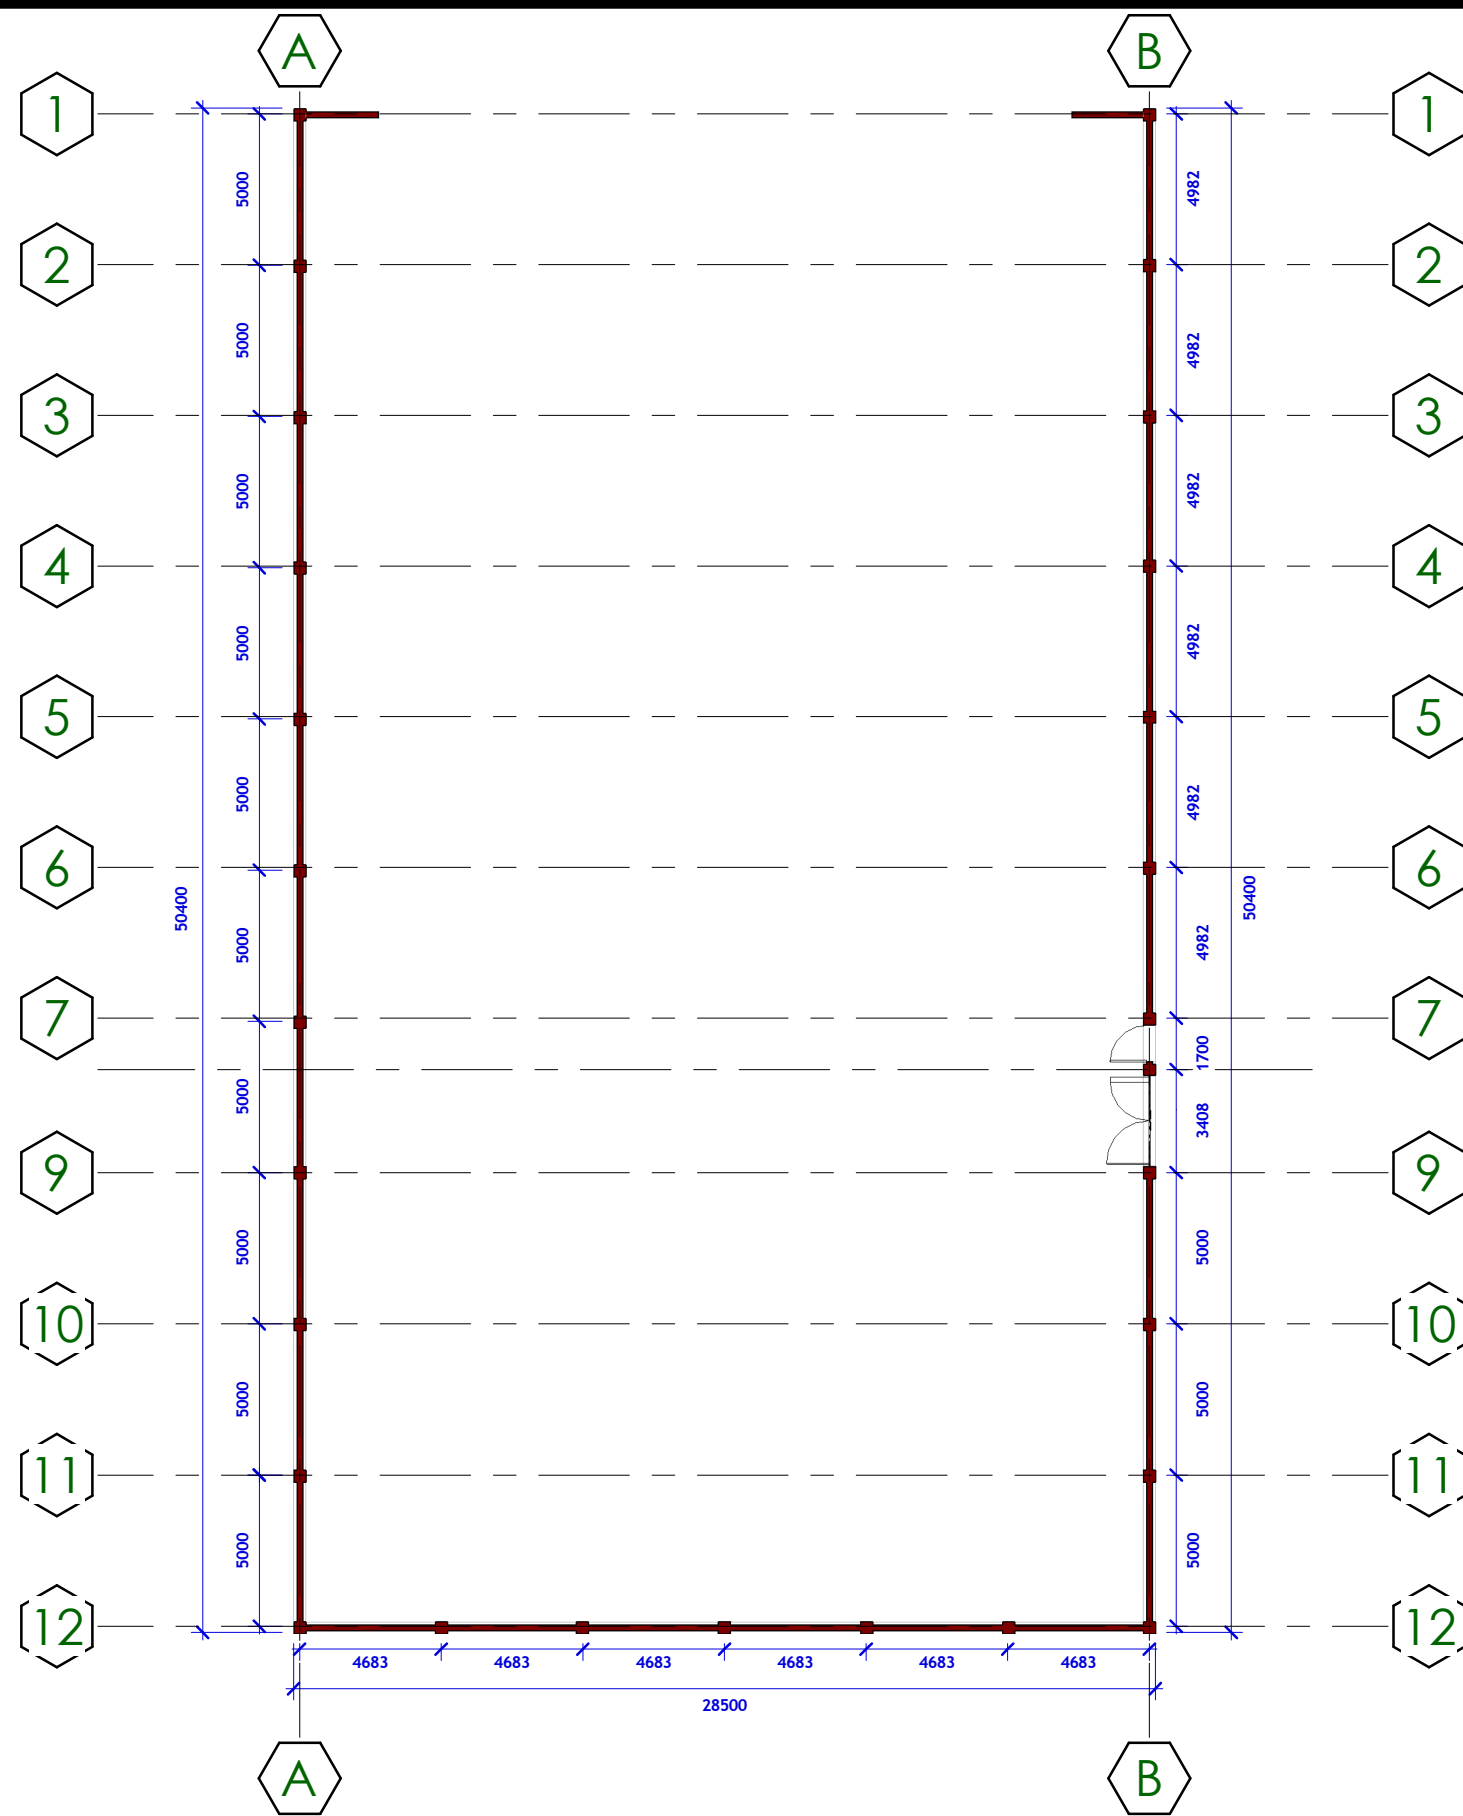

NOTES

All dimensions are in mm unless stated Any discrepancies in the drawings should be reported to the consultants before the contractor commences work on site. All drawings and concepts remain the property of IOM.

Project.

Proposed REHABILITATION OF LAND AUTHORITY OFFICES .
- KISMAYO TOWN - SOMALIA





Client:



Implemented by:



Drawing Title:		FLOOR PLAN BOUNDARY WALL	
Date:		Drawing No:	
Scale:		Project No:	
Designed by: Eng Abdirisak Dirie		sheet No: 18/25	

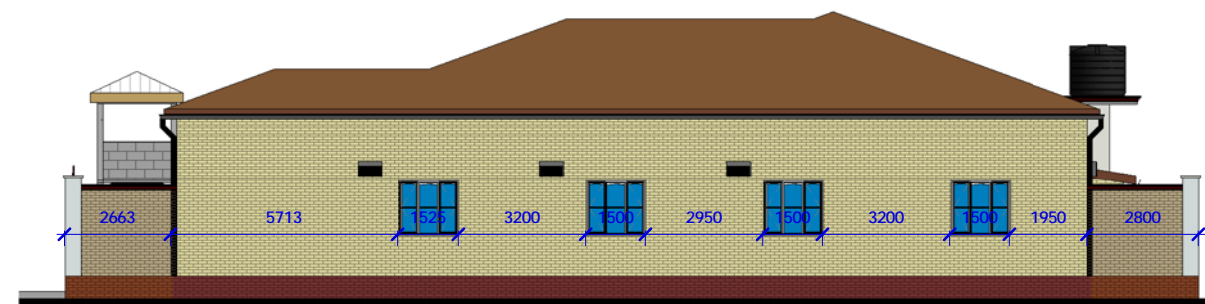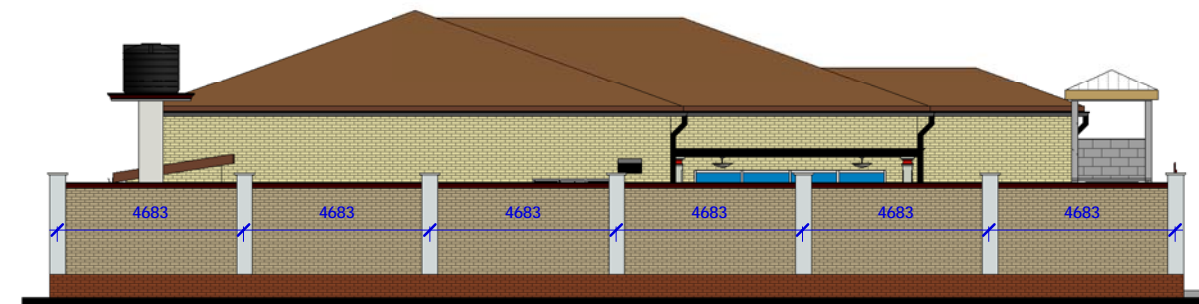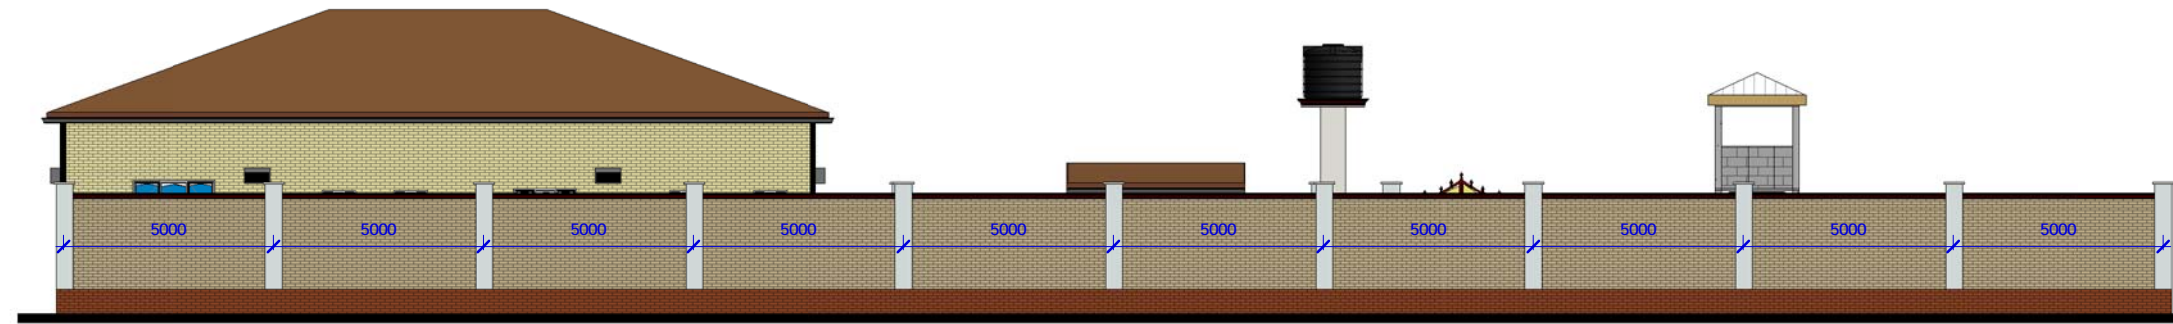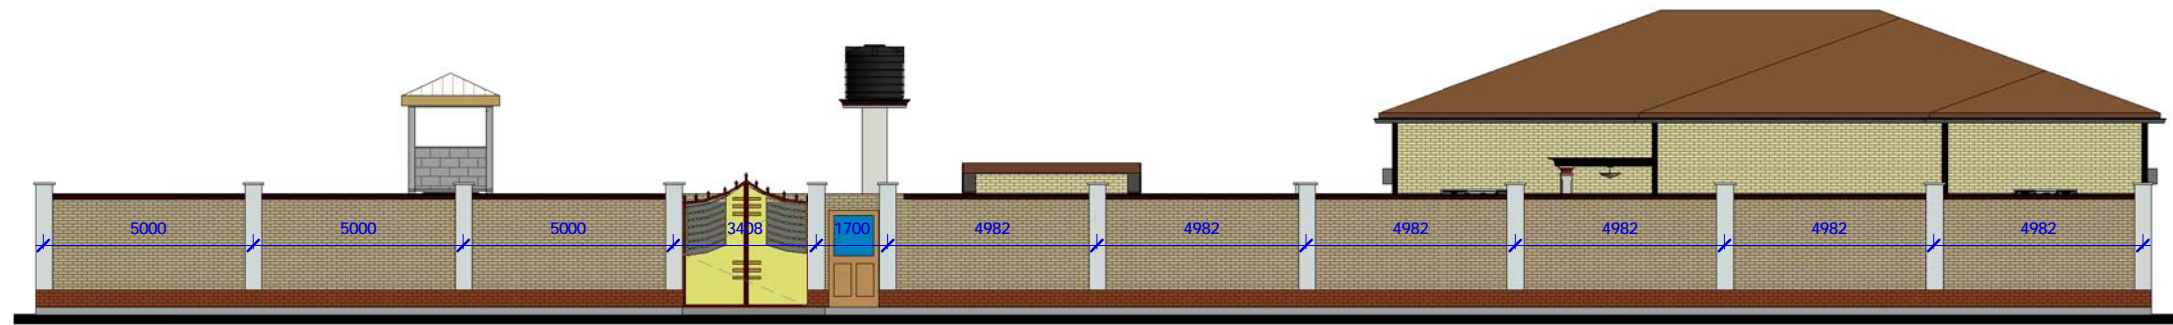

NOTES
 All dimensions are in mm unless stated Any discrepancies in the drawings should be reported to the consultants before the contractor commences work on site.
 All drawings and concepts remain the property of IOM.

Project.
 Proposed REHABILITATION
 OF LAND AUTHORITY OFFICES .
 - KISMAYO TOWN - SOMALIA


Client:



Implemented by:



Drawing Title:		ELEVATIONS BOUNDARY WALL	
Date:		Sheet No:	
Scale:		19/25	
Designed by: Eng Abdirisak Dirie	Drawing No:	Project No:	

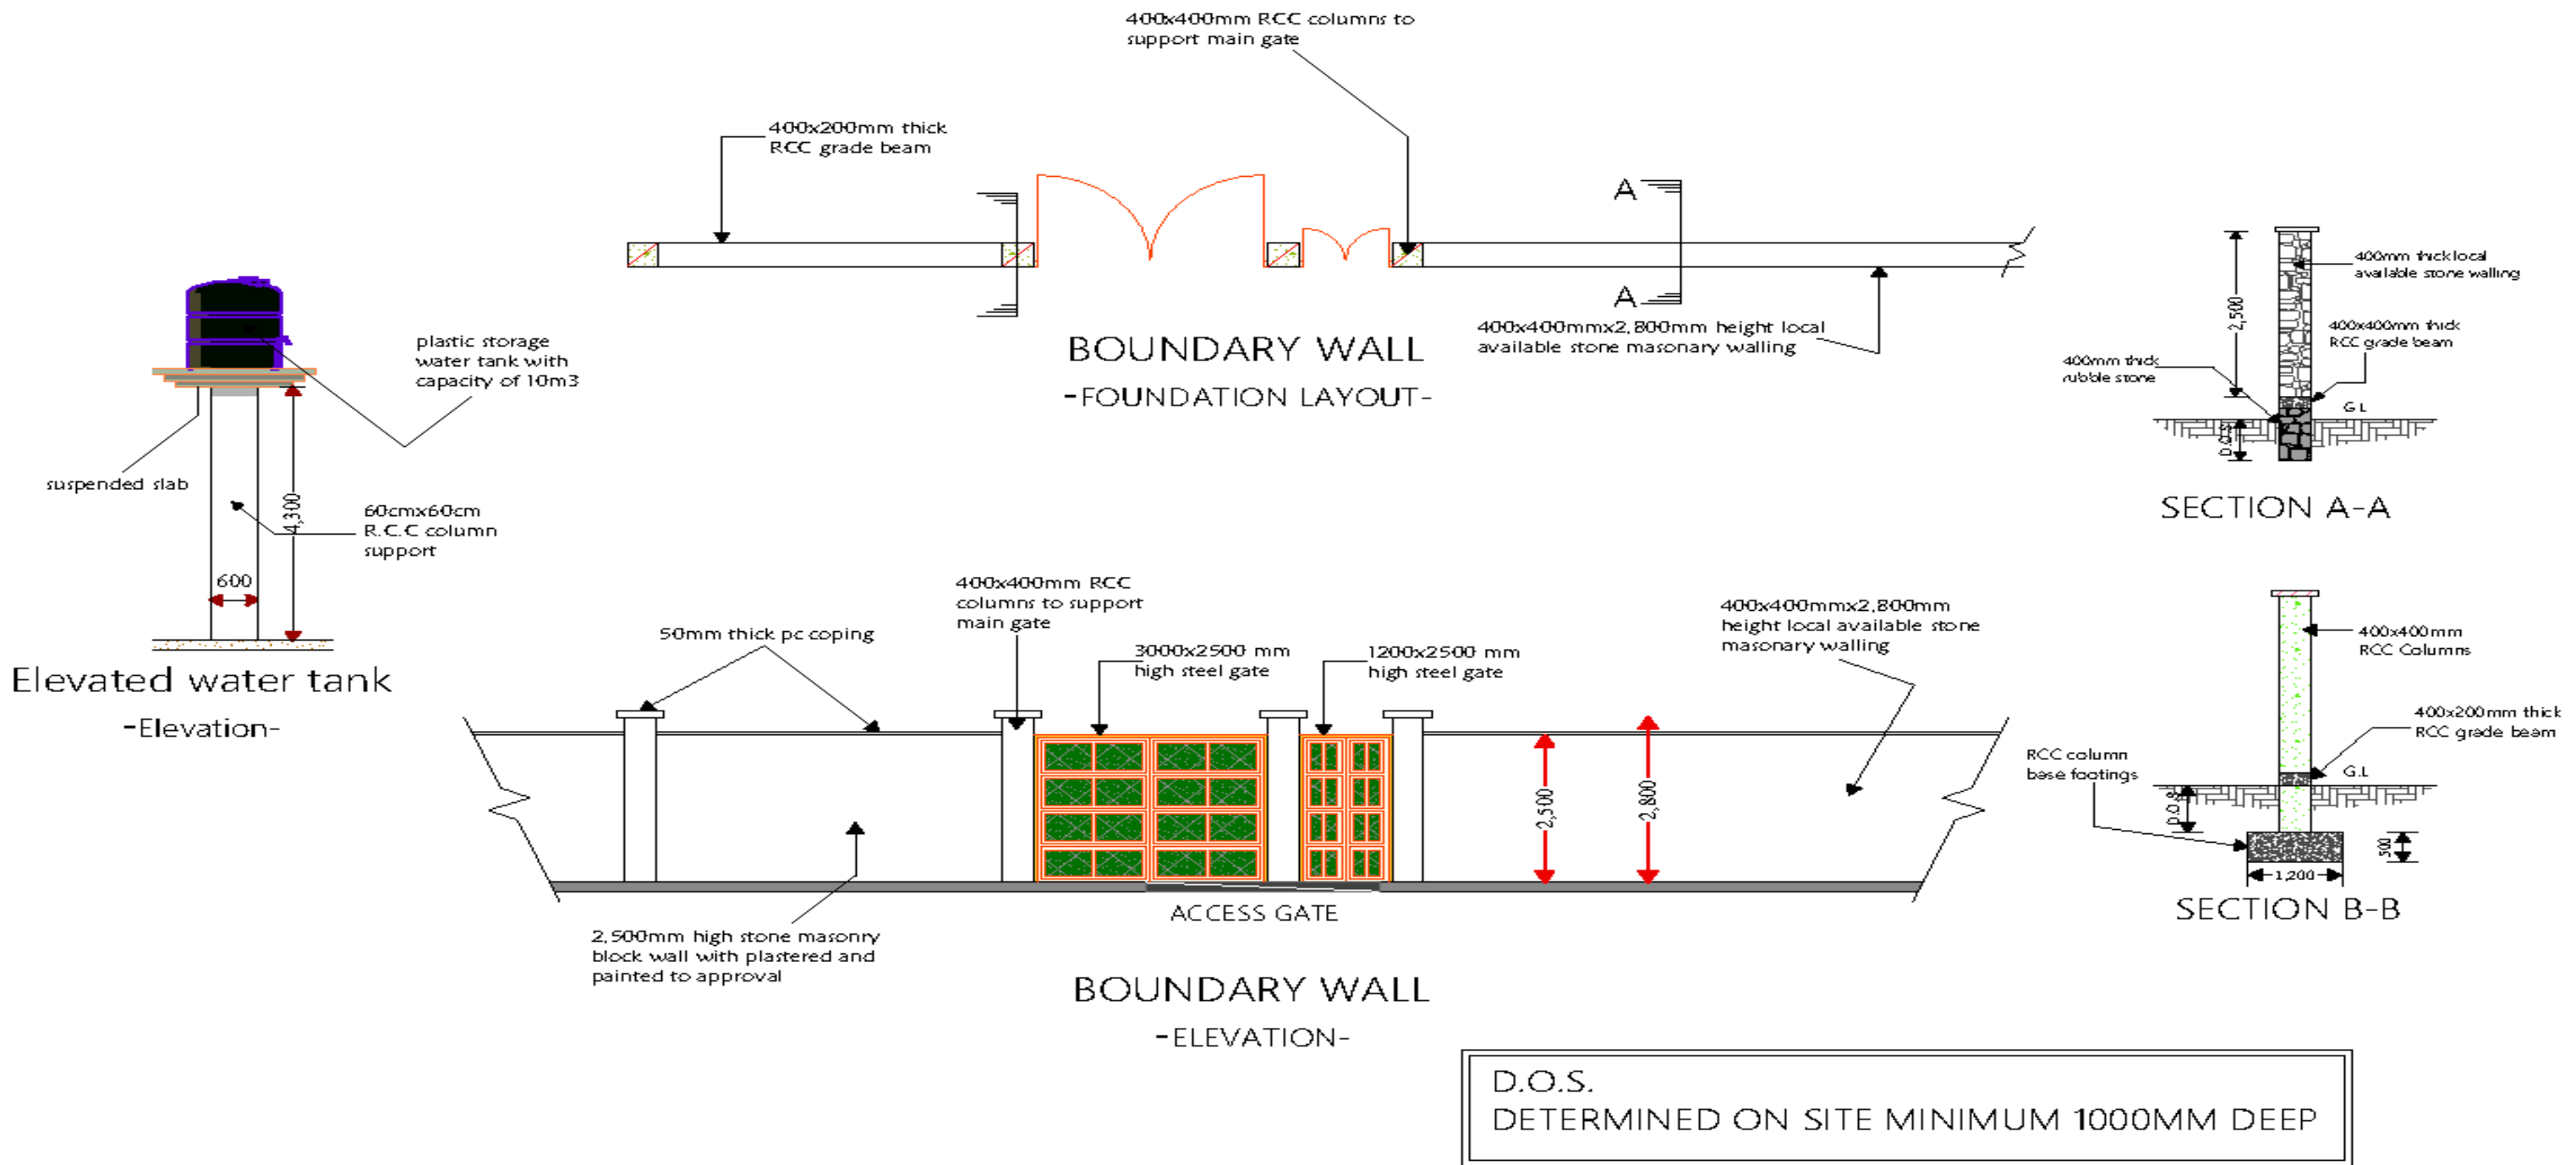

NOTES

All dimensions are in mm unless stated Any discrepancies in the drawings should be reported to the consultants before the contractor commences work on site. All drawings and concepts remain the property of IOM.

Project.

Proposed REHABILITATION OF LAND AUTHORITY OFFICES . - KISMAYO TOWN - SOMALIA


Client:




Implemented by:



Drawing Title: DETAILS BOUNDARY WALL	
Date:	
Scale:	Drawing No:
Designed by: Eng Abdirisak Dirie	Project No:
sheet No: 20/25	

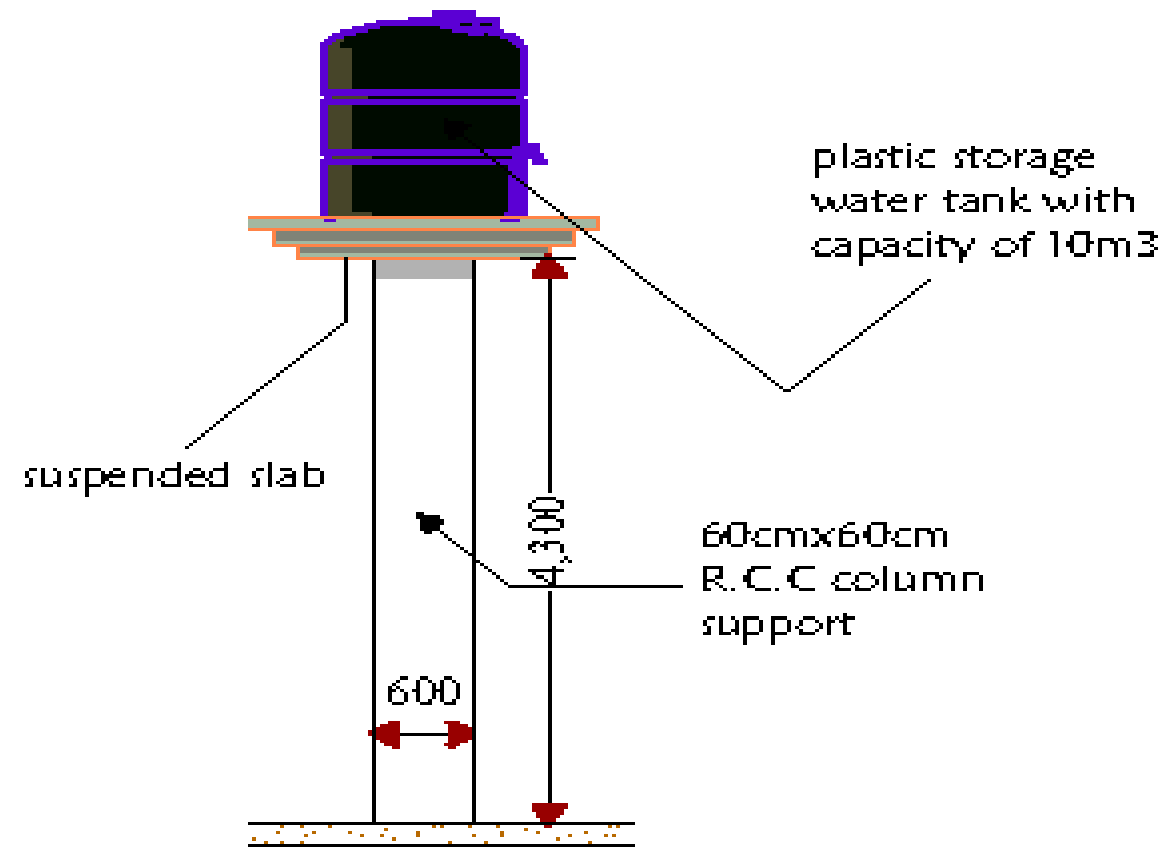

Elevated water tank
-Elevation-

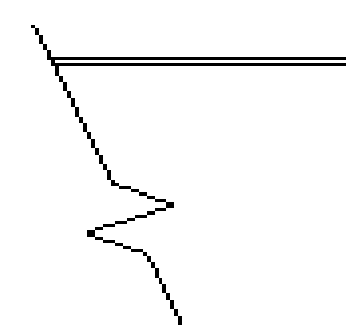

NOTES

All dimensions are in mm unless stated Any discrepancies in the drawings should be reported to the consultants before the contractor commences work on site. All drawings and concepts remain the property of IOM.

Project.

Proposed REHABILITATION
OF LAND AUTHORITY OFFICES.
- KISMAYO TOWN - SOMALIA

Client:



Implemented by:



Drawing Title:		EWT
Date:		
Scale:	Drawing No:	sheet No:
Designed by: Eng Abdirisak Dirie	Project No:	21/25



NOTES

All dimensions are in mm unless stated Any discrepancies in the drawings should be reported to the consultants before the contractor commences work on site. All drawings and concepts remain the property of IOM.

Project.

Proposed REHABILITATION
OF LAND AUTHORITY OFFICES .
- KISMAYO TOWN - SOMALIA

Client:



Implemented by:



Drawing Title:	
Date:	
Scale:	Drawing No:
Designed by: Eng Abdirisak Dirie	Project No:

3D RENDER

Sheet No:

22/25



NOTES
 All dimensions are in mm unless stated Any discrepancies in the drawings should be reported to the consultants before the contractor commences work on site.
 All drawings and concepts remain the property of IOM.

Project.
 Proposed REHABILITATION
 OF LAND AUTHORITY OFFICES .
 - KISMAYO TOWN - SOMALIA

Client:



Implemented by:



Drawing Title:	
Date:	
Scale:	Drawing No:
Designed by: Eng Abdirisak Dirie	Project No:

3D RENDER

Sheet No:
23/25



NOTES
 All dimensions are in mm unless stated Any discrepancies in the drawings should be reported to the consultants before the contractor commences work on site.
 All drawings and concepts remain the property of IOM.

Project.
 Proposed REHABILITATION
 OF LAND AUTHORITY OFFICES .
 - KISMAYO TOWN - SOMALIA

Client:



Implemented by:



Drawing Title:	
Date:	
Scale:	Drawing No:
Designed by: Eng Abdirisak Dirie	Project No:

3D RENDER
Sheet No: 24/25



NOTES

All dimensions are in mm unless stated Any discrepancies in the drawings should be reported to the consultants before the contractor commences work on site. All drawings and concepts remain the property of IOM.

Project.

Proposed REHABILITATION
OF LAND AUTHORITY OFFICES .
- KISMAYO TOWN - SOMALIA

Client:



Implemented by:



Drawing Title:	
Date:	
Scale:	Drawing No:
Designed by: Eng Abdirisak Dirie	Project No:

3D RENDER
Sheet No: 25/25